



Planning/Zoning Application

Planning & Zoning Department

Submitted On:

Dec 6, 2023, 11:40AM EST

Parcel Number: (Include ALL parcels)	ED-F0081-1
Nearest property address to the project site:	Street Address: 411 Destiny Drive City: De Pere State: W Zip: 54115
Check each project type that is being applied for:	Site Plan
Number of outlots in the CSM:	
De Pere Zoning Districts:	PI-1
Number of lots in the CSM:	
Number of lots in the Final Plat: (PLEASE USE NUMERALS ONLY.)	
Number of outlots in the Final Plat: (PLEASE USE NUMERALS ONLY.)	
Existing Site Land Uses:	Commercial
Proposed Site Land Uses:	Commercial
Does the project comply with the Comprehensive Plan?	Yes
Has City Staff been contacted for a pre-consultation meeting?	No
Property Owner:	First Name: Caleb Last Name: Hayes
Is the property owner's address the same as the nearest property address?	Yes
Property Owner's Phone Number:	920-309-1037
Property Owner's Email Address:	caleb@calebhayes.com
Is someone processing the project for the property owner as their authorized representative?	Yes
Authorized Representative's	First Name: Mathew

Name:		Last Name: Litchfield
Authorized Representative's Business Name:		Mach IV Engineering & Surveying, LLC
Authorized Representative's Phone Number:		920-569-5765
Authorized Representative's Email Address:		mlitchfield@mach-iv.com
Please attach a PDF copy of the site plan.		2109-01-23 Eng and Arch.pdf
Would you like a basic checklist of information to include in the site plan?		Yes
How do you plan on paying for your application?		Mail a check
Total Due:		\$350.00
Signature Data	First Name: Mathew	
	Last Name: Litchfield	
	Email Address: mlitchfield@mach-iv.com	
		
		Signed at: December 6, 2023 11:39am America/New_York
User's Session Information		IP Address: 69.129.142.130 Referrer URL:

CITY OF DE PERE

335 South Broadway, De Pere, WI 54115 | www.de-pere.org



October 7, 2024

Mathew Litchfield
Mach IV Engineering & Surveying LLC
2260 Salscheider CT
Green Bay, WI 54313

RE: Revised Site Plan Review for the Destiny Church Addition at 411 Destiny DR
(Parcel ED-F0081-1)

Dear Mathew:

Thank you for the revised site plan for the Destiny Church Addition at 411 Destiny DR. The City of De Pere staff reviewed the site plan on October 7, 2024, and recommended approval with the following conditions that must be addressed prior to obtaining occupancy permits.

- Health Department staff has a few clarifying questions and requests a copy of the proposed "menu". Provide information to Health Department.
- A sign permit(s) is required for the site plan signage.
- After the exterior lighting is installed, provide a statement from the lighting installer that the light spill from the property does not exceed the approved photometric plan.
- After landscaping is installed, provide a statement from the landscaper that verifies that all landscaping has been installed according to the approved landscaping plan to minimize delays or violations related to this topic.

You may now proceed to the Inspection Division to begin the process of obtaining permits. Should you have any questions regarding the decision or require further information, feel free to contact me at 339-4043 or pschleinz@deperewi.gov.

Sincerely,

A handwritten signature in black ink that reads "Peter Schleinz". The signature is fluid and cursive, with a long horizontal stroke extending to the right.

Peter Schleinz
Senior Planner | Zoning Administrator

cc: Daniel J. Lindstrom, AICP, Development Services Director
Dennis Jensen, Senior Building Inspector

COVER SHEET

LEGAL DESCRIPTION



ALL OF LOT 1 OF VOLUME 39, CERTIFIED SURVEY MAPS, PAGE 175, BEING PART OF THE SOUTHWEST 1/4 OF THE SOUTHEAST 1/4 OF SECTION 23, T23N-R20E, CITY OF DE PERE, BROWN COUNTY, WISCONSIN

CIVIL SHEETS INDEX

- C0.1 COVER SHEET
- C1.0 DEMOLITION PLAN
- C2.0 SITE PLAN
- C3.0 UTILITY & GRADING PLAN
- C4.0 EROSION CONTROL PLAN
- C5.0 EROSION CONTROL & SITE DETAILS
- L1.0 LANDSCAPE PLAN

CIVIL GENERAL NOTES:

- SURVEY WAS PERFORMED BY MACH IV ENGINEERING & SURVEYING LLC NOVEMBER 6 & 7, 2023.
- SURVEY VERTICAL DATUM IS NAVD88.
- THIS SURVEY DOES NOT GUARANTEE THE EXISTENCE/ NON-EXISTENCE, SIZE, TYPE OR LOCATION OF UNDERGROUND UTILITIES. UTILITIES SHOWN ARE BASED ON ABOVEGROUND UTILITY STRUCTURES (I.E. VALVES, MANHOLES ETC.), AND AVAILABLE UTILITY MAPS AND PLANS.
- UNLESS OTHERWISE INDICATED, ALL EXISTING STRUCTURES AND FACILITIES SHALL REMAIN.
- PROVIDE TURF, AS SPECIFIED TO ALL DISTURBED AREAS NOT RECEIVING PAVEMENTS, CURBS, SIDEWALKS, BUILDINGS, OR LANDSCAPING, WITHIN THE LIMITS OF CONSTRUCTION.
- NO LAND DISTURBING ACTIVITIES SHALL TAKE PLACE UNTIL ALL TEMPORARY SOIL EROSION DEVICES ARE INSTALLED.
- ALL GRADE TRANSITIONS BETWEEN NEW AND EXISTING SHALL BE SMOOTH AND GRADUAL WITH NO SHARP OR ABRUPT CHANGES.
- COORDINATE THE WORK OF ALL TRADES - VERIFY ALL FIELD CONDITIONS, QUANTITIES AND DIMENSIONS PRIOR TO COMMENCEMENT OF WORK. ANY DISCREPANCIES SHALL BE PROMPTLY BROUGHT TO THE ATTENTION OF THE ARCHITECT.
- EXECUTE ALL WORK WITH CARE AS TO PROTECT FROM DAMAGE ADJACENT EXISTING FEATURES TO REMAIN. ANY SUCH DAMAGE SHALL BE REPAIRED OR REPLACED TO MATCH THE ORIGINAL CONDITION AS APPROVED BY THE ARCHITECT.
- UNLESS REFERRED TO, OR INDICATED AS "EXISTING", ALL WORK SHOWN ON THESE DRAWINGS SHALL BE CONSIDERED AS NEW AND PROVIDED UNDER THIS CONTRACT.
- FINISHED GRADE OF TOPSOIL (AFTER COMPACTION) SHALL BE 1/2" TO 1" BELOW TOP OF ABUTTING PAVEMENTS, SIDEWALKS, AND CURBING.
- NO DISTURBANCE SHALL OCCUR OUTSIDE OF SITE LIMITS.
- GENERAL CONTRACTOR SHALL OBTAIN APPROVAL FROM OWNER AND MUNICIPALITY PRIOR TO ANY LAND DISTURBANCE OUTSIDE THE CONSTRUCTION LIMITS.
- CONTRACTOR SHALL BE RESPONSIBLE FOR OBTAINING WORK IN RIGHT OF WAY PERMITS.
- NO HAZARDOUS MATERIALS WILL BE STORED ON-SITE.
- FOR LEGEND AND ABBREVIATIONS SEE SHEET C0.1.
- FOR EROSION CONTROL PLAN AND NOTES SEE SHEET C4.0 AND C5.0.
- FOR NOTES SHOWN THUS, "Ⓢ", SEE SHEET KEY NOTES, ON SHEET THEY APPEAR.

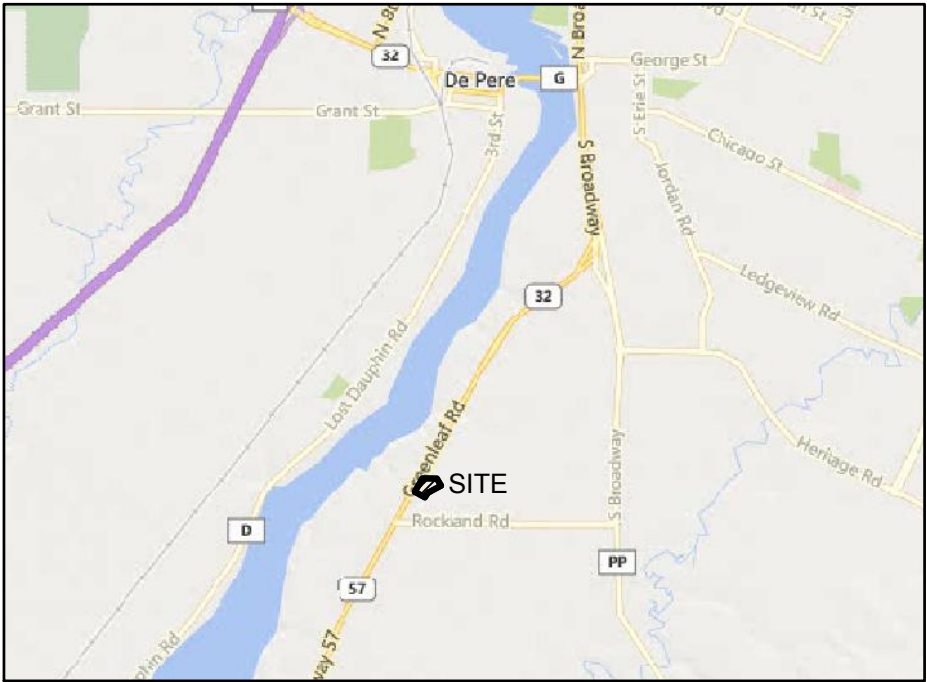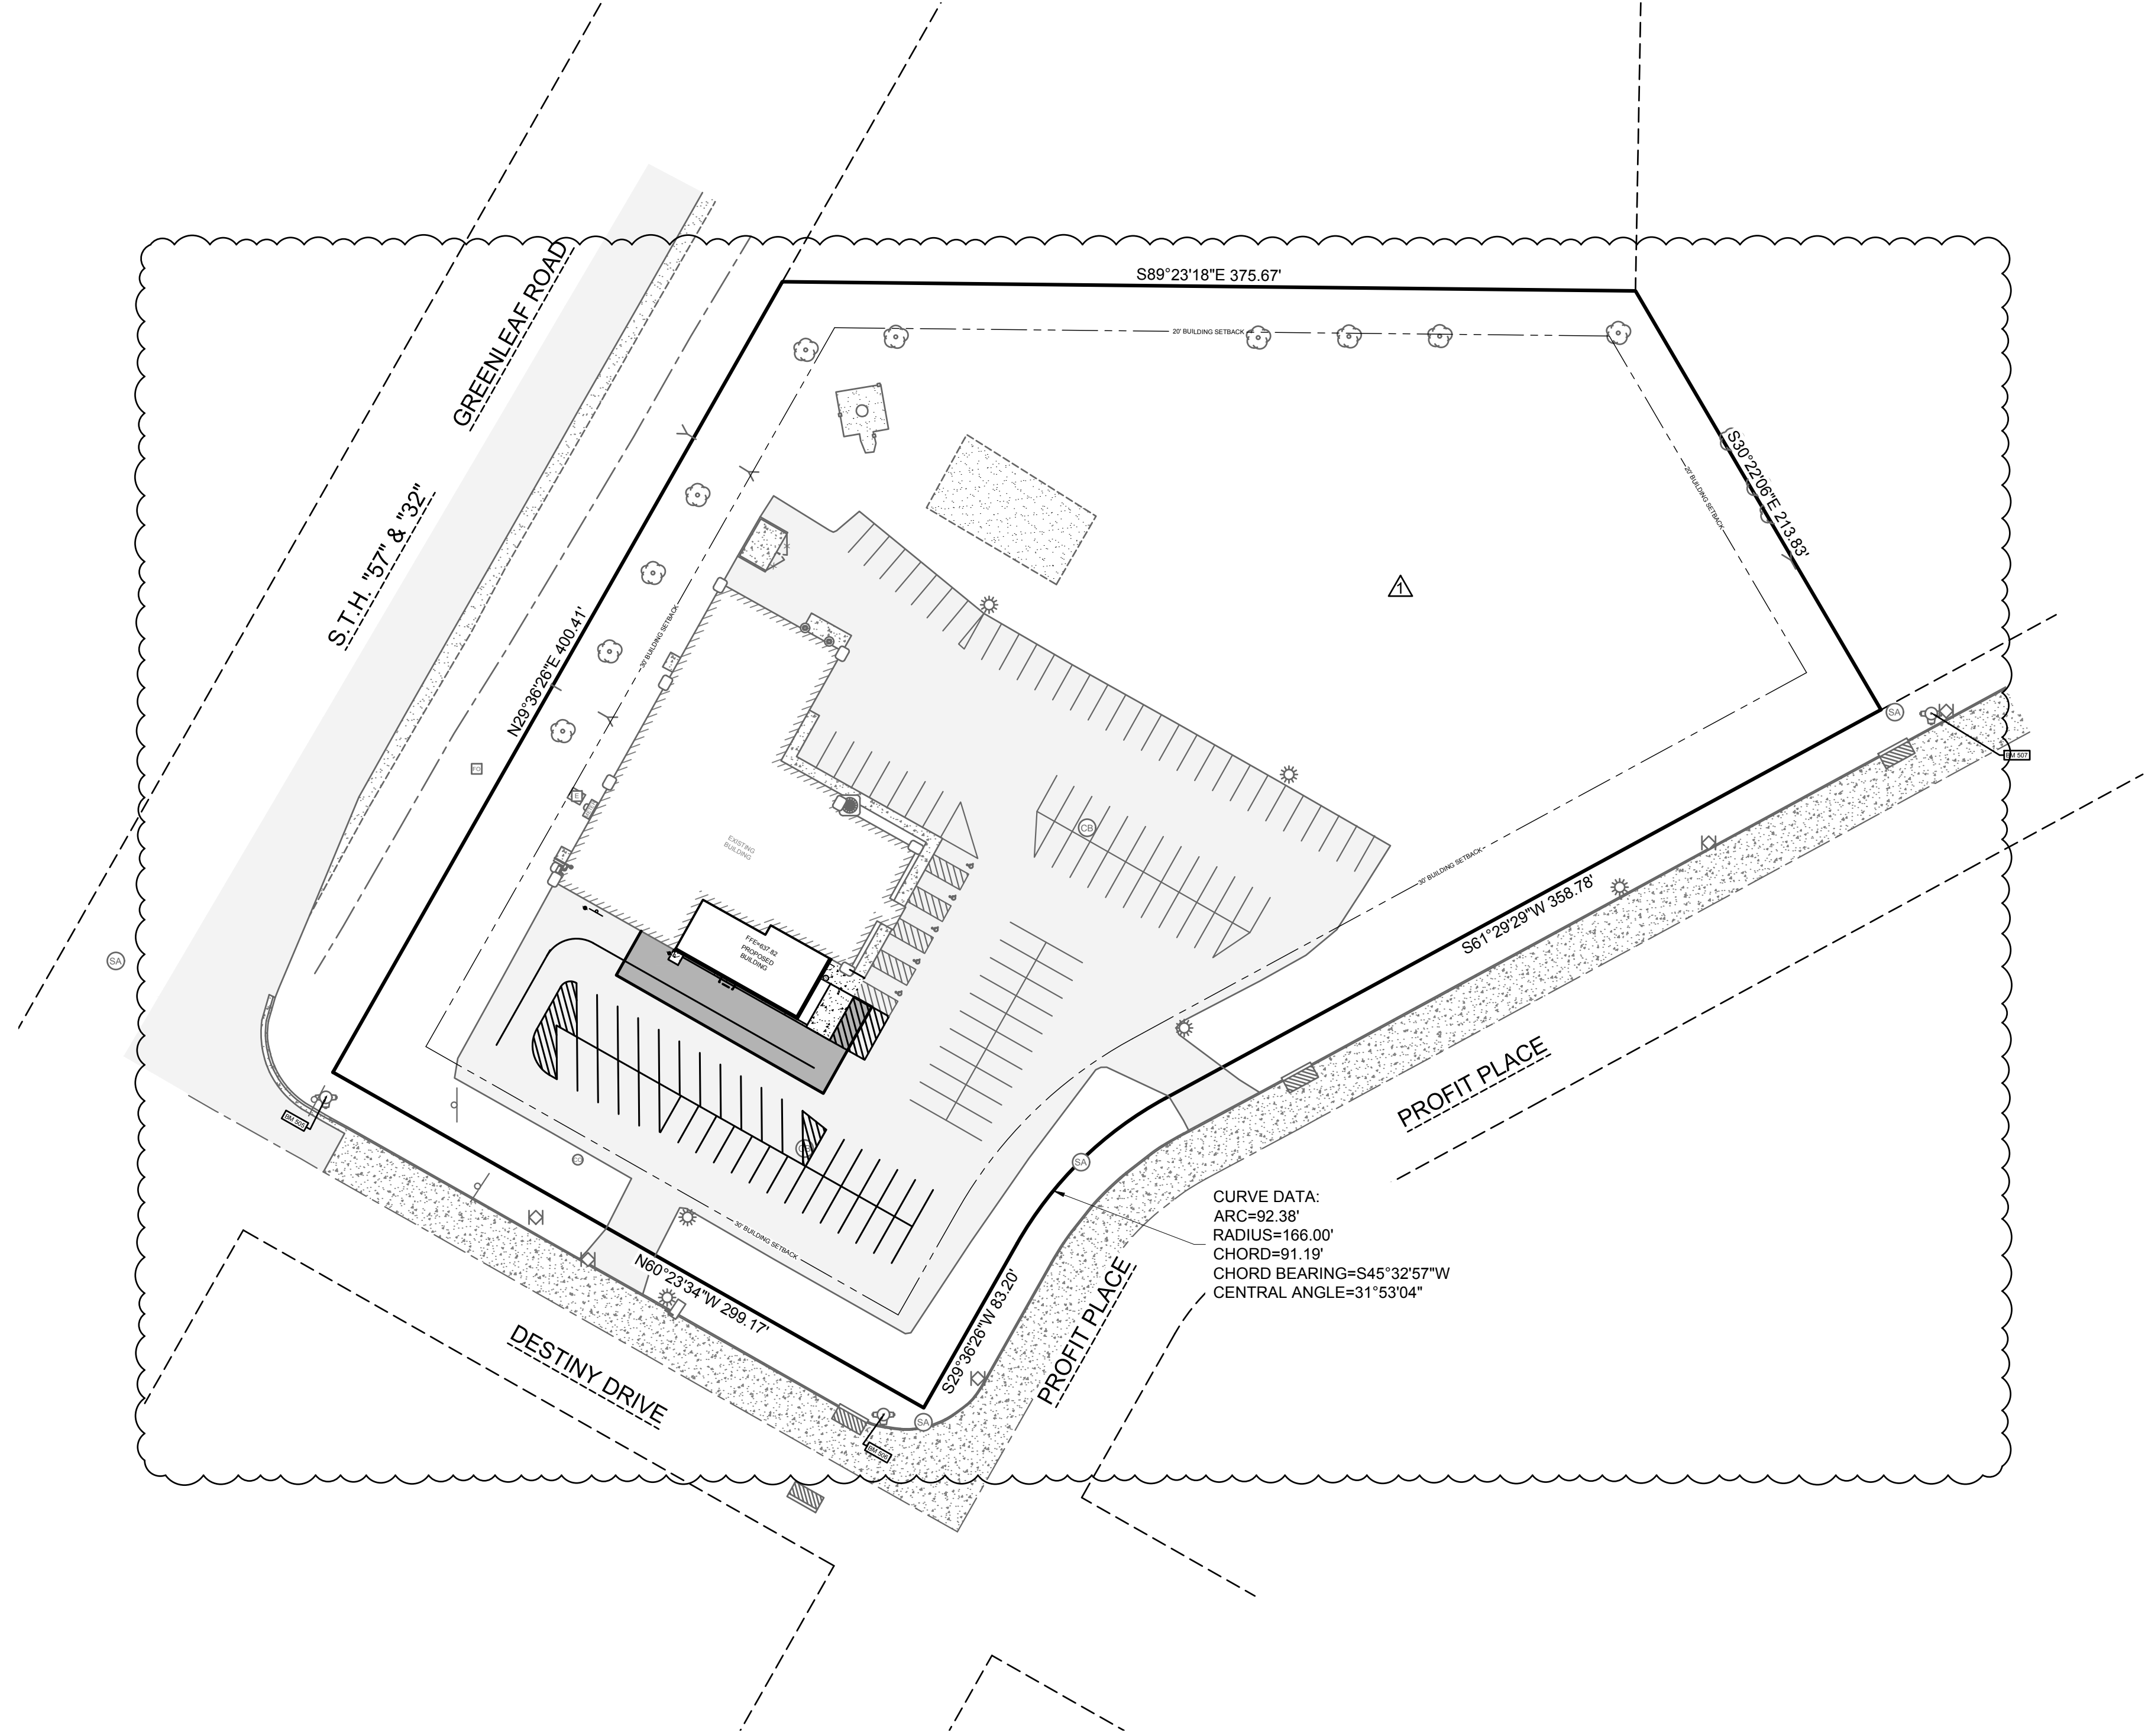

LOCATION MAP

411 DESTINY DRIVE
DE PERE, WI 54115


NOT TO SCALE

CIVIL LEGEND

ABBREVIATIONS

EXISTING	PROPOSED	EXISTING	PROPOSED	EXISTING	PROPOSED
CABLE PEDESTAL		EVERGREEN SHRUB		STANDARD DUTY ASPHALT	
ELECTRIC METER		EVERGREEN TREE		HEAVY DUTY ASPHALT	
ELECTRIC PEDESTAL		TREE		BUILDING	
GUY WIRE		TREE SHRUB		ASPHALT	
LIGHT POLE		BUILDING OVERHANG		CONCRETE	
POWER POLE		UNDERGROUND CABLE		GRAVEL	
GAS METER		UNDERGROUND WIRE		LANDSCAPE WOOD MULCH	
GAS VALVE		UNDERGROUND ELECTRIC		LANDSCAPE STONE MULCH	
BOLLARD		GAS			
HANDICAP PARKING		LANDSCAPE			
SANITARY CLEANOUT		FENCE			
SANITARY MANHOLE		GUARDRAIL			
CATCH BASIN		CENTERLINE			
CULVERT		CURB			
DOWNSPOUT		PARKING STRIPE			
INLET		SANITARY SEWER			
INLET 2' X 2'		CULVERT			
STORM CLEANOUT		STORM SEWER			
STORM MANHOLE		FIBER OPTIC			
FIBER OPTIC PEDESTAL		WOOD LINE			
SIGN		RETAINING WALL			
FIRE HYDRANT		WATERMAIN			
WATER SHUT OFF		CONTOUR MAJOR			
WATER VALVE		CONTOUR MINOR			

Ø	DIAMETER	MIN	MINIMUM
AC	ACRE	mm	MILLIMETER
AEW	APRON END WALL	N	NORTH
ASTM	AMERICAN SOCIETY FOR TESTING AND MATERIALS	NE	NORTHEAST
BM	BENCHMARK	OC	ON CENTER
C	CABLE	OD	OUTSIDE DIAMETER
CB	CATCH BASIN	OHP	OVER HEAD POWER
CI	CURB INLET	OL	OUTLOT
CMP	CORRUGATED METAL PIPE	PSI	POUNDS PER SQUARE INCH
CO	CLEAN OUT	PVC	POLYVINYL CHLORIDE
CSM	CERTIFIED SURVEY MAP	R	RADIUS
C.T.H	COUNTY TRUNK HIGHWAY	RAD	RADIUS
DIA	DIAMETER	RCP	REINFORCED CONCRETE PIPE
DOT	DEPARTMENT OF TRANSPORTATION	REQ	REQUIRED
E	EAST	S	SOUTH
EL	ELECTRIC (BURIED)	SA	SANITARY
FDM	FACILITIES DEVELOPMENT MANUAL	SAN	SANITARY
FFE	FIRST FLOOR ELEVATION	SCHD	SCHEDULE
FL	FLOW LINE	S.D.	SUMP DEPTH
FO	FIBER OPTIC	SQ	SQUARE
FT	FEET	ST	STORM
G	GAS	S.T.H	STATE TRUNK HIGHWAY
G.F.E.	GROUND FLOOR ELEVATION	STM	STORM
GR	GRADE	T	TELEPHONE
HDPE	HIGH DENSITY POLYETHYLENE	T/C	TOP OF CURB
INL	INLET	U.S.H.	UNITED STATES HIGHWAY
INV	INVERT	V	VARIES
M	METER	W	WEST
MAX	MAXIMUM	WAT	WATER
MH	MANHOLE	WI	WISCONSIN
		WisDOT	WISCONSIN DEPARTMENT OF TRANSPORTATION

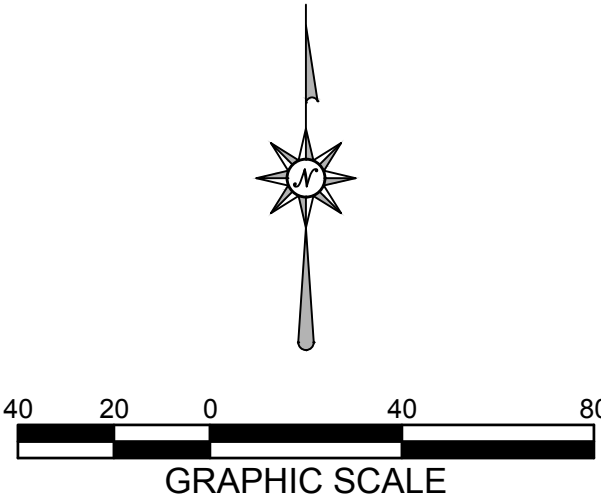

DIGGERS HOTLINE

CALL DIGGERS HOTLINE
1-800-242-8511
TOLL FREE

WISCONSIN STATUTE 182.0175 (1974) REQUIRES MIN. 3 WORK DAYS NOTICE BEFORE YOU EXCAVATE

THE LOCATIONS OF THE EXISTING UTILITY INSTALLATIONS AS SHOWN ON THE PLANS ARE APPROXIMATE. THERE MAY BE OTHER UNDERGROUND UTILITY INSTALLATIONS WITHIN THE PROJECT AREA THAT ARE NOT SHOWN.



2260 Salscheider Court Green Bay, WI 54313
PH:920-569-5765; Fax: 920-569-5767
www.mach-iv.com
Project Number: 2109-01-23

Proposed Building Addition For:

DESTINY CHURCH

DEPERE, WISCONSIN


DATE: 11/02/23
ARCH: K. SPERL
D. BY: RPH
JOB: 22-025
REV. Δ CITY COMMENTS 2024-01-23

C
0.1




SHEET KEY NOTES:

- ① SAW CUT AND REMOVE ASPHALT
- ② SAW CUT AND REMOVE CONCRETE
- ③ REMOVE PAINT STRIPE
- ④ REMOVE DOWNSPOUT WITH CONNECTION PIPE
- ⑤ REMOVE LANDSCAPE MATERIAL AND VEGETATION WITHIN LIMITS SHOWN
- ⑥ FIELD LOCATE AND REMOVE DOWNSPOUT CONNECTION LINE TO 6" STORM

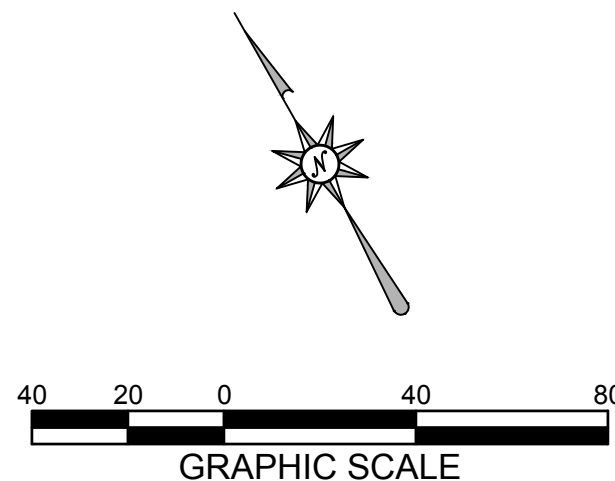

MACH IV
ENGINEERING • SURVEYING • ENVIRONMENTAL

2260 Salscheider Court Green Bay, WI 54313
PH:920-569-5765; Fax: 920-569-5767
www.mach-iv.com
Project Number: 2109-01-23

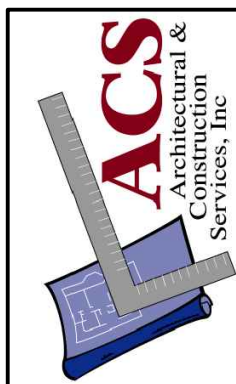

327 RANDOLPH DRIVE - SUITE C
APPLETON, WI 54913
TELE: 920-574-2657 FAX: 920-574-2660

Proposed Building Addition For:

DESTINY CHURCH

DEPERE, WISCONSIN

DATE: 11/02/23
ARCH: K. SPERL
D. BY: RPH
JOB: 22-025
REV.


C
1.0

R:\Jobs\2109-01-23 DESTINY CHURCH\DRAWINGS\2109-01-23 Eng.dwg 9/24/2024 2:27:52 PM

S.T.H. "57" & "32"

GREENLEAF ROAD

SEE INSET A - DUMPSTER ENCLOSURE; THIS SHEET

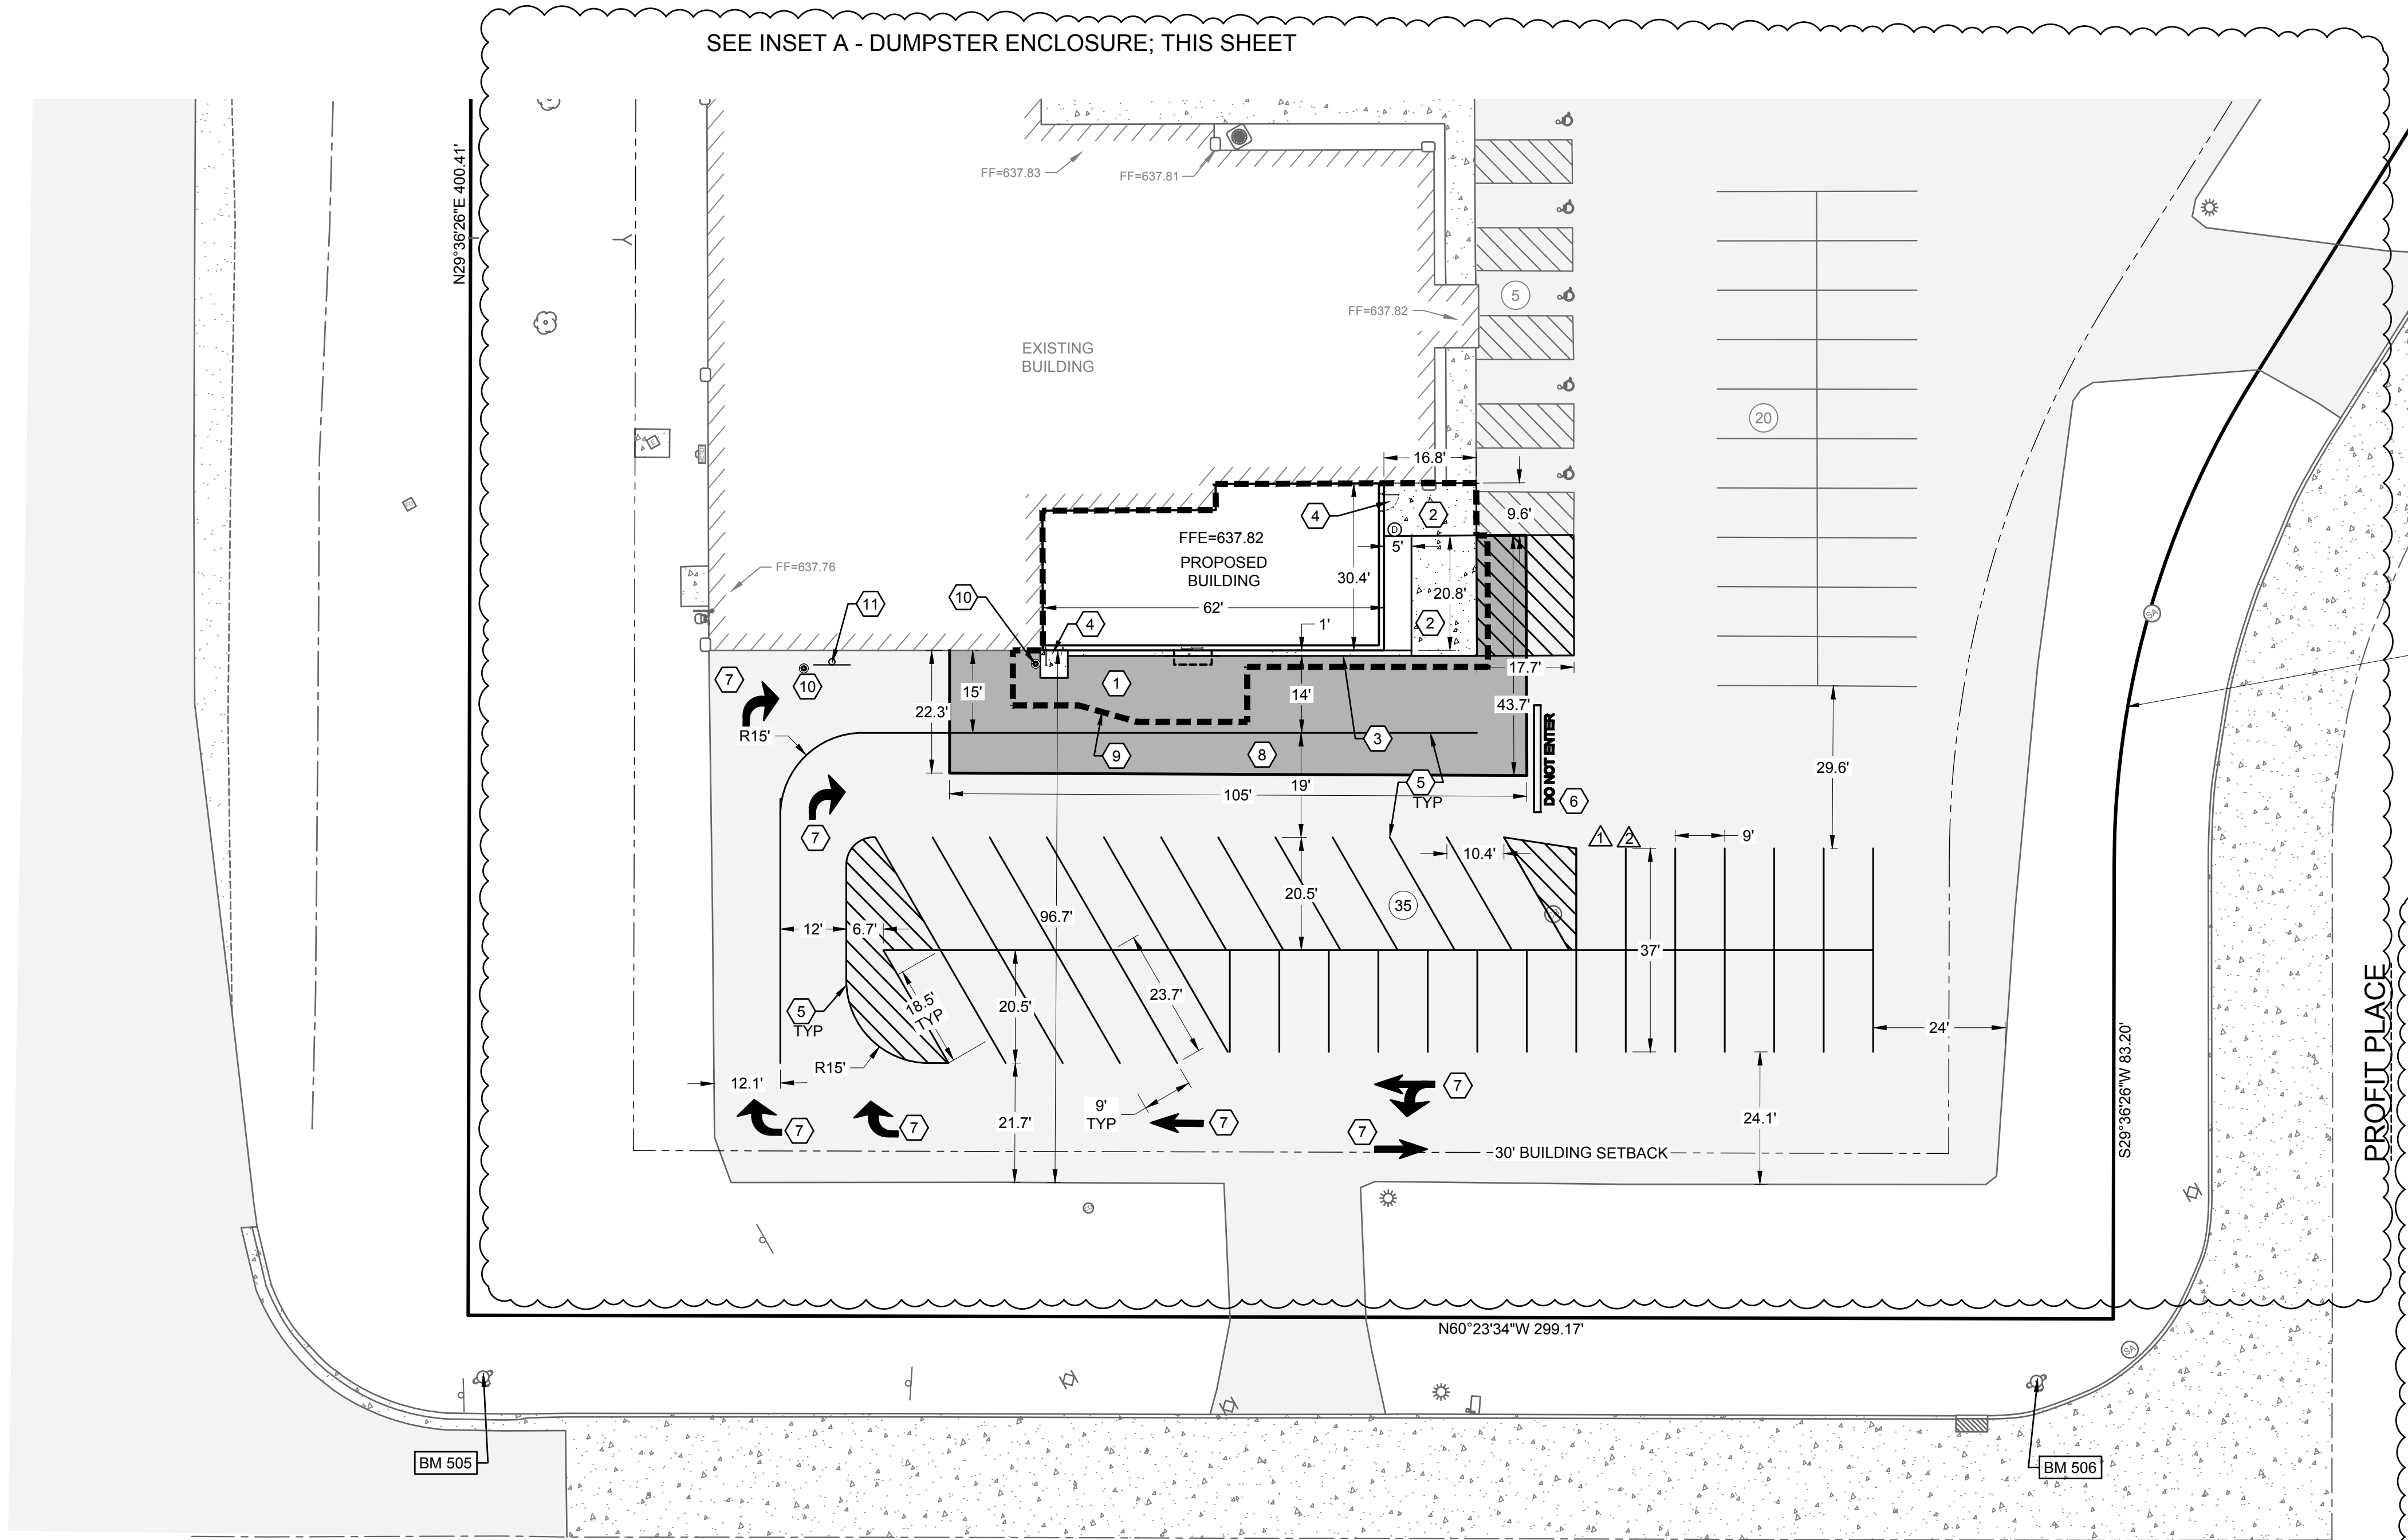


OWNER

DESTINY CHURCH INC.
411 DESTINY DRIVE
DE PERE, WI 54115

SHEET KEY NOTES:

- STANDARD DUTY ASPHALT WITHIN THE GRADING LIMITS; MATCH EXISTING
- CONCRETE SIDEWALK; SEE DETAIL C SHEET C5.0
- MONOLITHIC CURB; SEE DETAIL D SHEET C5.0
- STOOP LOCATION; REFER TO ARCHITECTURAL DRAWINGS
- 4" WIDE PAINT STRIPE; MATCH EXISTING
- PAINTED "DO NOT ENTER"
- TRAFFIC DIRECTIONAL ARROW
- WEDGE PROPOSED ASPHALT ON TOP OF EXISTING ASPHALT, OUTSIDE OF GRADING LIMITS
- GRADING LIMITS
- BOLLARD; SEE DETAIL E SHEET C5.0
- MENU BOARD; REFER TO SIGNAGE PLANS
- DUMPSTER ENCLOSURE GATES TO BE REPLACED; REFER TO ARCHITECTURAL DRAWINGS

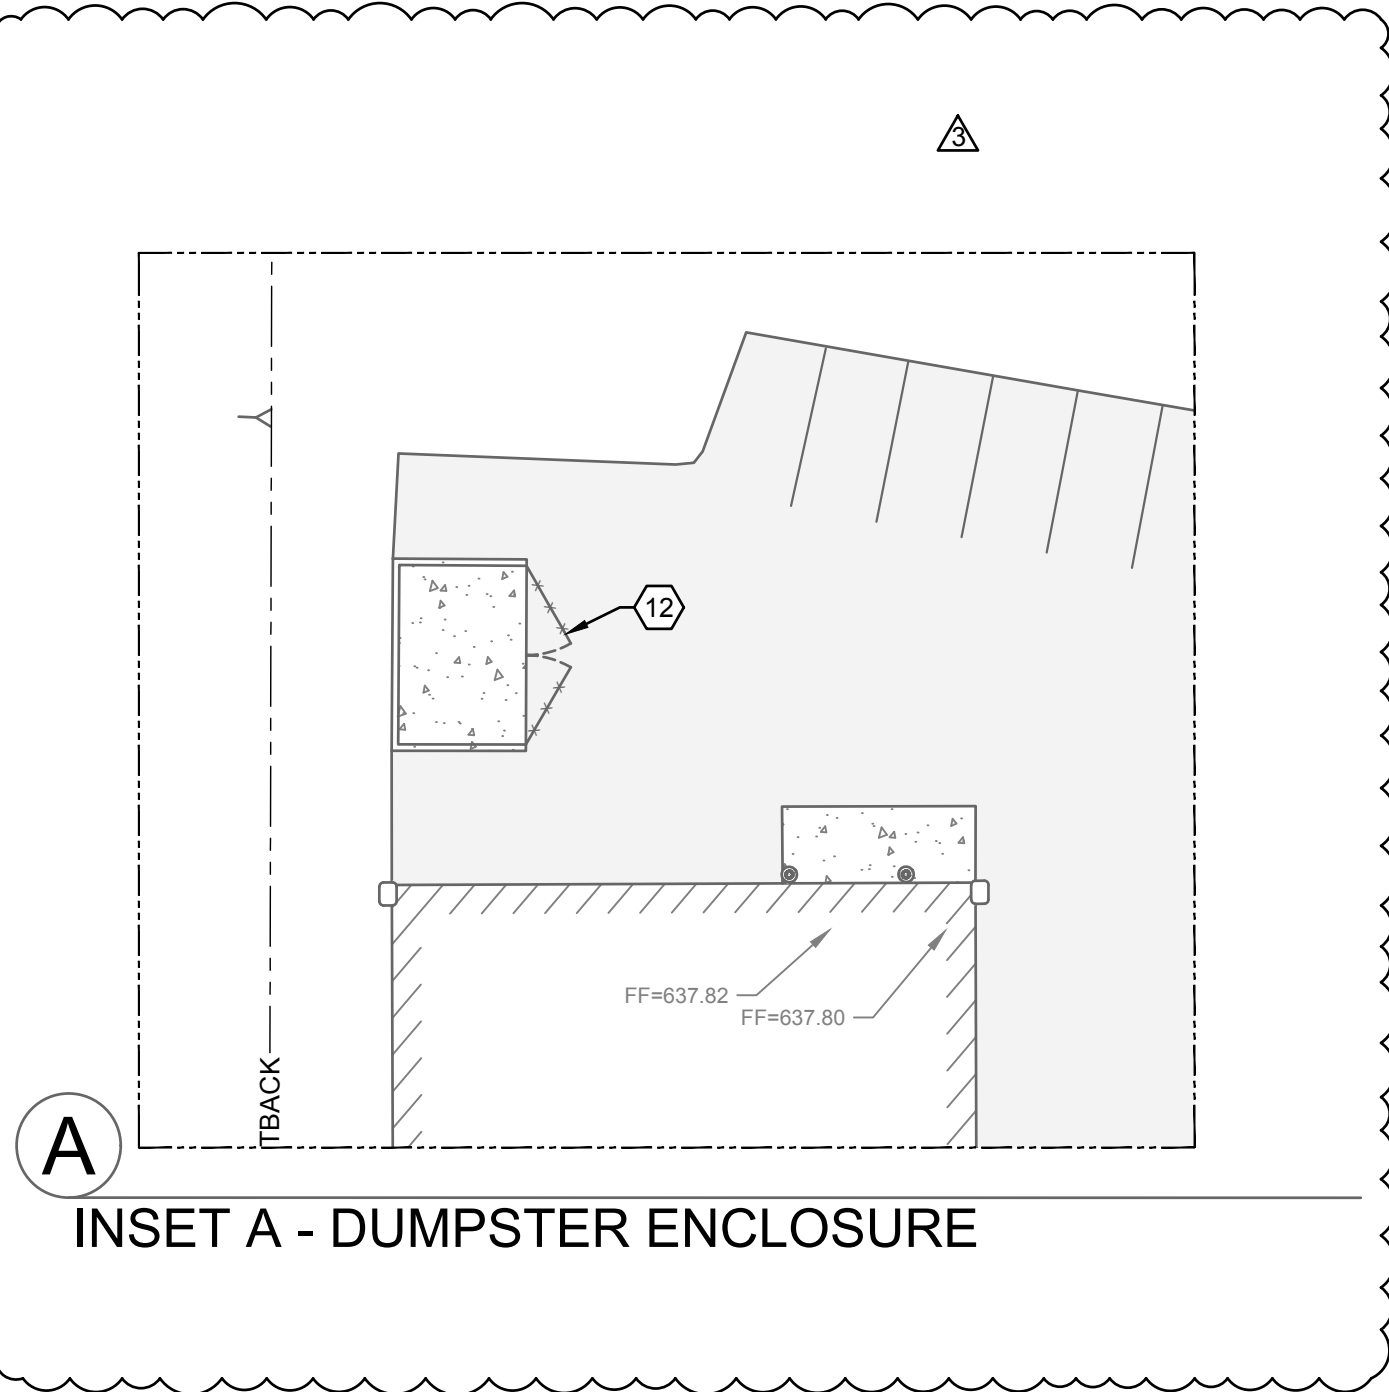

CONSTRUCTION CLASSIFICATION

TYPE VB - COMPLETELY SPRINKLERED PER NFPA 13

OCCUPANCY

"A-3" - ASSEMBLY (EXISTING BUILDING)
"B" - BUSINESS (PROPOSED ADDITION)

ALLOWABLE AREA

USE	PER CHAT 5.	PER CHAT 9.
"A-3" ASSEMBLY	18,000 S.F. / FLOOR	24,000 S.F. / FLOOR
"B" - BUSINESS	9,000 S.F. / FLOOR	36,000 S.F. / FLOOR

EXISTING "A-3" ASSEMBLY	13,829 S.F.
PROPOSED "B" - BUSINESS	1,726 S.F.
	15,555 S.F.

SITE STATISTICS

PARCEL ADDRESS: 411 DESTINY DRIVE
PARCEL NUMBER: ED-F0081-1
PARCEL SIZE: 194,608 SF (4.48 AC)
ZONING: C; COMMERCIAL DISTRICT

EXISTING SITE
GREEN SPACE: 115,481 SF (59.34%)
IMPERVIOUS AREA
BUILDING: 13,888 SF (7.14%)
PAVEMENT: 65,239 SF (33.52%)
TOTAL IMPERVIOUS: 79,127 SF (40.66%)

PROPOSED SITE
TOTAL DISTURBED AREA: 20% (38,922 SF)
GREEN SPACE REQUIRED: 115,386 SF (59.24%)
GREEN SPACE PROVIDED:
IMPERVIOUS AREA
BUILDING: 15,617 SF (8.02%)
PAVEMENT: 63,605 SF (32.74%)
TOTAL IMPERVIOUS: 79,222 SF (40.76%)

PARKING PROVIDED
PARKING SPACES REQ'D/CALCS: 1 STALL PER 200 SF
15,617 SF / 200 SF = 78 STALLS
PARKING SPACES PROVIDED: 121 STALLS; INCLUDES 5 ADA HANDIAP STALLS

SITE PLAN


Proposed Building Addition For:

DESTINY CHURCH

DEPERE, WISCONSIN

DATE: 11/02/23
ARCH: K. SPERL
D. BY: RPH
JOB: 22-025
REV. CITY COMMENTS 2024-01-23
CITY COMMENTS 2024-05-09
CITY COMMENTS 2024-09-19



C
2.0

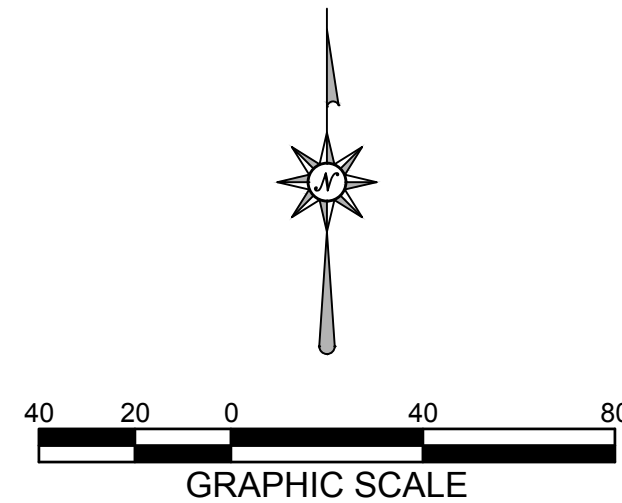

MACH IV
ENGINEERING • SURVEYING • ENVIRONMENTAL

2260 Salscheider Court Green Bay, WI 54313
PH: 920-569-5765; Fax: 920-569-5767
www.mach-iv.com
Project Number: 2109-01-23

R:\Jobs\2109-01-23 DESTINY CHURCH\DRAWINGS\2109-01-23 Eng.dwg 9/24/2024 2:27:54 PM

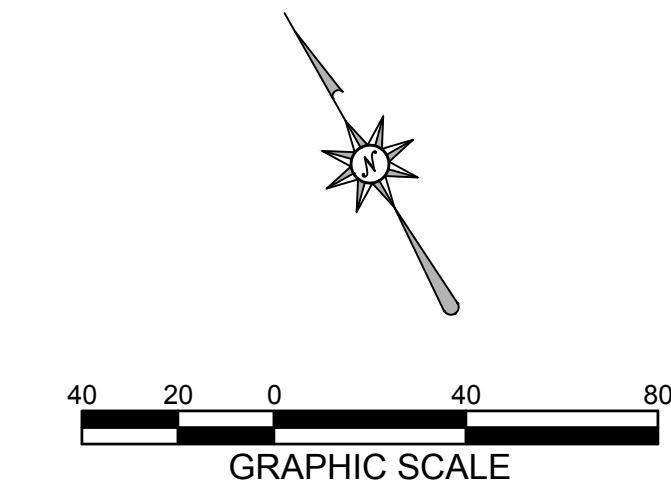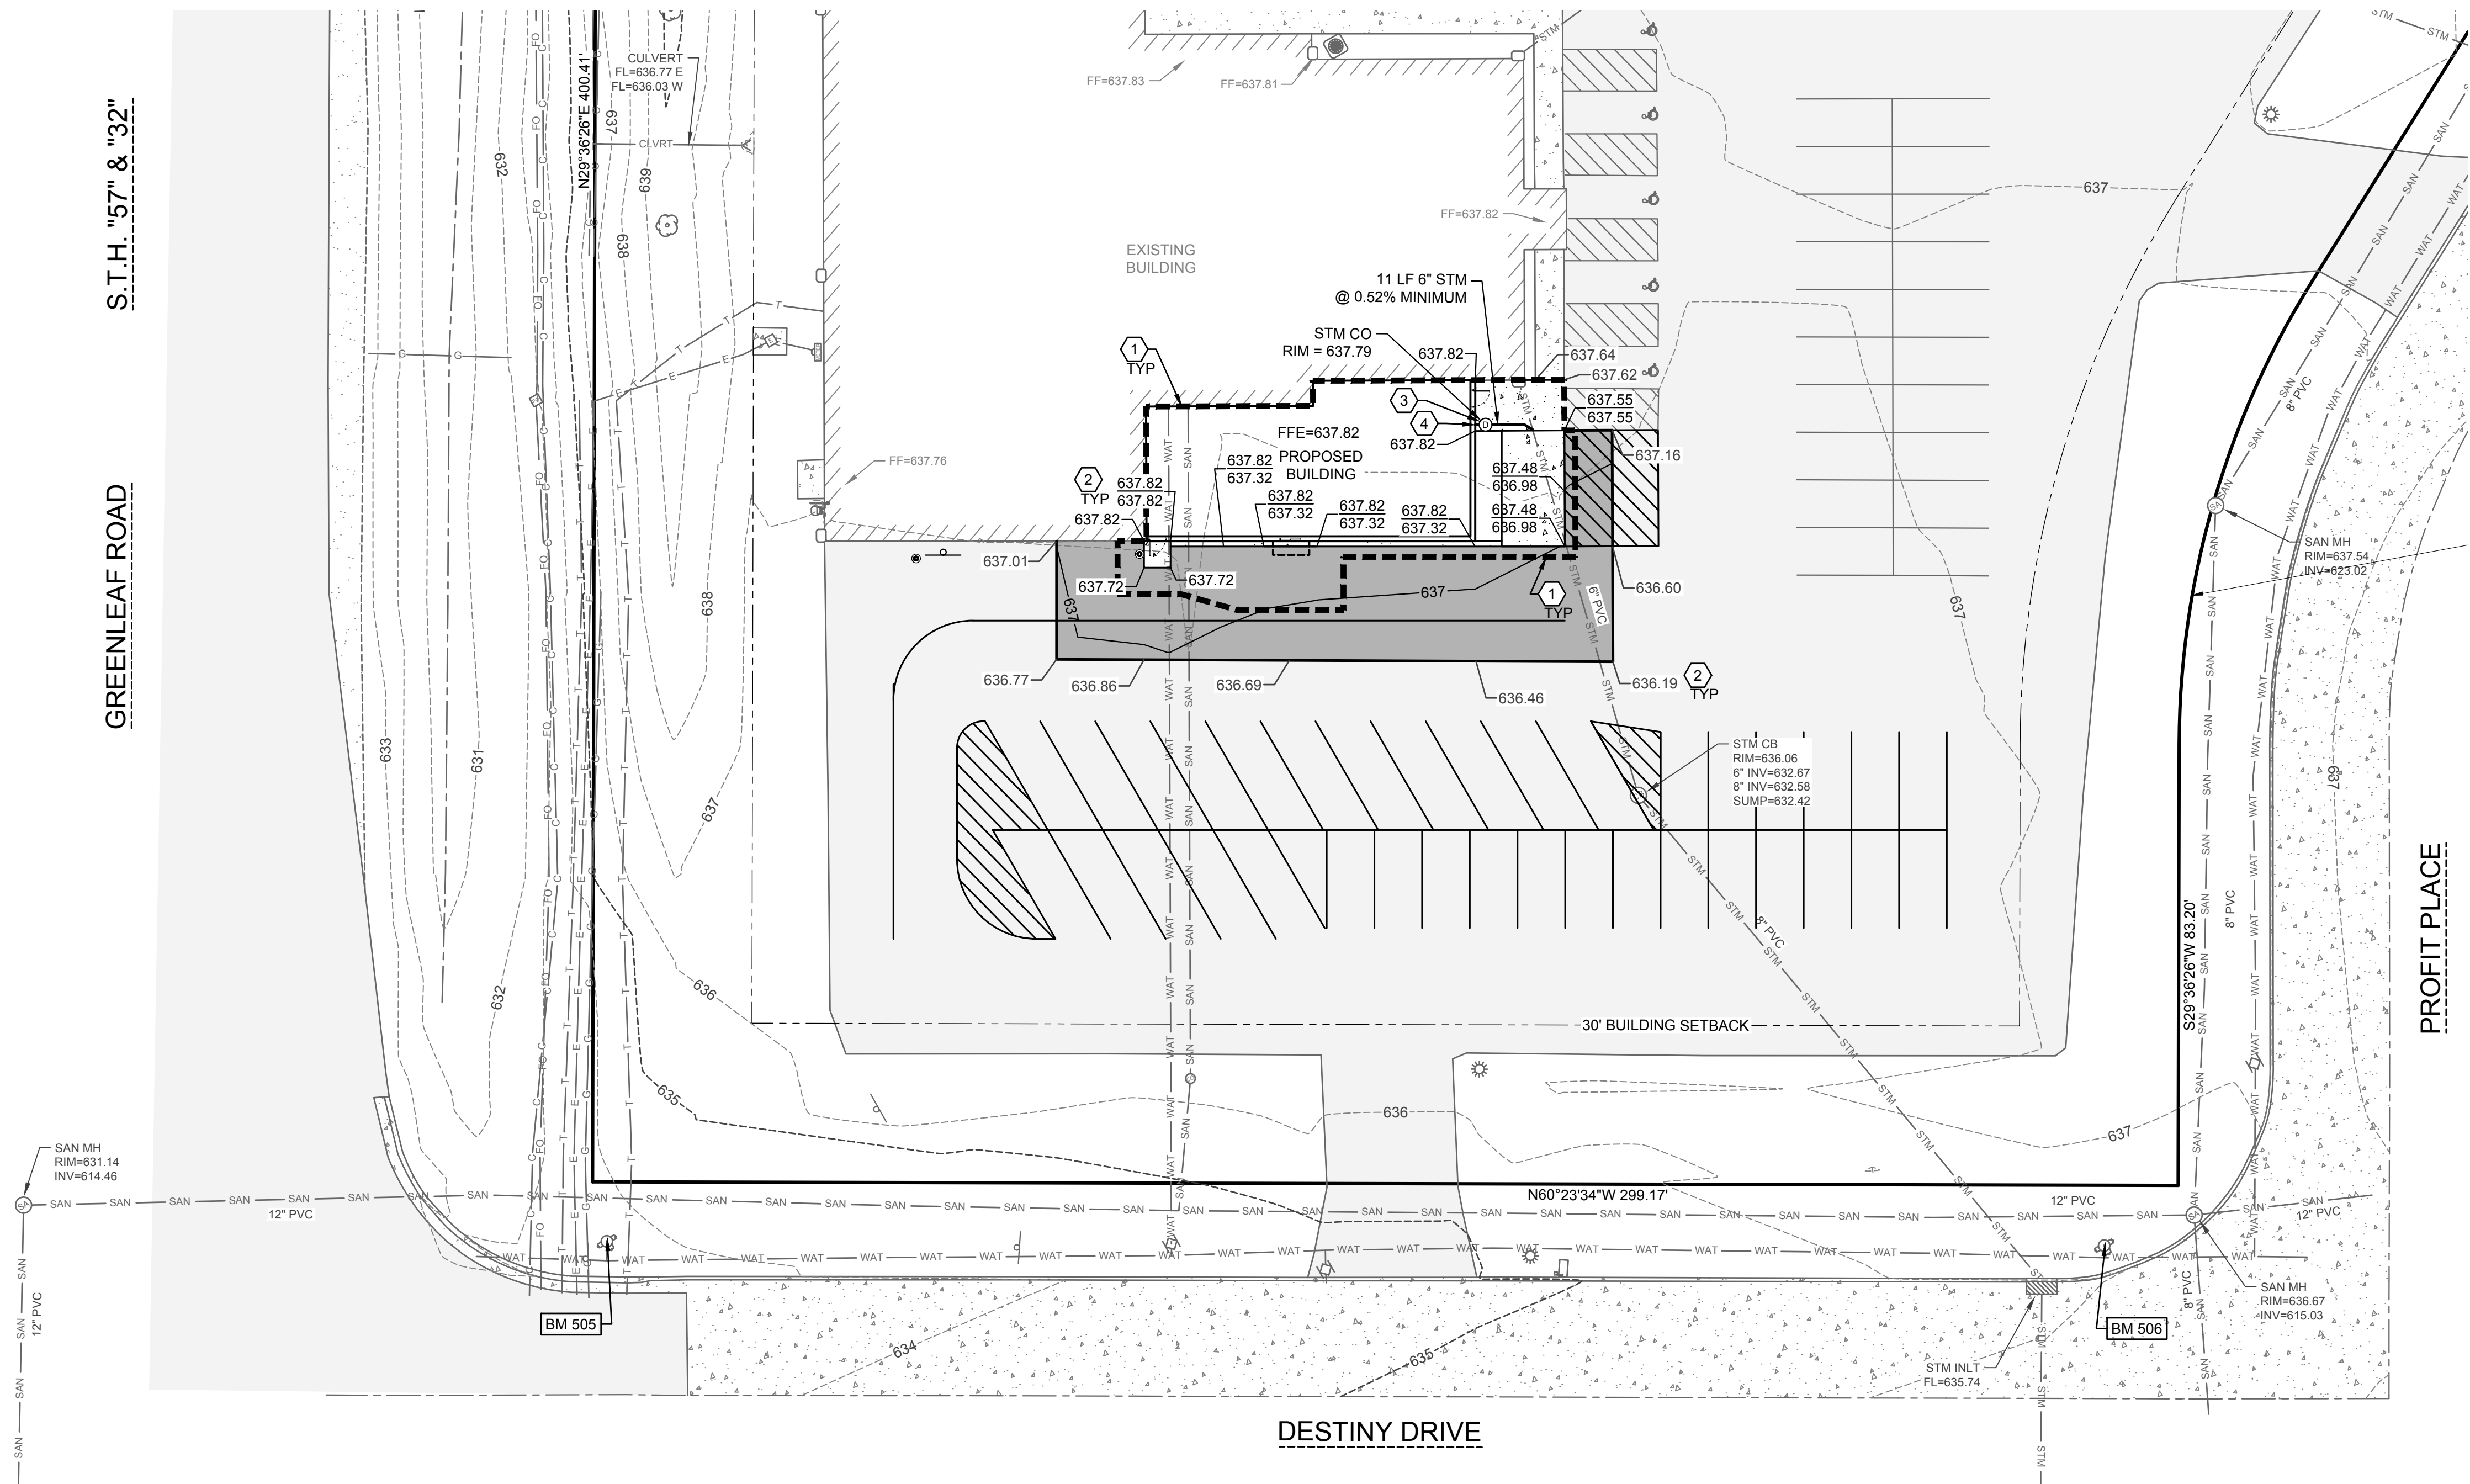

MACH IV
ENGINEERING • SURVEYING • ENVIRONMENTAL

2260 Salscheider Court Green Bay, WI 54313
PH: 920-569-5765; Fax: 920-569-5767
www.mach-iv.com
Project Number: 2109-01-23


Proposed Building Addition For:

DESTINY CHURCH

DEPERE, WISCONSIN

DATE: 11/02/23
ARCH: K. SPERL
D. BY: RPH
JOB: 22-025
REV.

C
3.0

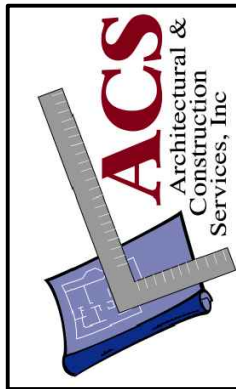

327 RANDOLPH DRIVE - SUITE C
APPLETON, WI 54913
TELE: 920-574-2657 FAX: 920-574-2660

EROSION CONTROL PLAN

SHEET KEY NOTES:

- 1 INLET PROTECTION; SEE DETAIL A SHEET C5.0
- 2 STONE TRACKING PAD, REQUIRED IF EXCAVATION TO TAKE PLACE FROM UNPAVED AREA; IF NEEDED SEE DETAIL B SHEET C5.0

CONSTRUCTION SEQUENCE:

SPRING 2024 TO SUMMER 2024

- INSTALL EROSION CONTROL DEVICES IN ACCORDANCE WITH THE WDNR TECHNICAL STANDARDS AND STORMWATER MANAGEMENT PLAN.
- STRIP TOPSOIL WITHIN GRADING LIMITS
- ROUGH GRADE SITE
- CONSTRUCT BUILDING
- INSTALL SITE UTILITIES
- INSTALL BASE COURSE
- TOPSOIL, SEED, FERTILIZE AND MULCH/EROSION MAT
- INSTALL PAVEMENT
- RE-SEED ANY UNVEGETATED AREAS
- REMOVE EROSION CONTROL BMPS UPON SITE STABILIZATION


Proposed Building Addition For:

DESTINY CHURCH


DEPERE, WISCONSIN

DATE: 11/02/23
ARCH: K. SPERL
D. BY: RPH
JOB: 22-025
REV.

C
4.0

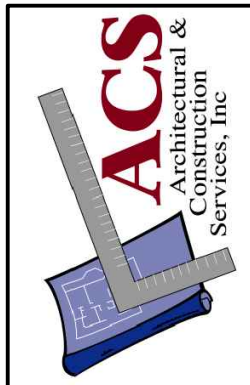


327 RANDOLPH DRIVE - SUITE C
APPLETON, WI 54913
TELE: 920-574-2657 FAX: 920-574-2660

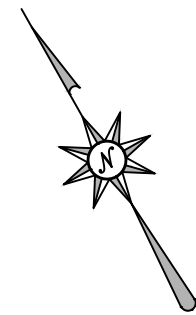

MACH IV
ENGINEERING • SURVEYING • ENVIRONMENTAL

2260 Salscheider Court Green Bay, WI 54313
PH:920-569-5765; Fax: 920-569-5767
www.mach-iv.com
Project Number: 2109-01-23

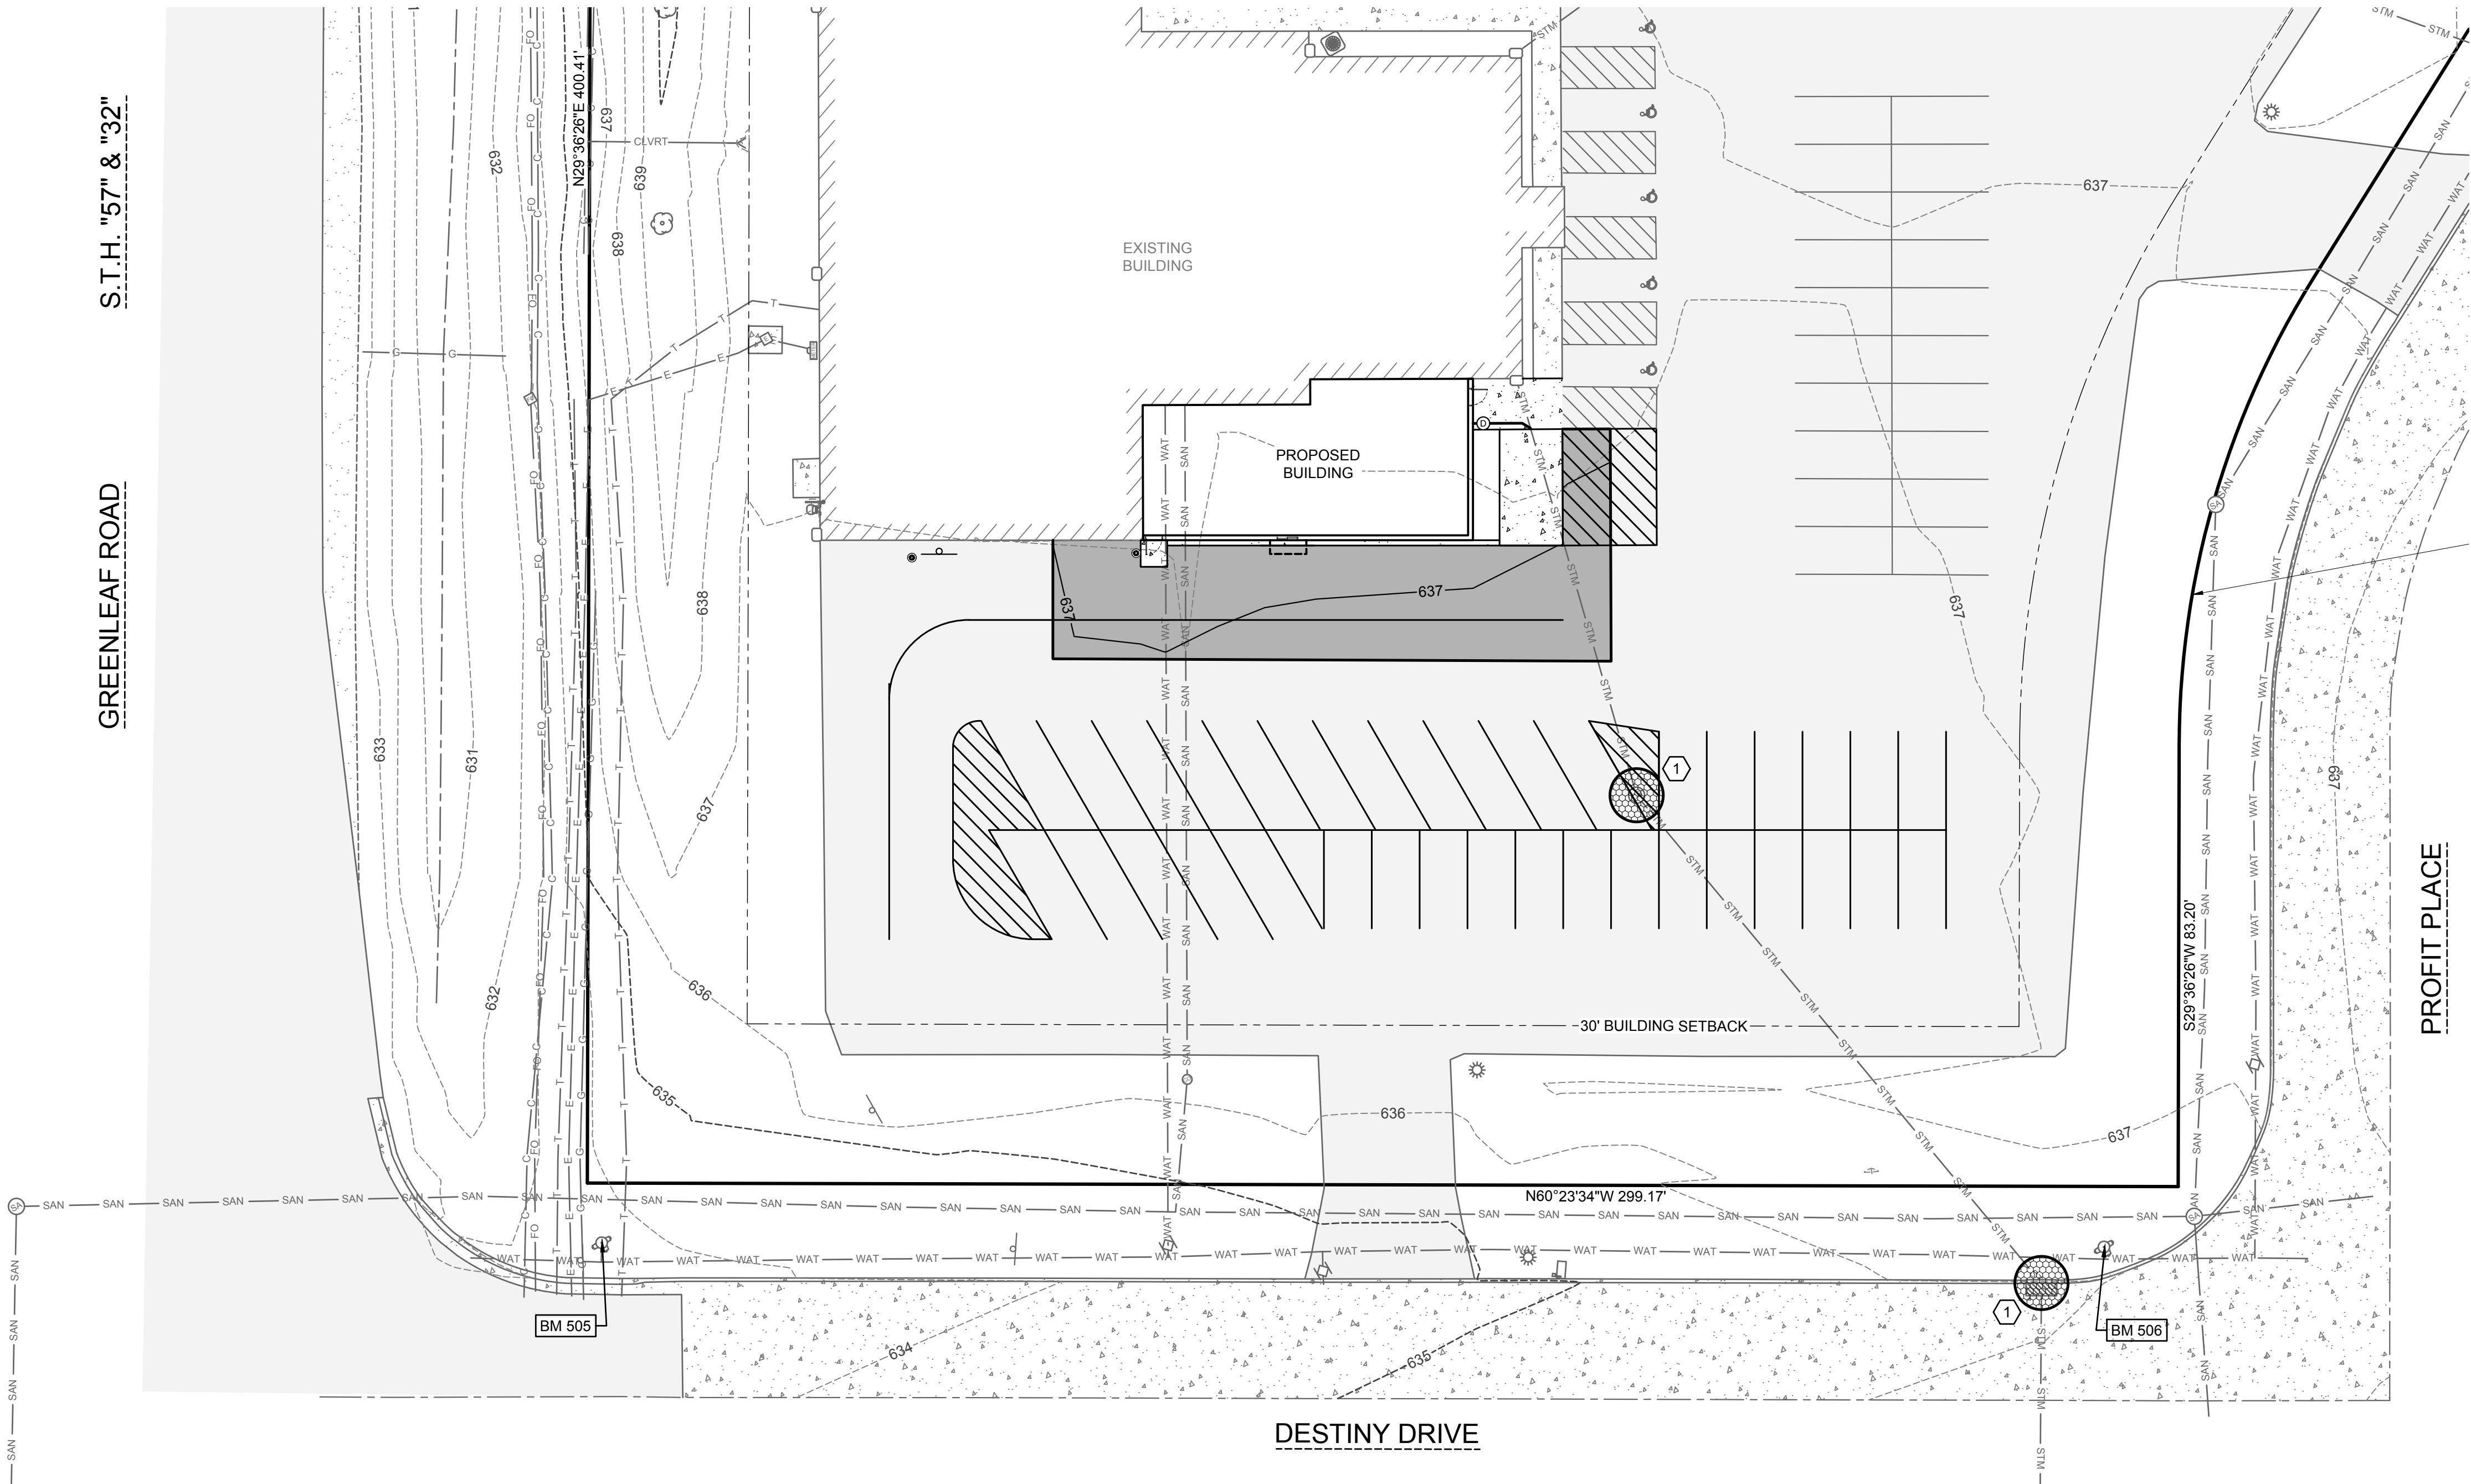

PLANNED EROSION CONTROL PRACTICES:

1. **SILT FENCE** (TECH. STANDARD 1056)
SILT FENCING WILL BE REQUIRED DOWNSLOPE OF ALL DISTURBED AREAS, INCLUDING ANY DISTURBED AREAS OF THE INDIVIDUAL LOTS, AND WHERE NOTED ON THE SITE PLAN. IF THE SILT FENCE IS LOCATED IN A CHANNELIZED AREA, TWO CONSECUTIVE SILT FENCES WILL BE INSTALLED, OR ONE STRAW BALE FENCE WILL BE INSTALLED.
2. **INLET PROTECTION** (TECH STANDARD 1060)
INLET PROTECTION SHALL BE INSTALLED AT ALL EXISTING AND PROPOSED STORM DRAIN INLETS ON THE PROJECT SITE AND IMMEDIATELY DOWN STREAM FROM ANY DISTURBED AREAS.
3. **DUST CONTROL** (TECH STANDARD 1068)
DUST CONTROL SHALL BE IMPLEMENTED IN ACCORDANCE WITH THE ABOVE MENTIONED TECHNICAL STANDARD. WHERE POSSIBLE DUST CONTROL SHALL BE WISDOT TYPE B SOIL STABILIZER OR TEMPORARY SEED.
4. **STOCKPILED TOPSOIL/TEMPORARY FILL PILES**
SILT FENCING OR STRAW BALE FENCING WILL BE REQUIRED AROUND ALL STOCKPILED TOPSOIL OR TEMPORARY FILL PILES. SOIL PILES OF MORE THAN 10 CUBIC YARDS THAT WILL BE IN EXISTENCE FOR MORE THAN 7 DAYS SHALL BE SEEDED AND/OR MULCHED TO PROVIDE VEGETATIVE COVER AND SHALL USE SILT FENCING OR STRAW BALES FENCING UNTIL THE VEGETATION IS ESTABLISHED.
5. **TEMPORARY CONSTRUCTION ENTRANCE/EXIT** (TECH. STANDARD 1057)
A NEW GRAVEL CONSTRUCTION ENTRANCE WILL BE INSTALLED AT ALL CONSTRUCTION ACCESS POINTS TO PREVENT SEDIMENT FROM TRACKING ONTO THE ROADWAYS.
6. **EROSION CONTROL MATS** (TECH. STANDARD 1053)
EROSION CONTROL MATS WILL BE INSTALLED IN AREAS AS SHOWN ON THE SITE PLAN, AND IN ALL OTHER AREAS WHERE EXCESSIVE EROSION IS TAKING PLACE. INSTALLATION WILL FOLLOW MANUFACTURER'S RECOMMENDATIONS FOR PLACEMENT AND STAPLING.
7. **DEWATERING** (TECH STANDARD 1061)
SHOULD DEWATERING BE REQUIRED FOR INSTALLATION OF PLANNED IMPROVEMENTS, SEDIMENT SHALL BE REMOVED FROM WATER GENERATED DURING DEWATERING ACTIVITIES PRIOR TO DISCHARGING OFF-SITE OR TO WATERS OF THE STATE.


MAINTENANCE PLAN:

1. ALL EROSION CONTROL AND STORM WATER MANAGEMENT PRACTICES WILL BE CHECKED FOR STABILITY AND OPERATION EVERY 7 DAYS AND WITHIN 24 HOURS OF A STORM PRODUCING AT LEAST 0.5 INCHES OF RAINFALL. ANY NEEDED REPAIRS WILL BE MADE IMMEDIATELY TO MAINTAIN ALL PRACTICES AS DESIGNED. ALSO, ANY SEDIMENT THAT HAS BEEN DEPOSITED OFF-SITE FROM THIS CONSTRUCTION PROJECT SHALL BE CLEANED UP IMMEDIATELY.
2. REMOVE SEDIMENT FROM BEHIND ANY SILT FENCE WHEN IT HAS ACCUMULATED TO A DEPTH OF 1/4 FENCE HEIGHT OR MORE. WHEN THE FENCE CAN NO LONGER FILTER WATER OR TRAP SEDIMENT, REPAIR THE SILT FENCE TO PROVIDE AN EFFECTIVE BARRIER.
3. ALL SEEDED AREAS, INCLUDING THE GRASS LINED CHANNELS, WILL BE RESEEDED AND MULCHED AS NECESSARY TO MAINTAIN A VIGOROUS, DENSE VEGETATIVE COVER.
4. ANY UNPROTECTED DRAINAGE DITCHES EXPERIENCING EXCESSIVE EROSION AND CHANNEL DEGRADATION DUE TO HIGH RUNOFF VOLUMES WILL BE REGRADED AND COVERED WITH A BIODEGRADABLE EROSION CONTROL MAT. INSTALLATION WILL FOLLOW MANUFACTURER'S RECOMMENDATIONS.
5. REMOVE SILT FENCE AND TEMPORARY STRUCTURES AFTER FINAL STABILIZATION AND VEGETATIVE COVER IS ESTABLISHED.
6. SEDIMENT THAT HAS MIGRATED OFF SITE ONTO ADJACENT PROPERTIES SHALL BE SWEEPED OFF PAVEMENTS AND REMOVED FROM VEGETATED AREAS DAILY.
7. COPIES OF THE EROSION & SEDIMENT CONTROL PLAN SHALL BE KEPT ON SITE.
8. MAINTAIN EROSION AND SEDIMENT CONTROL PER THE PLAN AND AS NECESSARY TO MEET THE REQUIREMENTS OF THE ORDINANCE, UNTIL THE SITE HAS UNDERGONE FINAL STABILIZATION AND RECEIVED FINAL ACCEPTANCE FROM THE MUNICIPALITY.
9. AN EROSION AND SEDIMENT CONTROL PRACTICE INSPECTION LOG SHALL BE MAINTAINED. LOG SHALL NOTE THE TIME, DATE AND LOCATION OF INSPECTION, THE PHASE OF CONSTRUCTION AT THE SITE, PERSON DOING THE INSPECTION, ASSESSMENT OF CONTROL PRACTICES, AND DESCRIPTION OF EROSION AND SEDIMENT CONTROL MEASURES OR MAINTENANCE DONE IN RESPONSE TO INSPECTION.

CONSTRUCTION NOTES:


1. TOPSOIL TO BE REMOVED FROM THE PROJECT SITE PRIOR TO PLACEMENT OF FILL OR SUBGRADE MATERIAL. EXCESS TOPSOIL TO BE STOCKPILED ON THE SITE AS INDICATED.
2. ALL EXCAVATED AREAS NOT RECEIVING PAVEMENT TO BE COVERED WITH A MINIMUM OF 6" OF TOPSOIL, SEEDED AND MULCHED AS SOON AS FINAL GRADE HAS BEEN ACHIEVED. SEEDING SHALL BE IN ACCORDANCE WITH WDNR TECH. STANDARD (1059).
3. EROSION CONTROL METHODS SHALL BE IMPLEMENTED, AS DIRECTED BY THE ENGINEER, PRIOR TO AND DURING CONSTRUCTION, TO CONTROL WATER POLLUTION, EROSION AND SILTATION, INCLUDING, BUT NOT LIMITED TO HAY BALE DIKES AND SILT FENCES. ALL EROSION CONTROL MEASURES SHALL BE INSTALLED AND MAINTAINED IN ACCORDANCE WITH THE WDNR TECHNICAL STANDARDS.
4. CONTRACTOR IS RESPONSIBLE FOR OBTAINING ALL NECESSARY PERMITS.
5. CONTRACTOR IS RESPONSIBLE FOR CONTACTING DIGGERS HOTLINE FOR THE LOCATION OF THE UTILITIES.
6. SITE DEWATERING IS NOT ANTICIPATED, HOWEVER SHOULD DEWATERING BE NECESSARY, IT SHALL BE PERFORMED IN ACCORDANCE WITH WDNR TECHNICAL STANDARD (1061).
7. THE CONTRACTOR SHALL DISPOSE OF ALL WASTE AND EXCESS MATERIAL AT AN APPROVED LOCATION.

EROSION CONTROL & SITE DETAILS




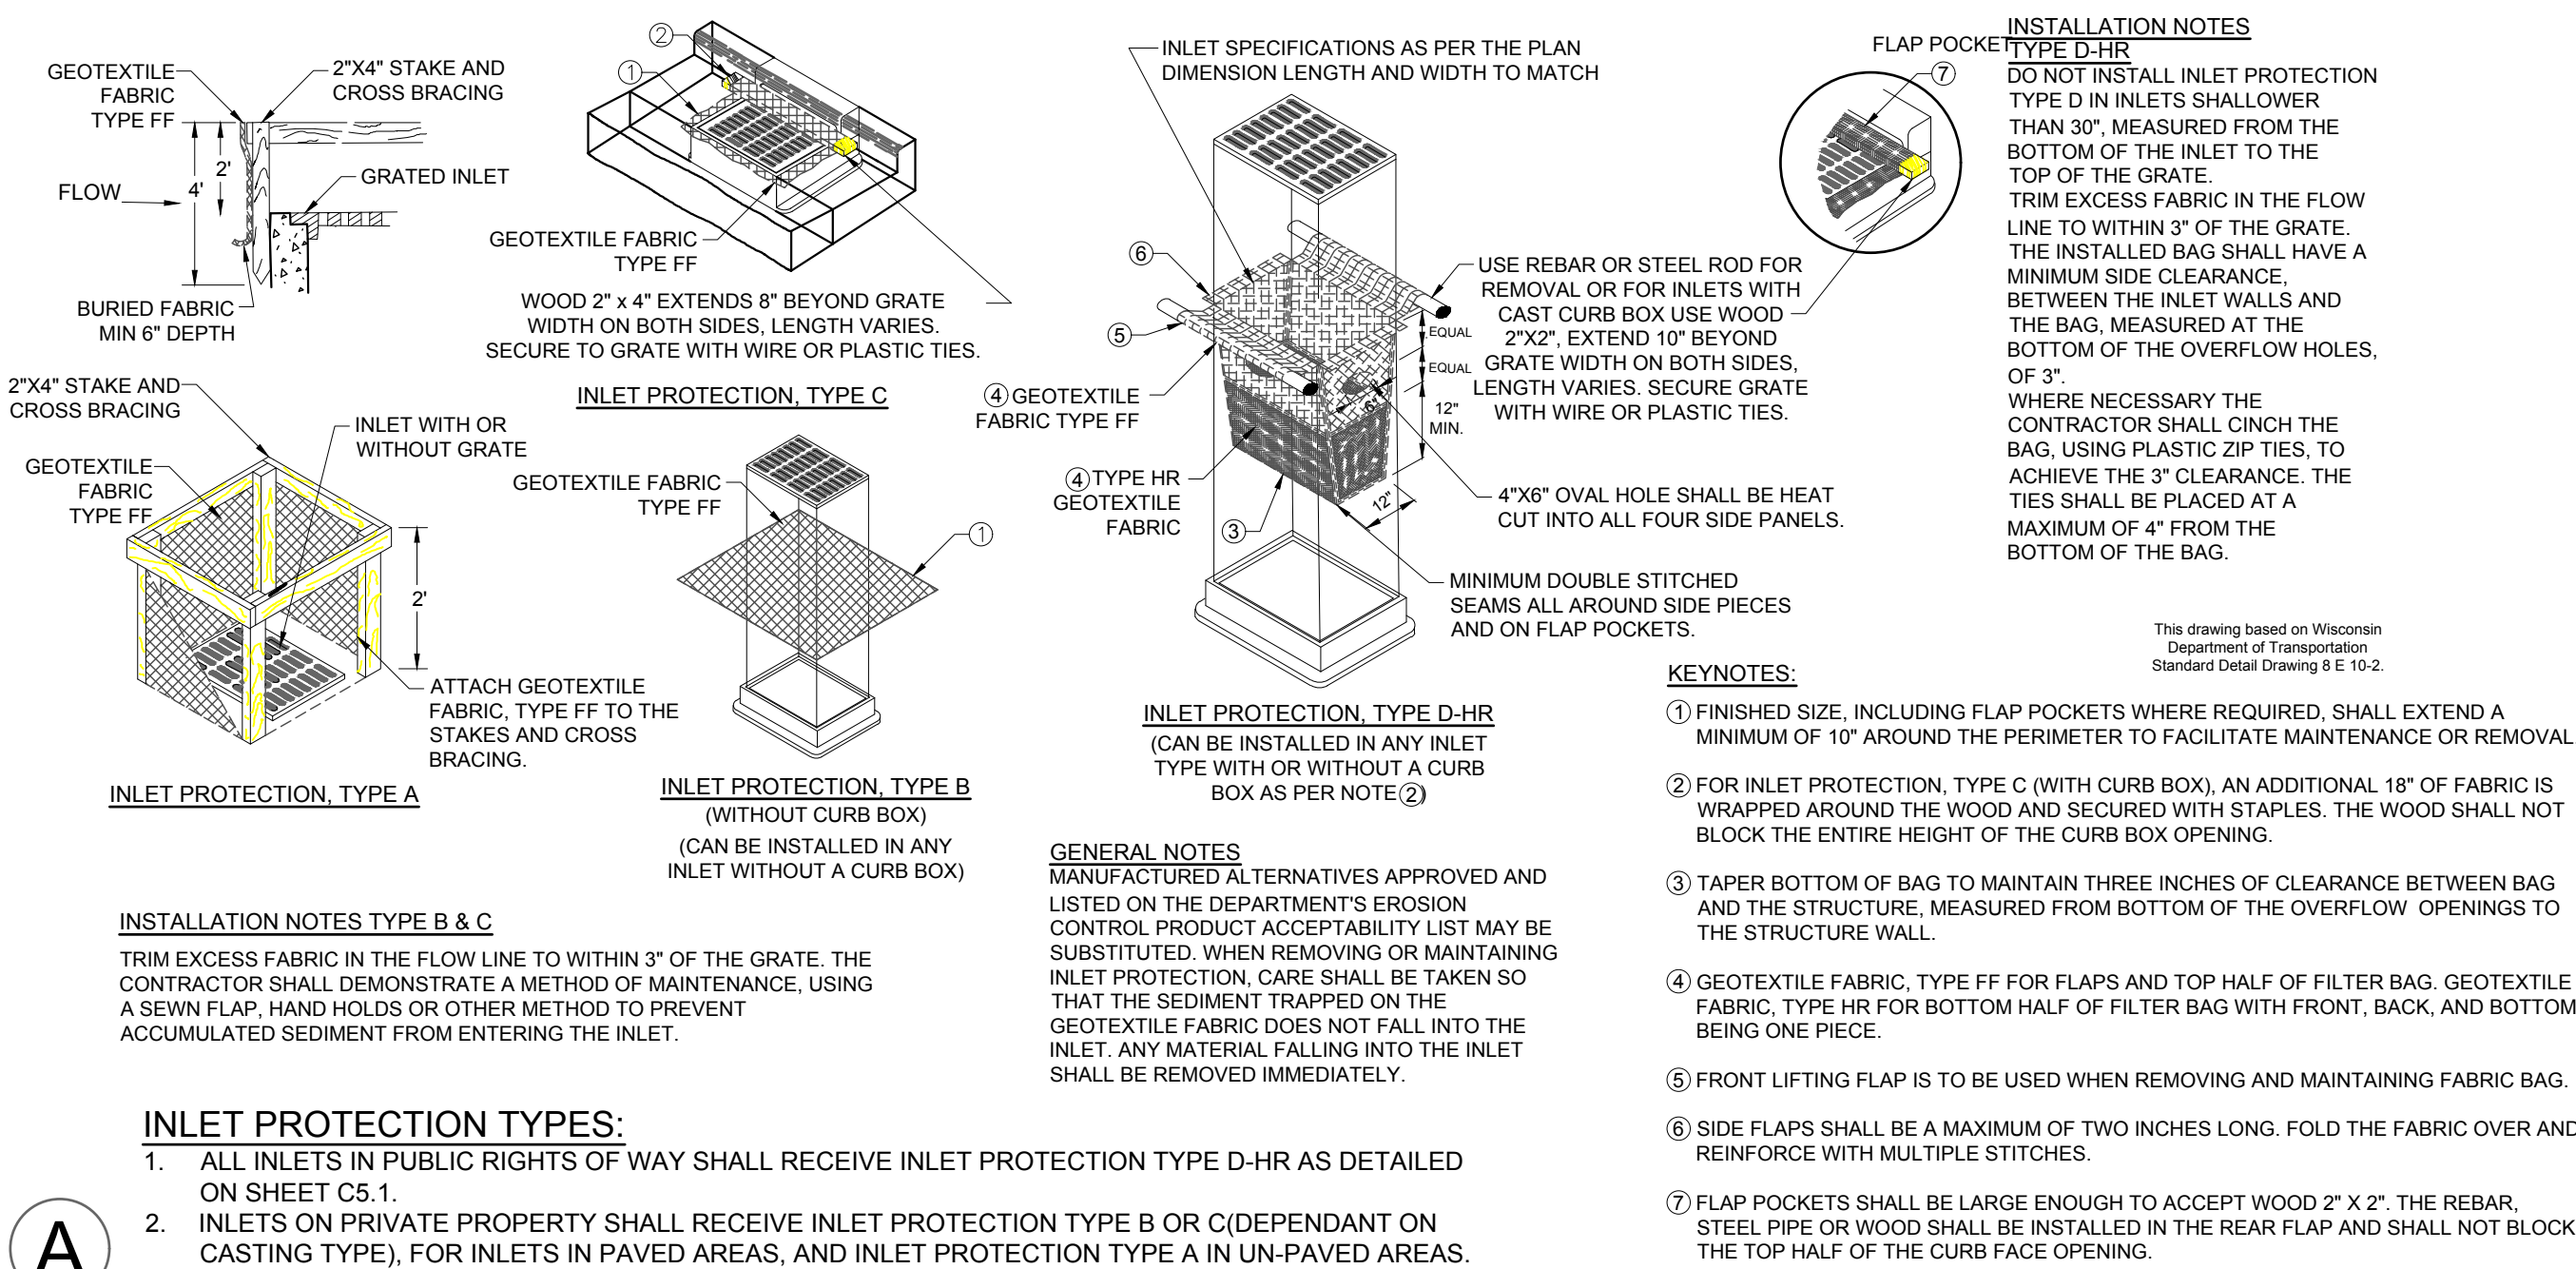


INLET PROTECTION

TABLE 1: GRADATION FOR STONE TRACKING PADS	
SIEVE SIZE	% PASSING BY WEIGHT
3"	100
2 1/2"	90-100
1 1/2"	25-60
3/4"	0-20
3/8"	0-5

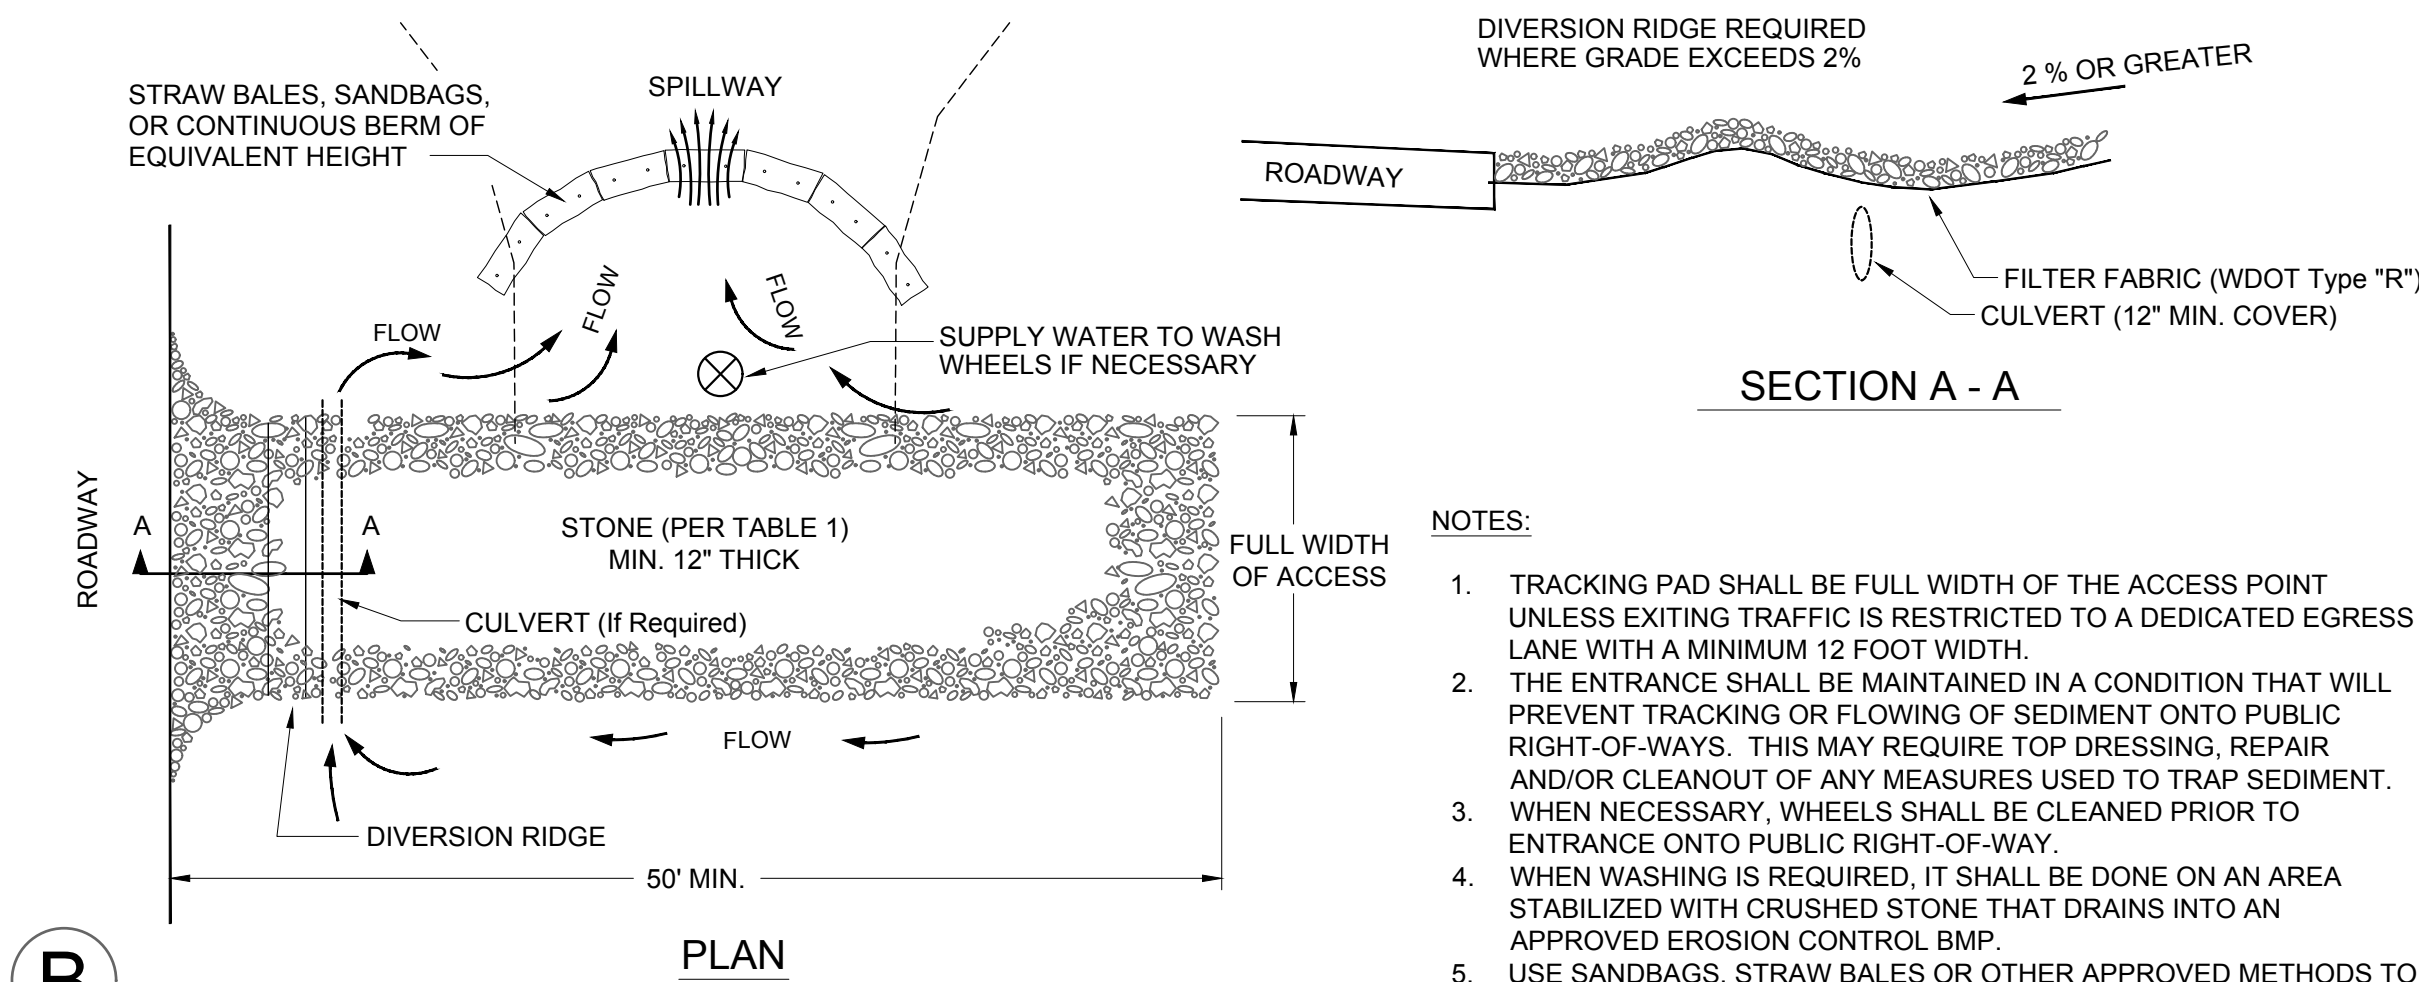

STONE TRACKING PAD

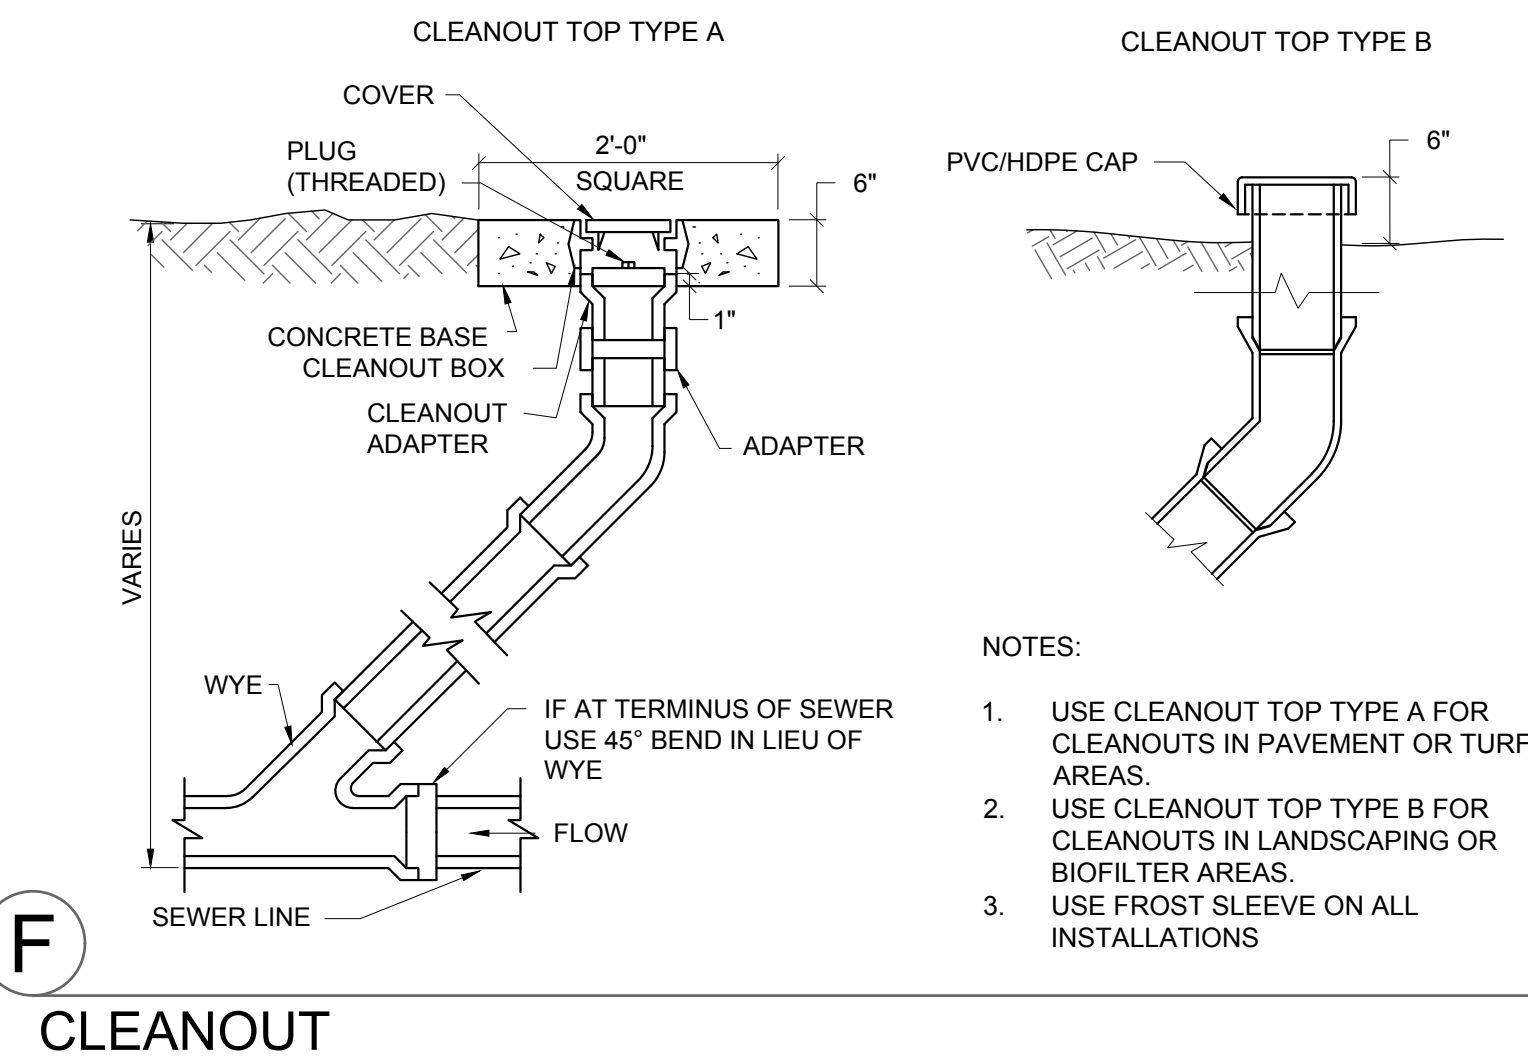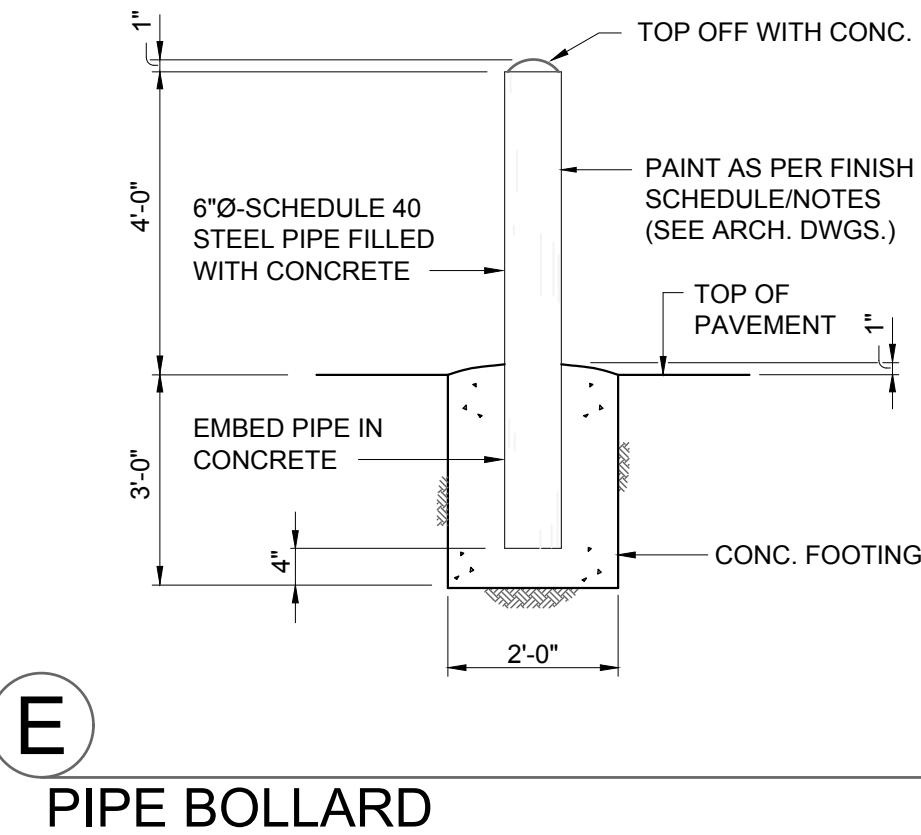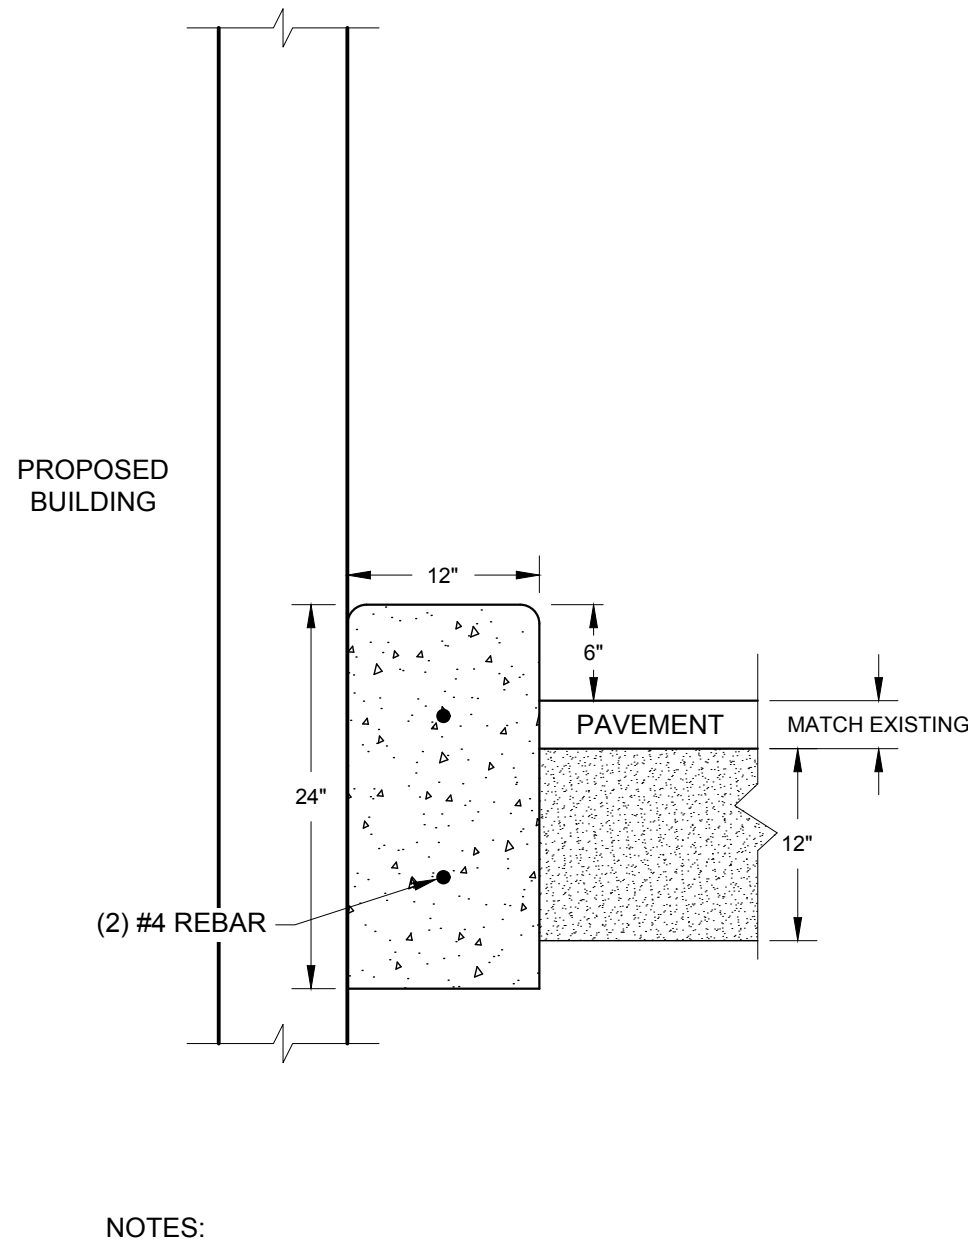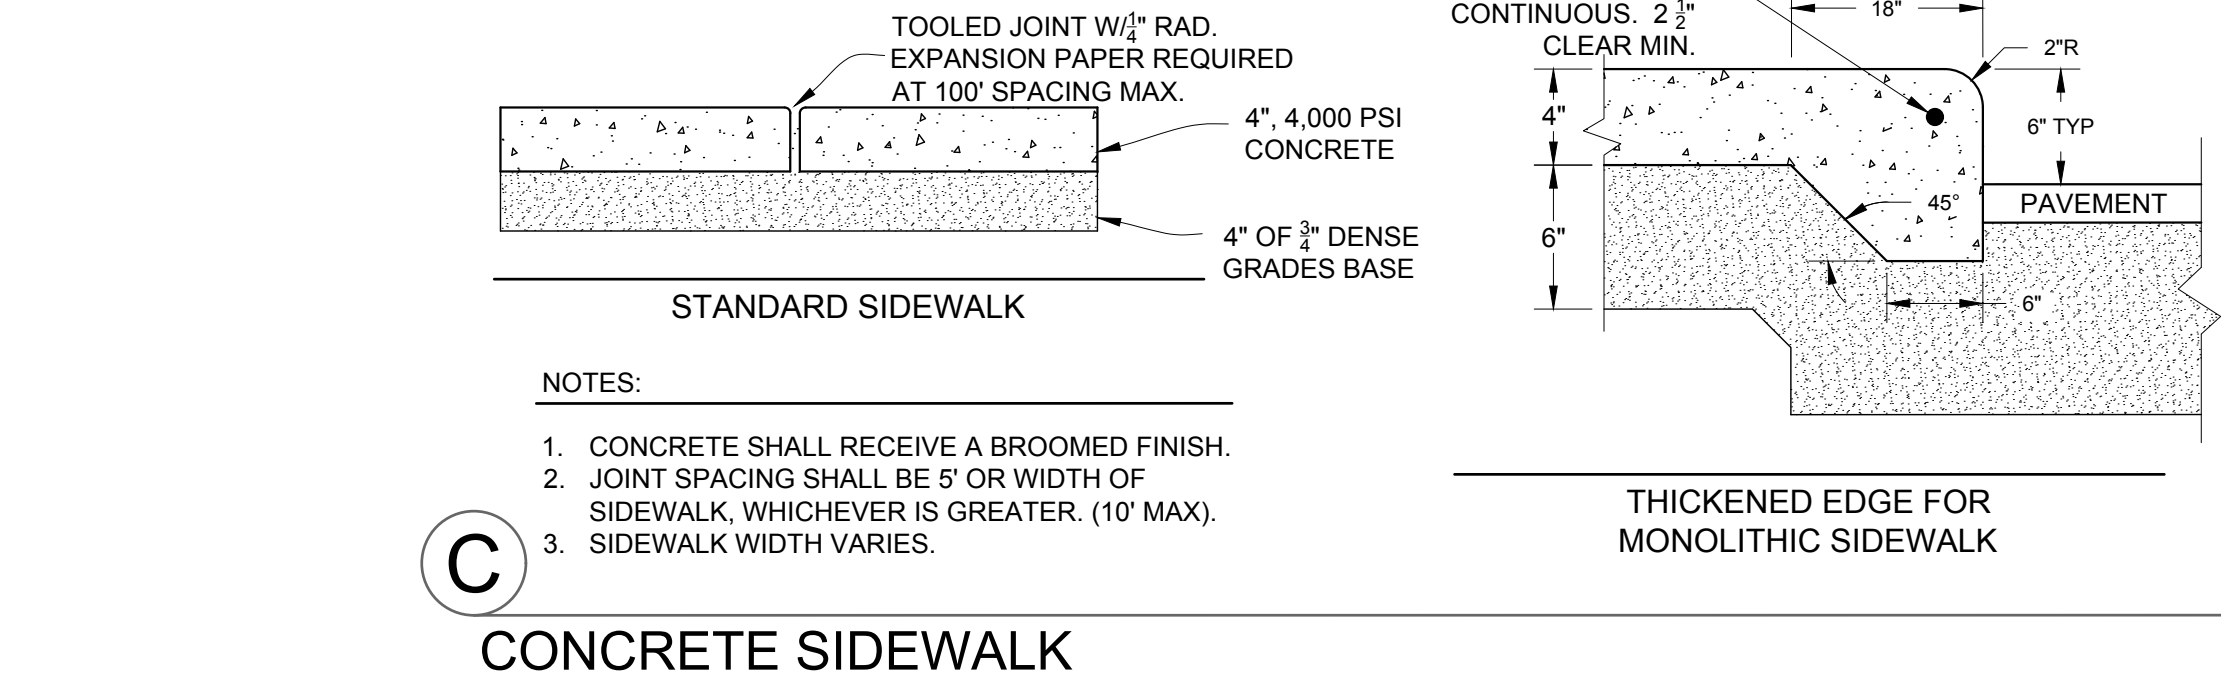

MACH IV

ENGINEERING • SURVEYING • ENVIRONMENTAL

2260 Salscheider Court Green Bay, WI 54313
PH: 920-569-5765; Fax: 920-569-5767
www.mach-iv.com
Project Number: 2109-01-23


Proposed Building Addition For:

DESTINY CHURCH

DEPERE, WISCONSIN

DATE: 11/02/23
ARCH: K. SPERL
D. BY: RPH
JOB: 22-025
REV.

C
5.0

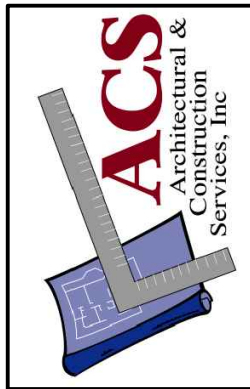


327 RANDOLPH DRIVE - SUITE C
APPLETON, WI 54913
TELE: 920-574-2657 FAX: 920-574-2660

R:\Jobs\2109-01-23 DESTINY CHURCH\DRAWINGS\2109-01-23 Eng.dwg 9/24/2024 2:27:59 PM

LANDSCAPE PLAN

SHEET KEY NOTES:

- HARDWOOD MULCH TO MATCH EXISTING
- PLANTINGS ON BERM REQUIRED TO BRING THE SITE INTO COMPLIANCE FROM PREVIOUS SITE PLAN APPROVAL
- EXISTING DUMPSTER PAD; SEE SHEET C2.0

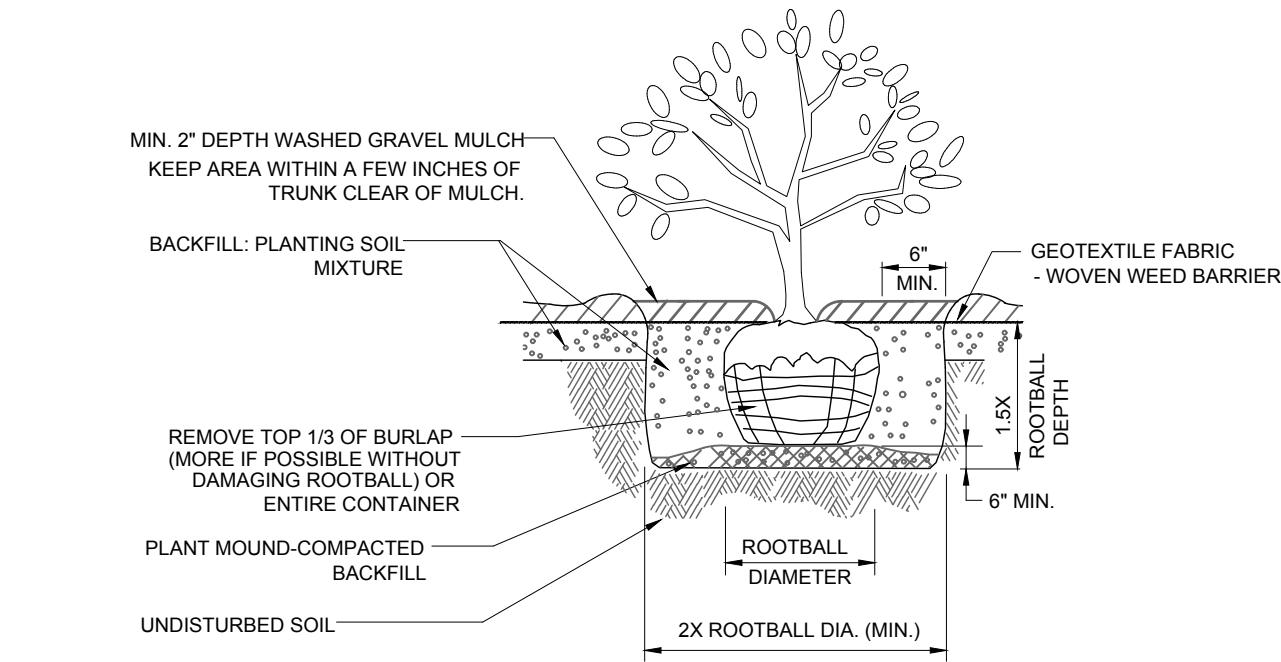


A SHRUB / ORNAMENTAL GRASSES PLANTING DETAIL

LANDSCAPE NOTES

- DIAMETERS OF PLANT MATERIALS AS DRAWN ARE REPRESENTATIVE OF PLANTS AT OR NEAR MATURITY RATHER THAN AT INITIAL PLANTING SIZES.
- THE PLANT LIST IS INTENDED AS A GUIDE FOR THE CONTRACTOR. IN THE EVENT OF DISCREPANCY BETWEEN THE NUMBER OF PLANTS ON THE PLANT LIST AND ON THE DRAWING, THE GREATER NUMBER SHALL APPLY.
- ADJUSTMENTS IN LOCATIONS OF PLANT MATERIALS MAY BE NECESSARY DUE TO NEW OR EXISTING UTILITIES OR SITE OBSTRUCTIONS. REVIEW WITH ARCHITECT BEFORE ADJUSTMENTS ARE MADE.
- ALL SHRUBS OCCURRING IN CONTINUOUS ROW OR FORMAL ARRANGEMENT SHALL HAVE UNIFORM HEIGHT, SPREAD AND HABIT OF GROWTH. FOR GROUND COVER LOCATIONS, FILL AREA WITH QUANTITY OF PLANTS DESIGNATED; EVENLY SPACED.
- A MINIMUM OF 12" DEPTH OF 50% TOPSOIL AND 50% COMPOST SHALL BE PLACED IN ALL BED AREAS BY THE CONTRACTOR PRIOR TO PLANT INSTALLATION.
- MULCH TREES WITH MIN. 3" DEPTH OF GRAVEL OR HARDWOOD MULCH AS NOTED ON PLAN AND PER DETAILS. MULCH SHALL EXTEND IN A CONTINUOUS LAYER WITHIN PLANTING BEDS FROM FACE TO FACE OF SITE STRUCTURES - WALKS, BUILDING, OR OTHER PLANT BED LIMITS.
- PROTECT EXISTING LAWN AREAS; REPAIR ANY CONTRACT RELATED DAMAGE TO LAWN AREAS.
- THE CONTRACTOR SHALL MAINTAIN ALL PLANTS AND BEDS FOR A 90 DAY PERIOD AFTER ACCEPTANCE OF THE WORK BY THE ARCHITECT. THIS INCLUDES REGULAR WATERING, WEEDING AND MOWING.
- THE CONTRACTOR SHALL GUARANTEE ALL PLANT MATERIALS FOR ONE-YEAR FROM DATE OF ACCEPTANCE. BEFORE END OF WARRANTY PERIOD CONTRACTOR SHALL REPLACE ALL TREES, SHRUBS OR PLANTINGS NOT ALIVE OR IN A HEALTHY GROWING CONDITION.
- SEED ALL DISTURBED AREAS WITH Wdot No. 40 GRASS MIX.
- WHEN LANDSCAPING IS COMPLETE, LANDSCAPING CONTRACTOR TO PROVIDE LETTER TO THE CITY STATING LANDSCAPING HAS BEEN INSTALLED ACCORDING TO THE APPROVED LANDSCAPING PLAN.

PLANT TABLE

SYMBOL	COMMON NAME	SCIENTIFIC NAME	QUANTITY	SIZE
	GOLDFLAME SPIRAEA	SPIRAEA X BUMALDA 'GOLDFLAME'	3	3 GAL.
	DAYLILIES	HEMEROCALLIS	6	1 GAL.
	GLOBE ARBORVITAE	THUJA OCCIDENTALIS 'GLOBE'	67	24"
	SUGAR MAPLE	ACER SACCHARUM	6	1 1/2"

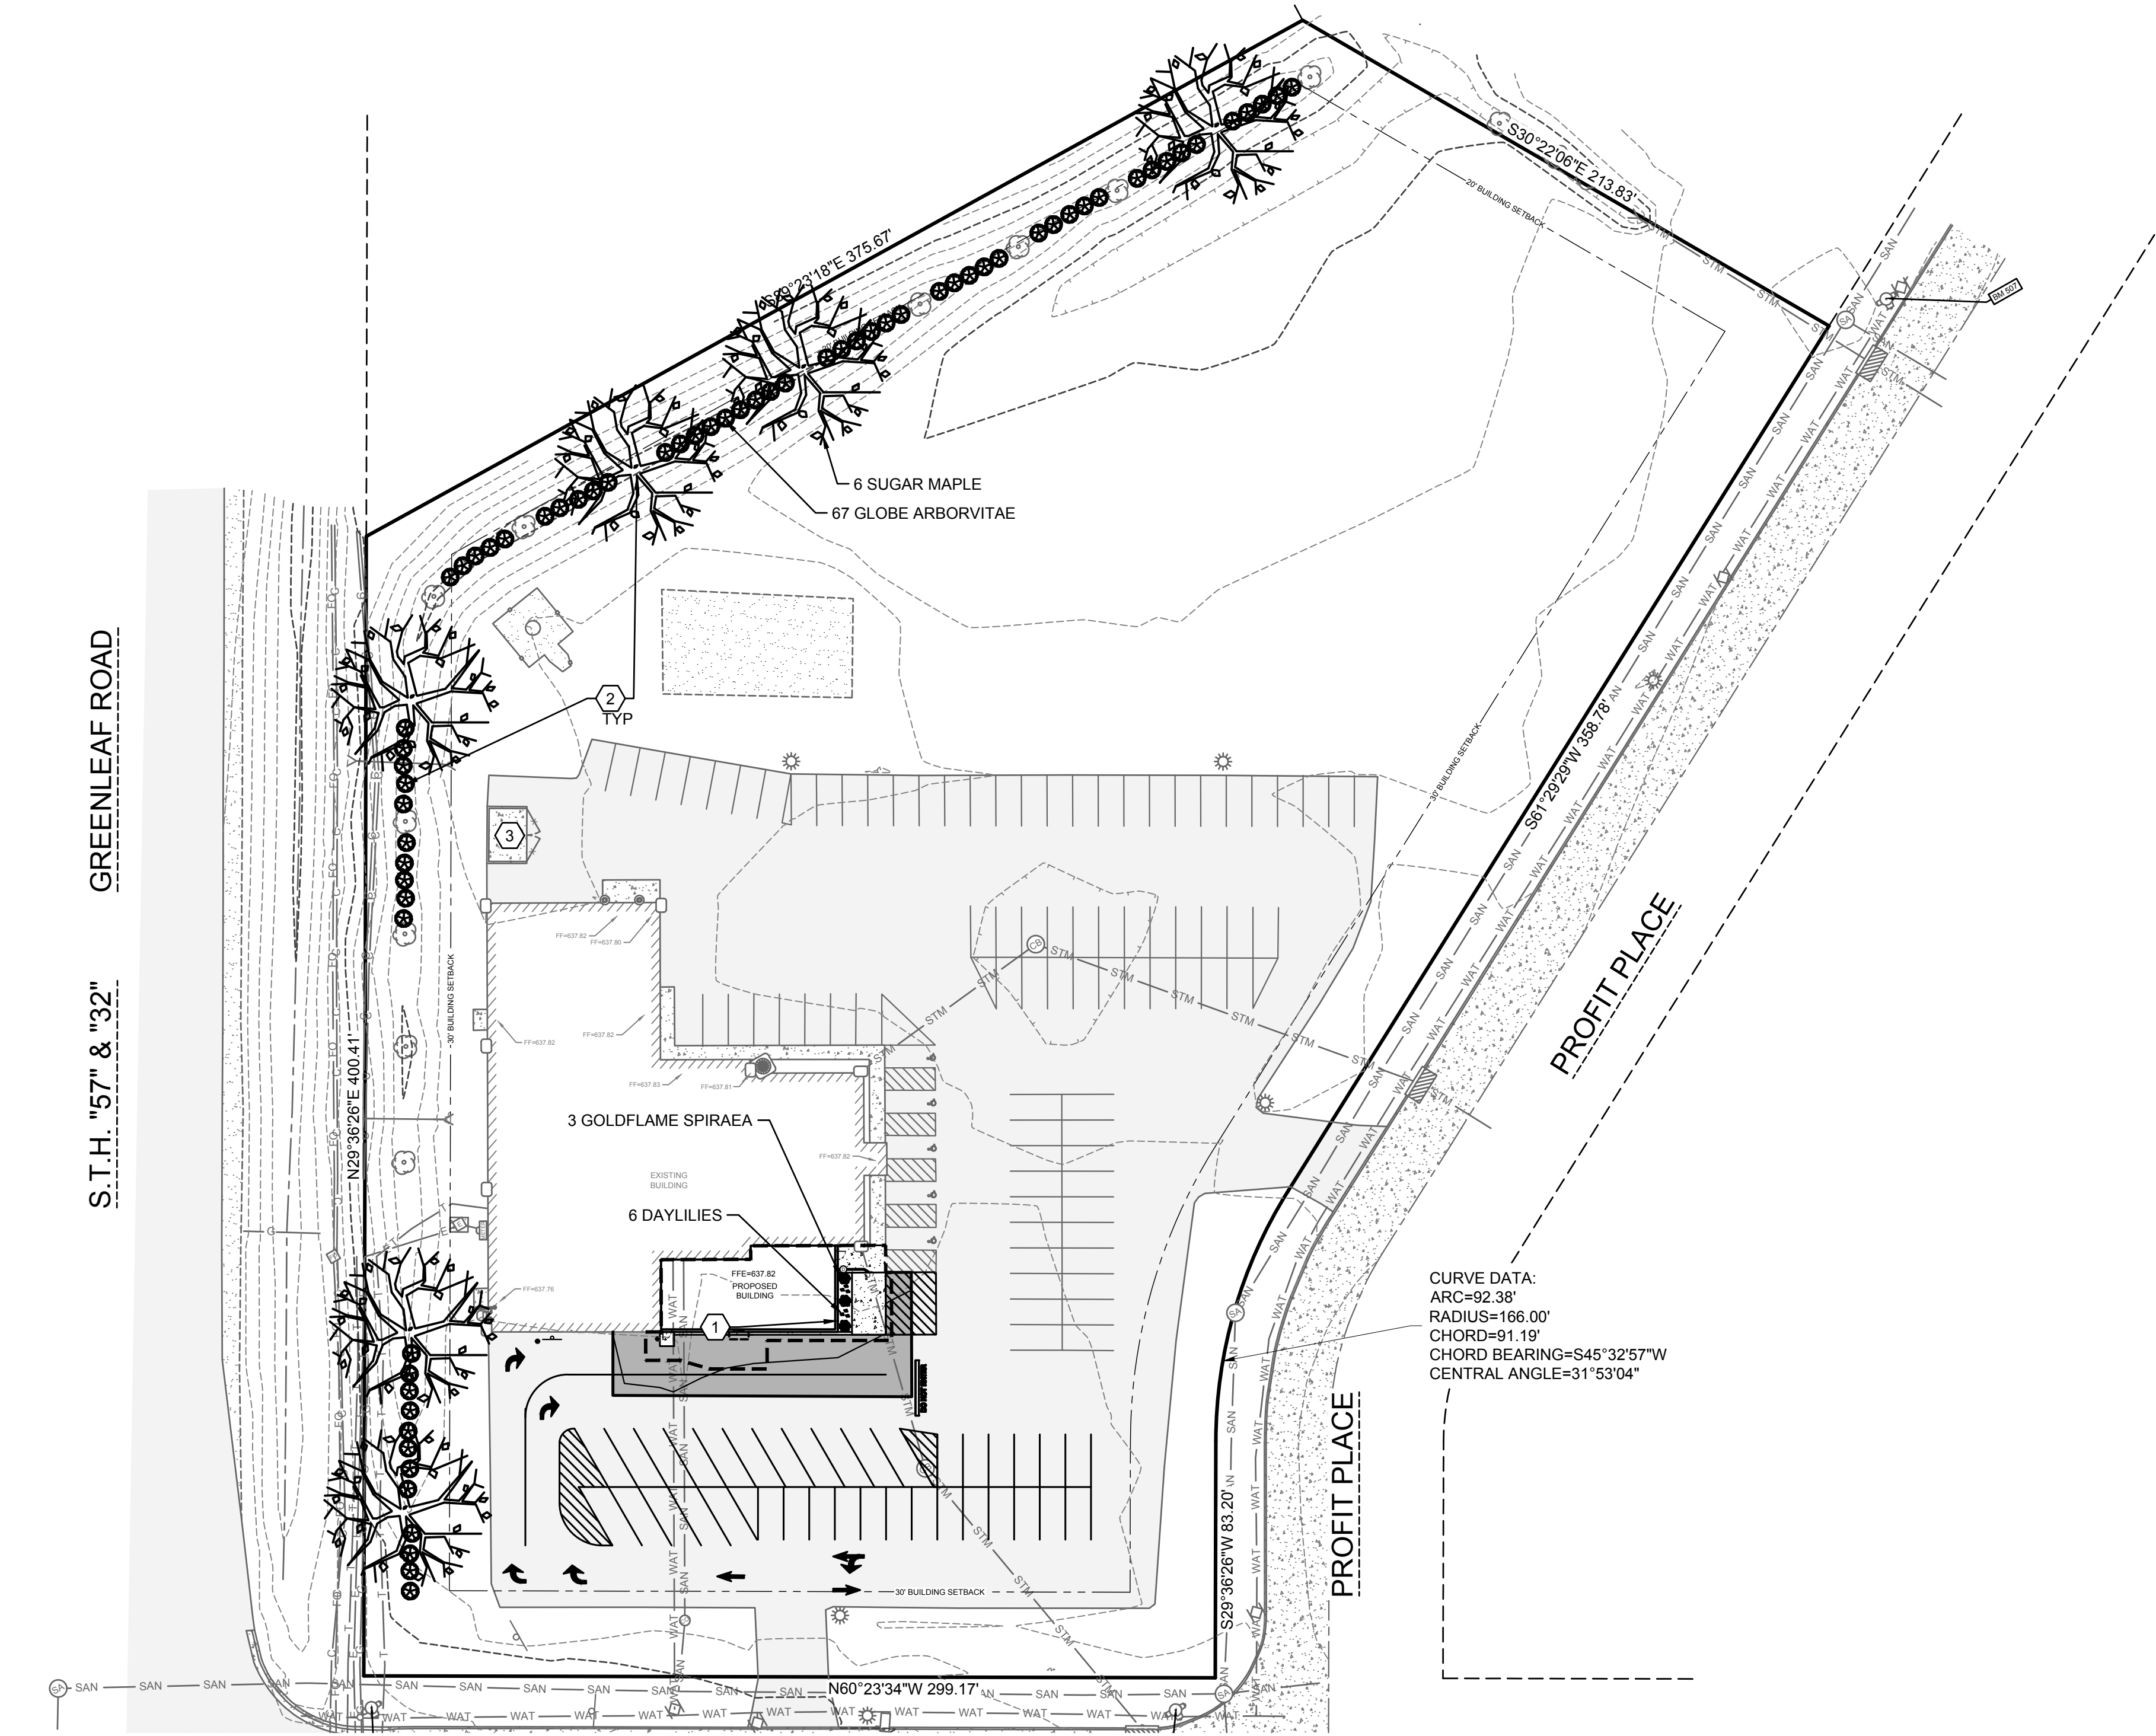


Proposed Building Addition For:

DESTINY CHURCH

DEPERE, WISCONSIN

DATE: 11/02/23
ARCH: K. SPERL
D. BY: RPH
JOB: 22-025
REV: CITY COMMENTS 2024-01-23
CITY COMMENTS 2024-05-09
CITY COMMENTS 2024-09-19


L
1.0

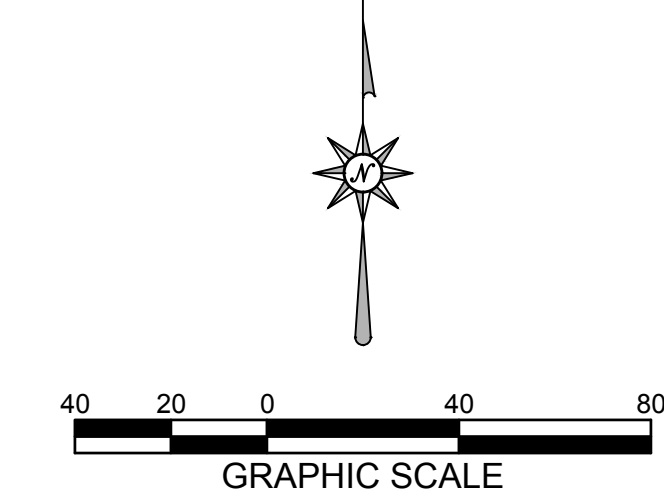


MACH IV
ENGINEERING • SURVEYING • ENVIRONMENTAL

2260 Salscheider Court Green Bay, WI 54313
PH: 920-569-5765; Fax: 920-569-5767
www.mach-iv.com
Project Number: 2109-01-23



ACS
Architectural &
Construction
Services, Inc.
327 RANDOLPH DRIVE - SUITE C
APPLETON, WI 54913
TELE: 920-574-2657 FAX: 920-574-2660

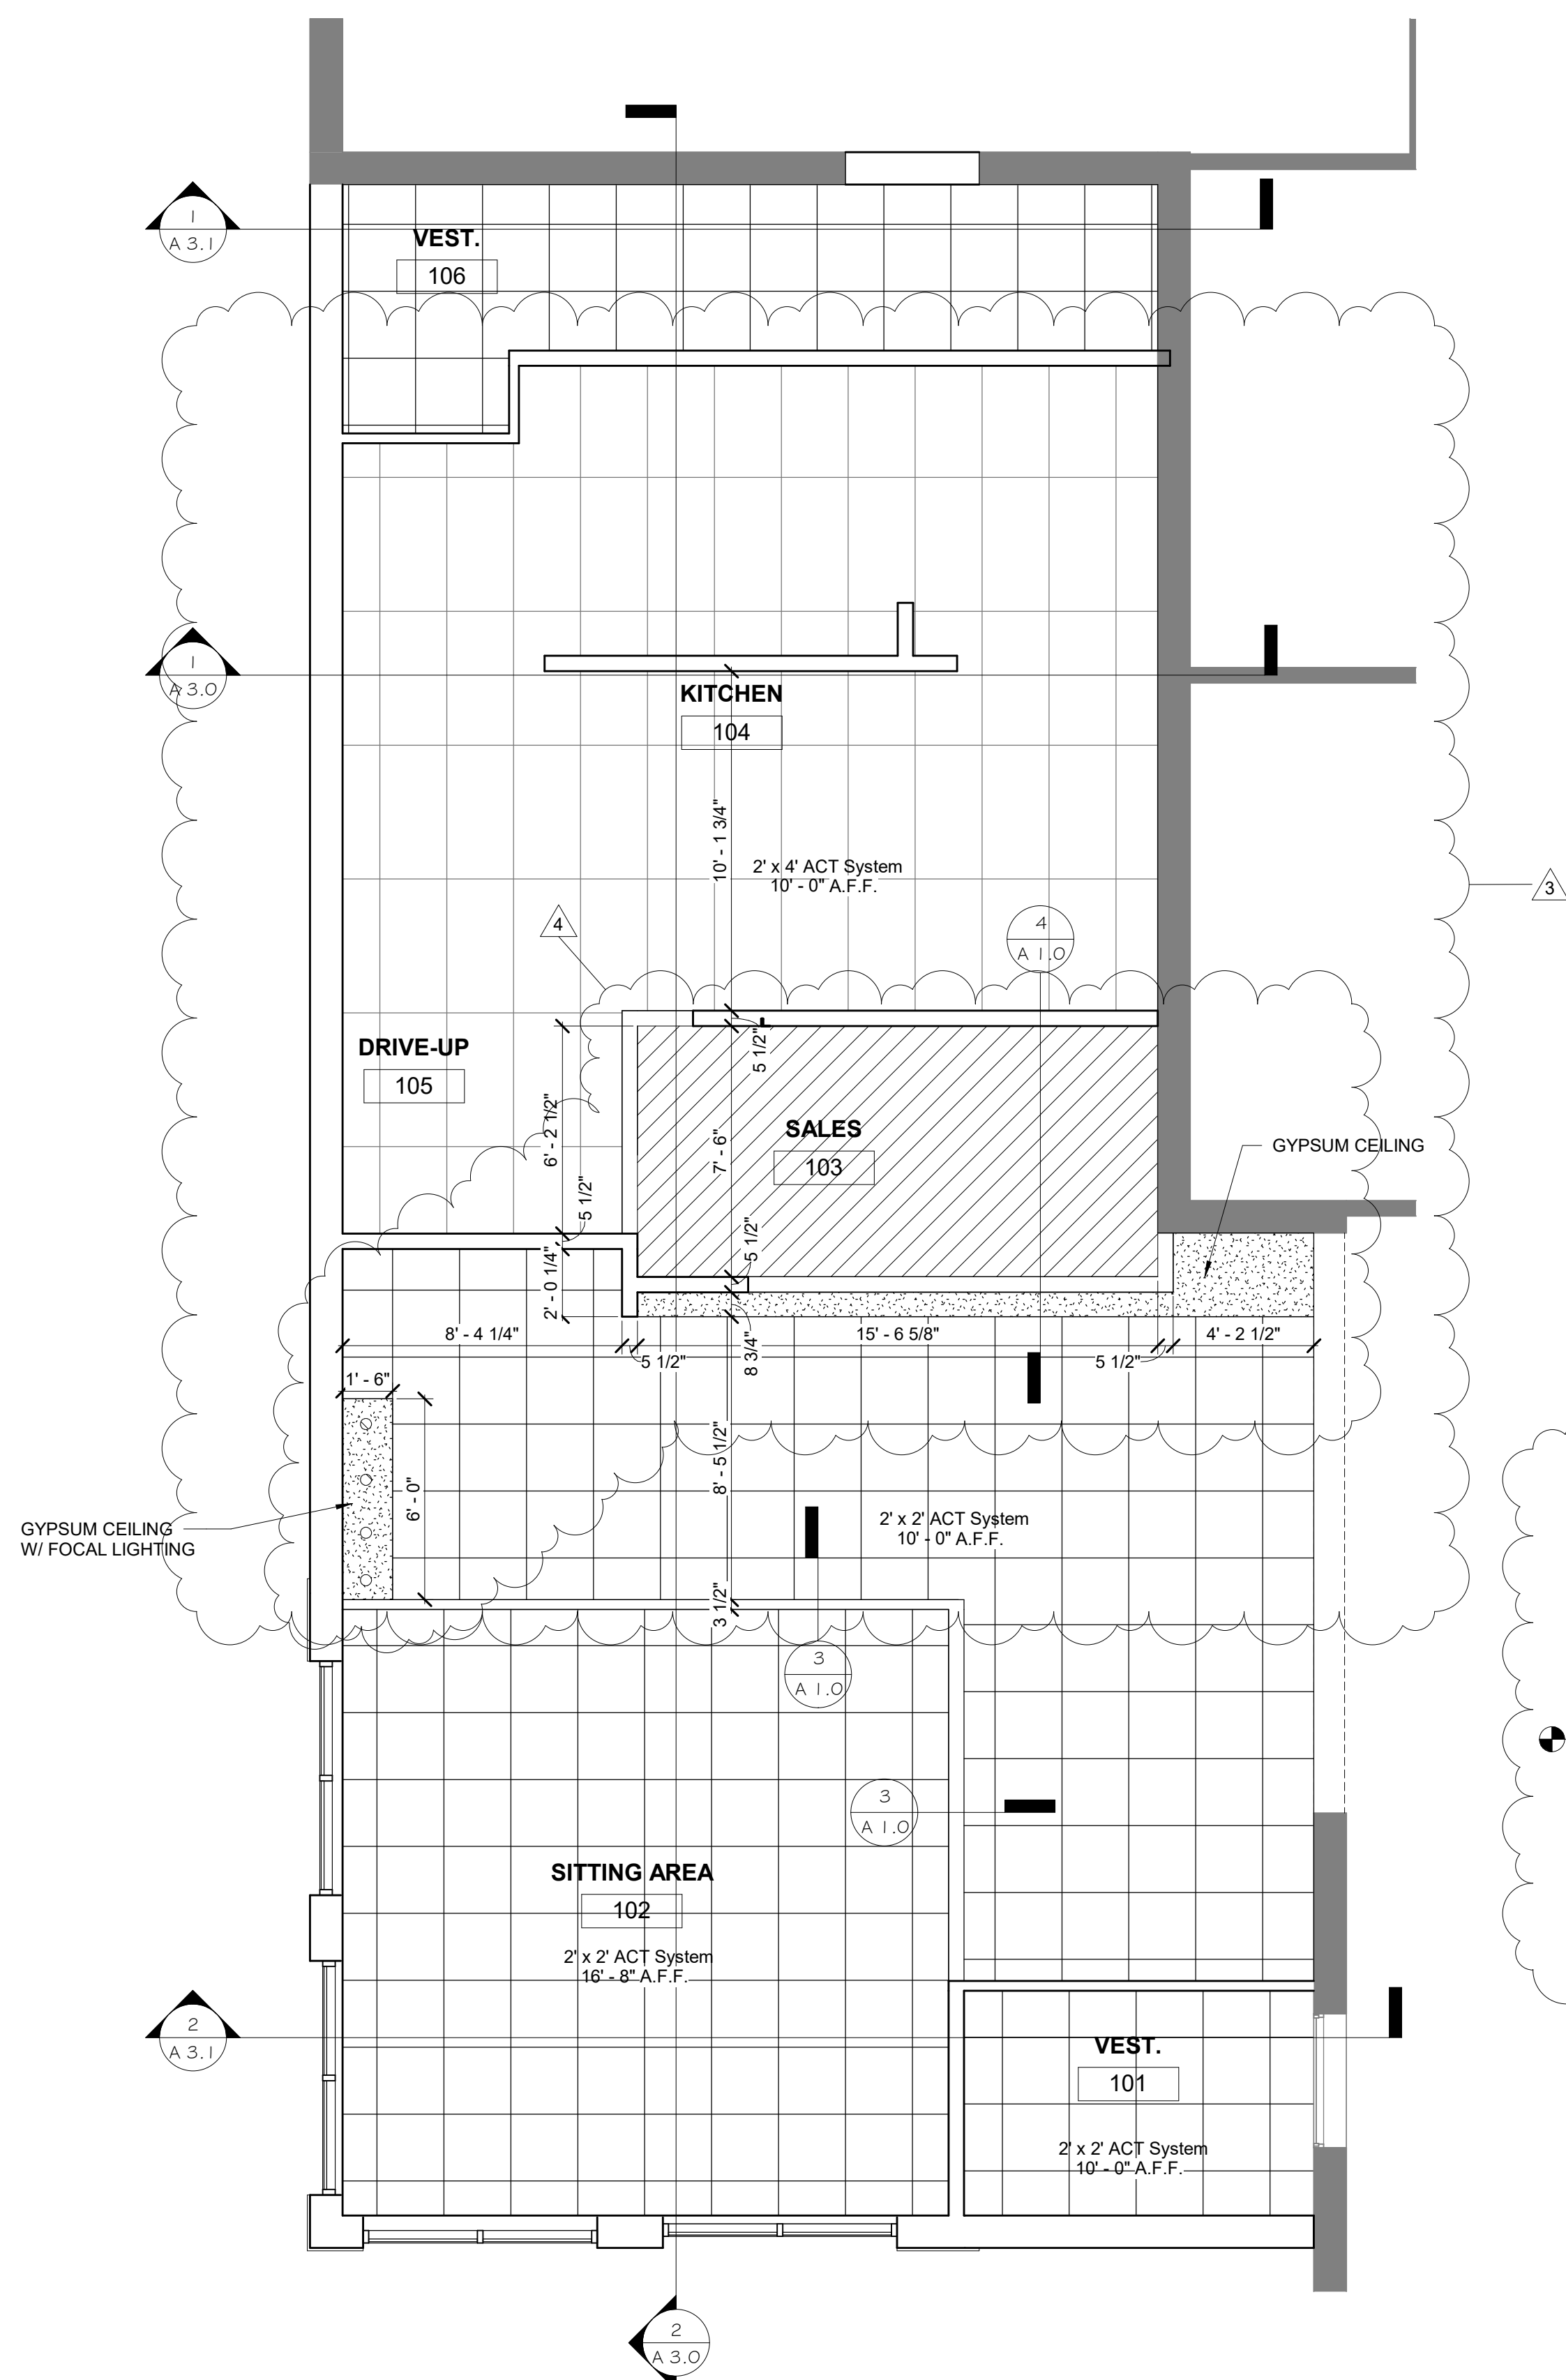


 **Reflected Ceiling Plan**
Scale: 1/4" = 1'-0"

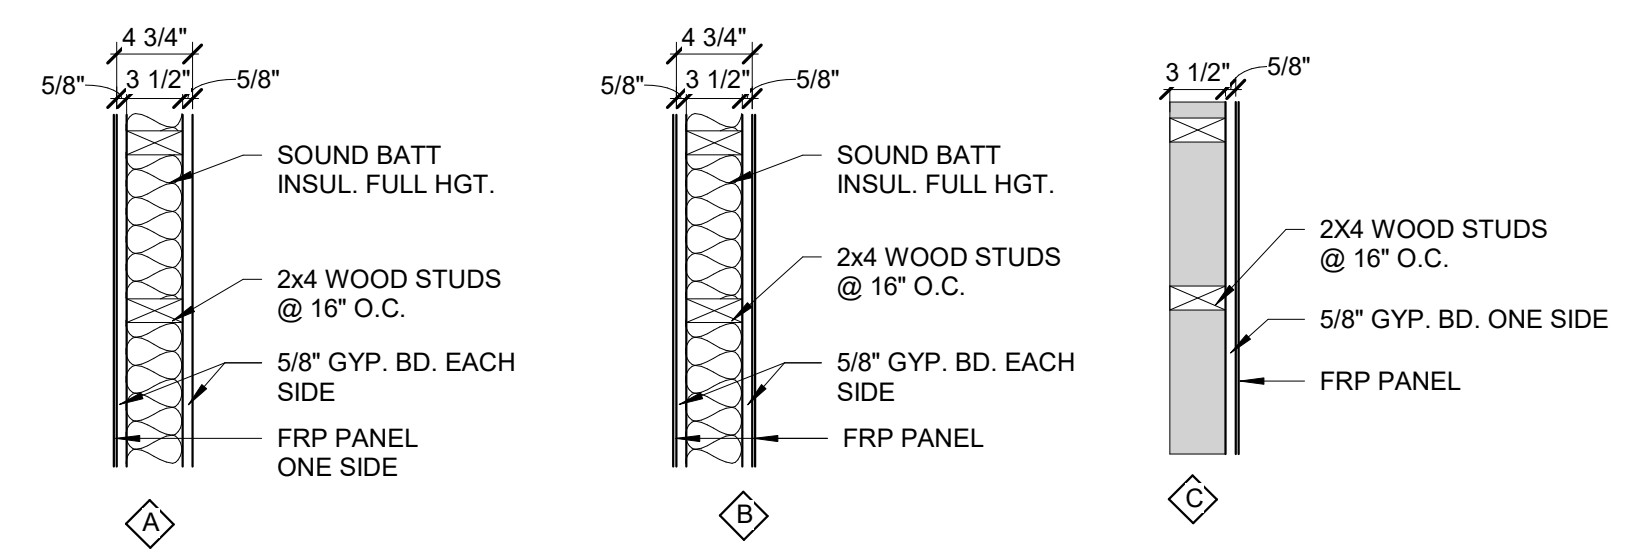

WALL TYPES
Scale: 1" = 1'-0"

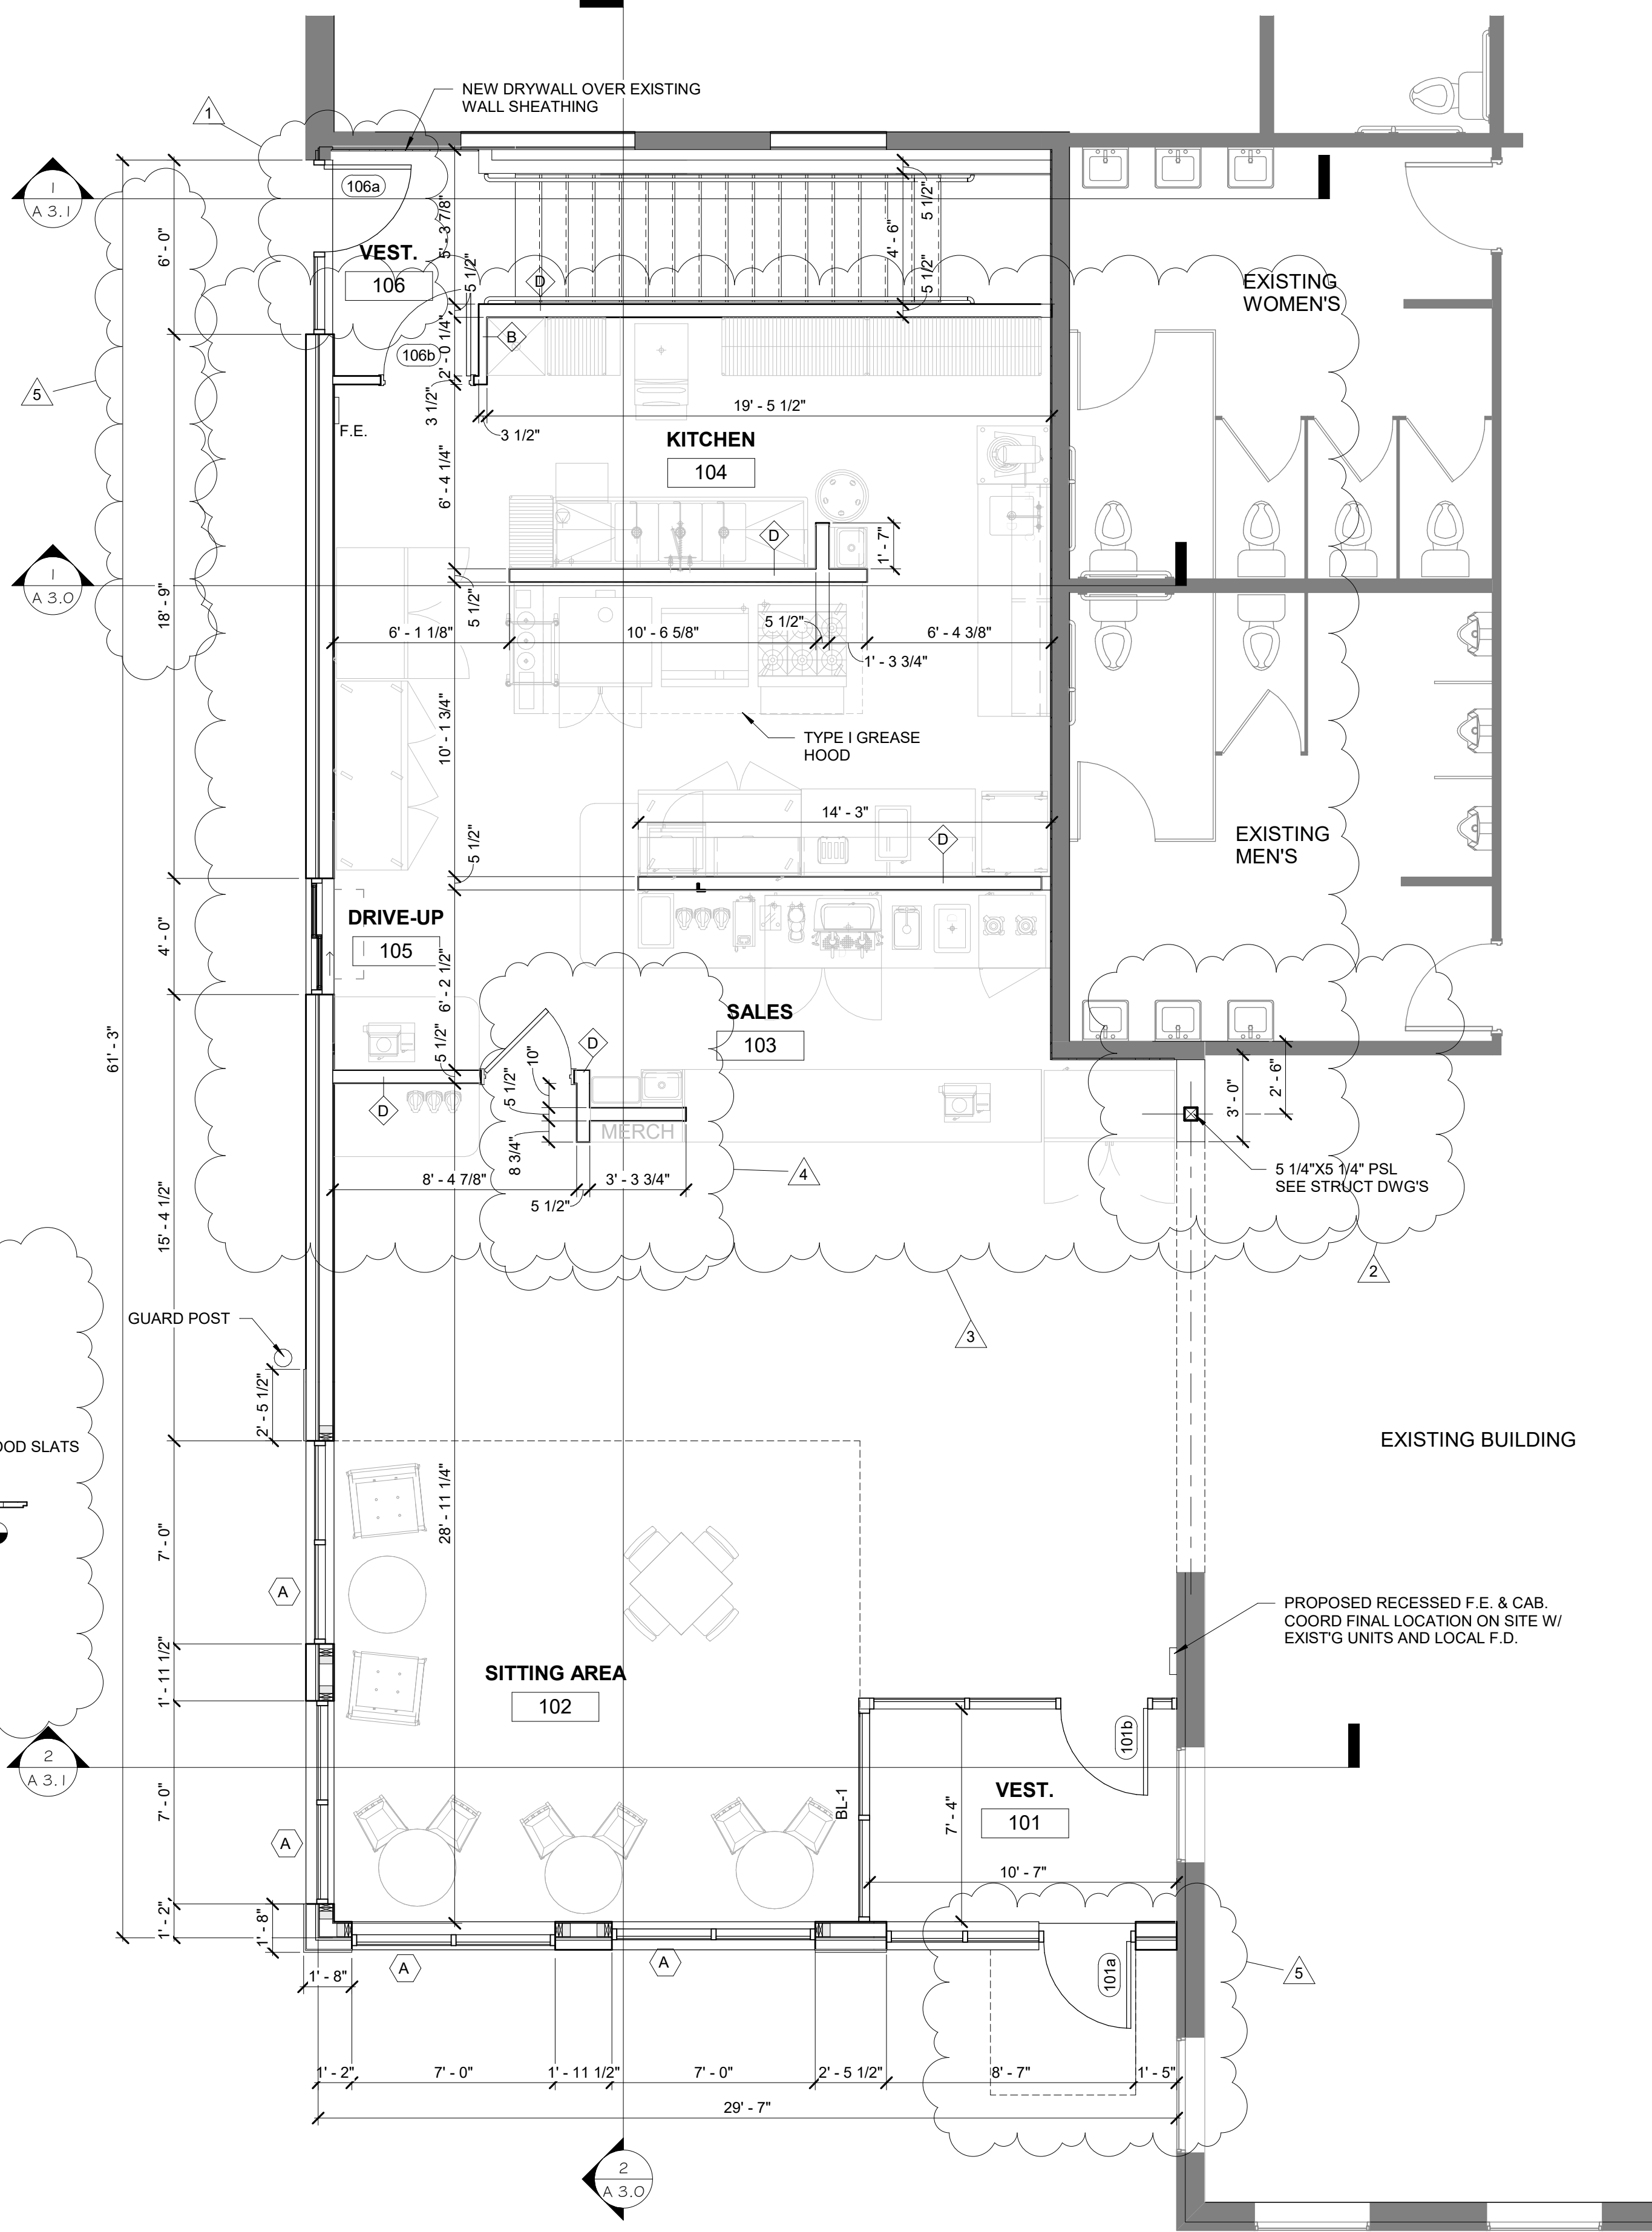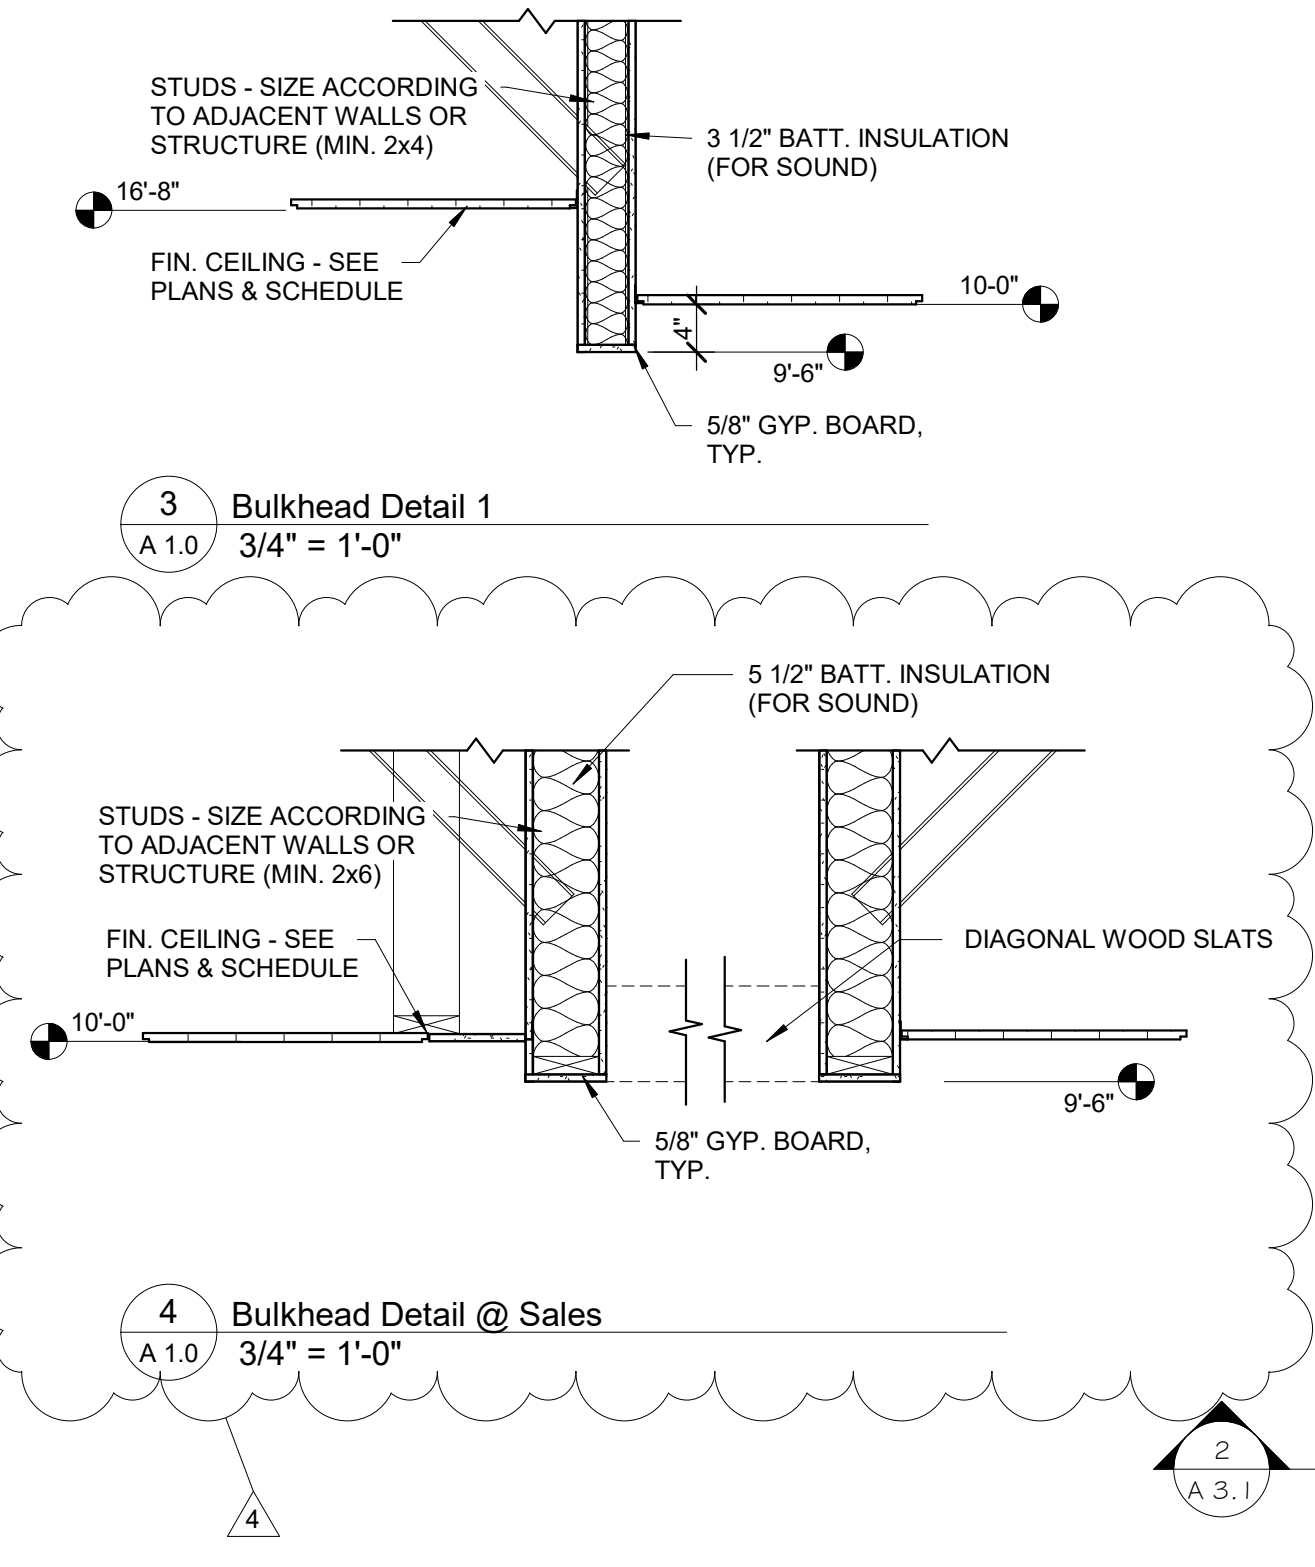


  **FLOOR PLAN**
Scale: 1/4" = 1'-0"

Proposed Building Addition For:
DESTINY CHURCH
DEPERE, WISCONSIN



DATE: 12/14/23
ARCH: K. SPERL
D. BY: J. MILLER
JOB: 22-025
REV: 01-12-23 REVISED PER CITY PLAN REVIEW
02-01-24 REVISED PER STATE REVIEW
03-04-24 REVISED KITCHEN LAYOUT
04-04-24 REVISED FOR INTERIOR DESIGN
05-07-24 REVISED DOOR ADDED STOOP
06-09-24 HVAC SCREENING & DUMPSTER

A
1.0

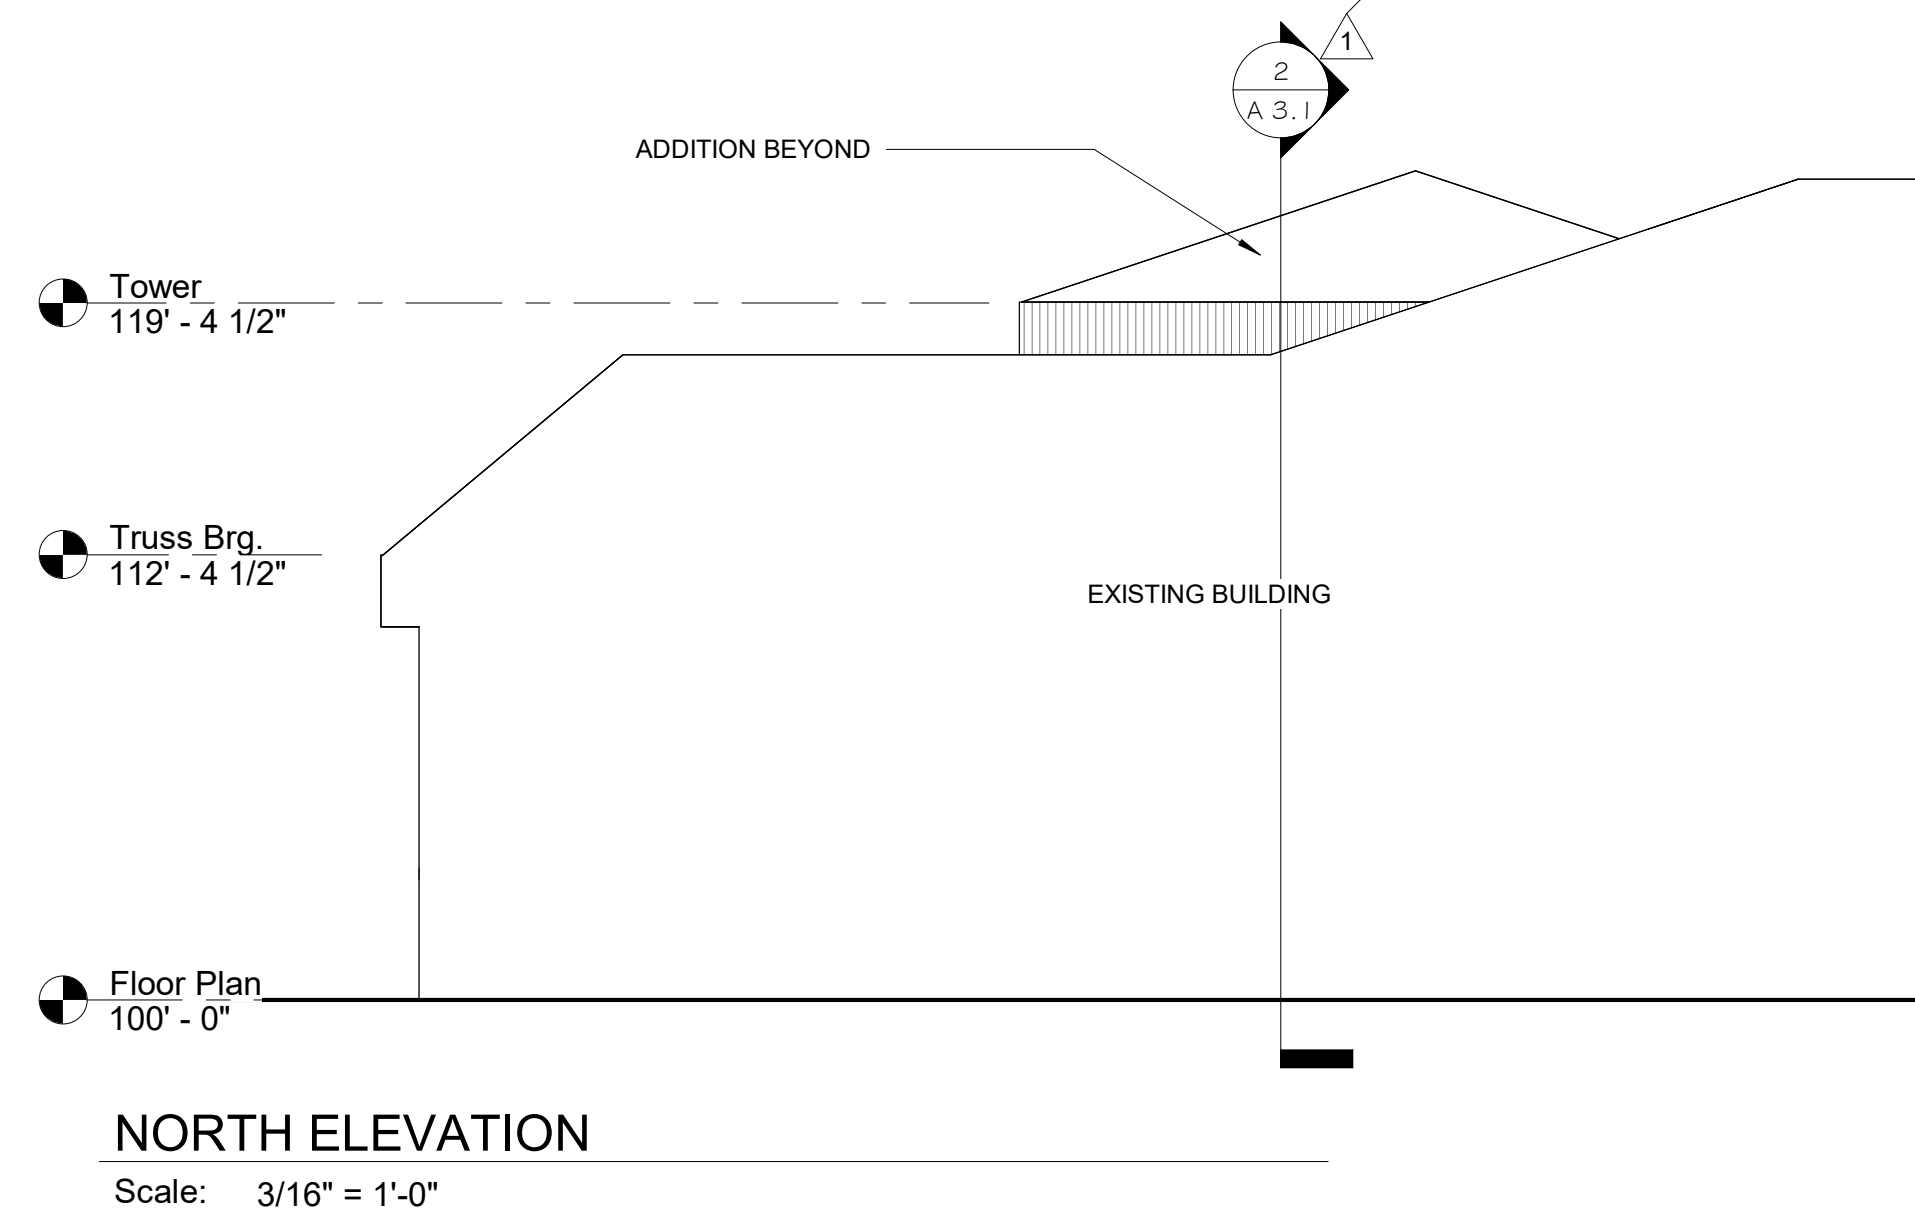

NOTES:

- FINAL WALL SUBSTRATE AND AIR/MOISTURE BARRIER TO BE PER SELECTED ACM MANUFACTURER PRODUCT REQUIREMENTS
- ACM AND MASONRY CONTROL JOINTS PER SELECTED MANUFACTURER AND OR INSTALLING CONTRACTOR
- COURSING TO START WITH 2" SOAP AND OR MATCH EXISTING CMU & BRICK COURSING

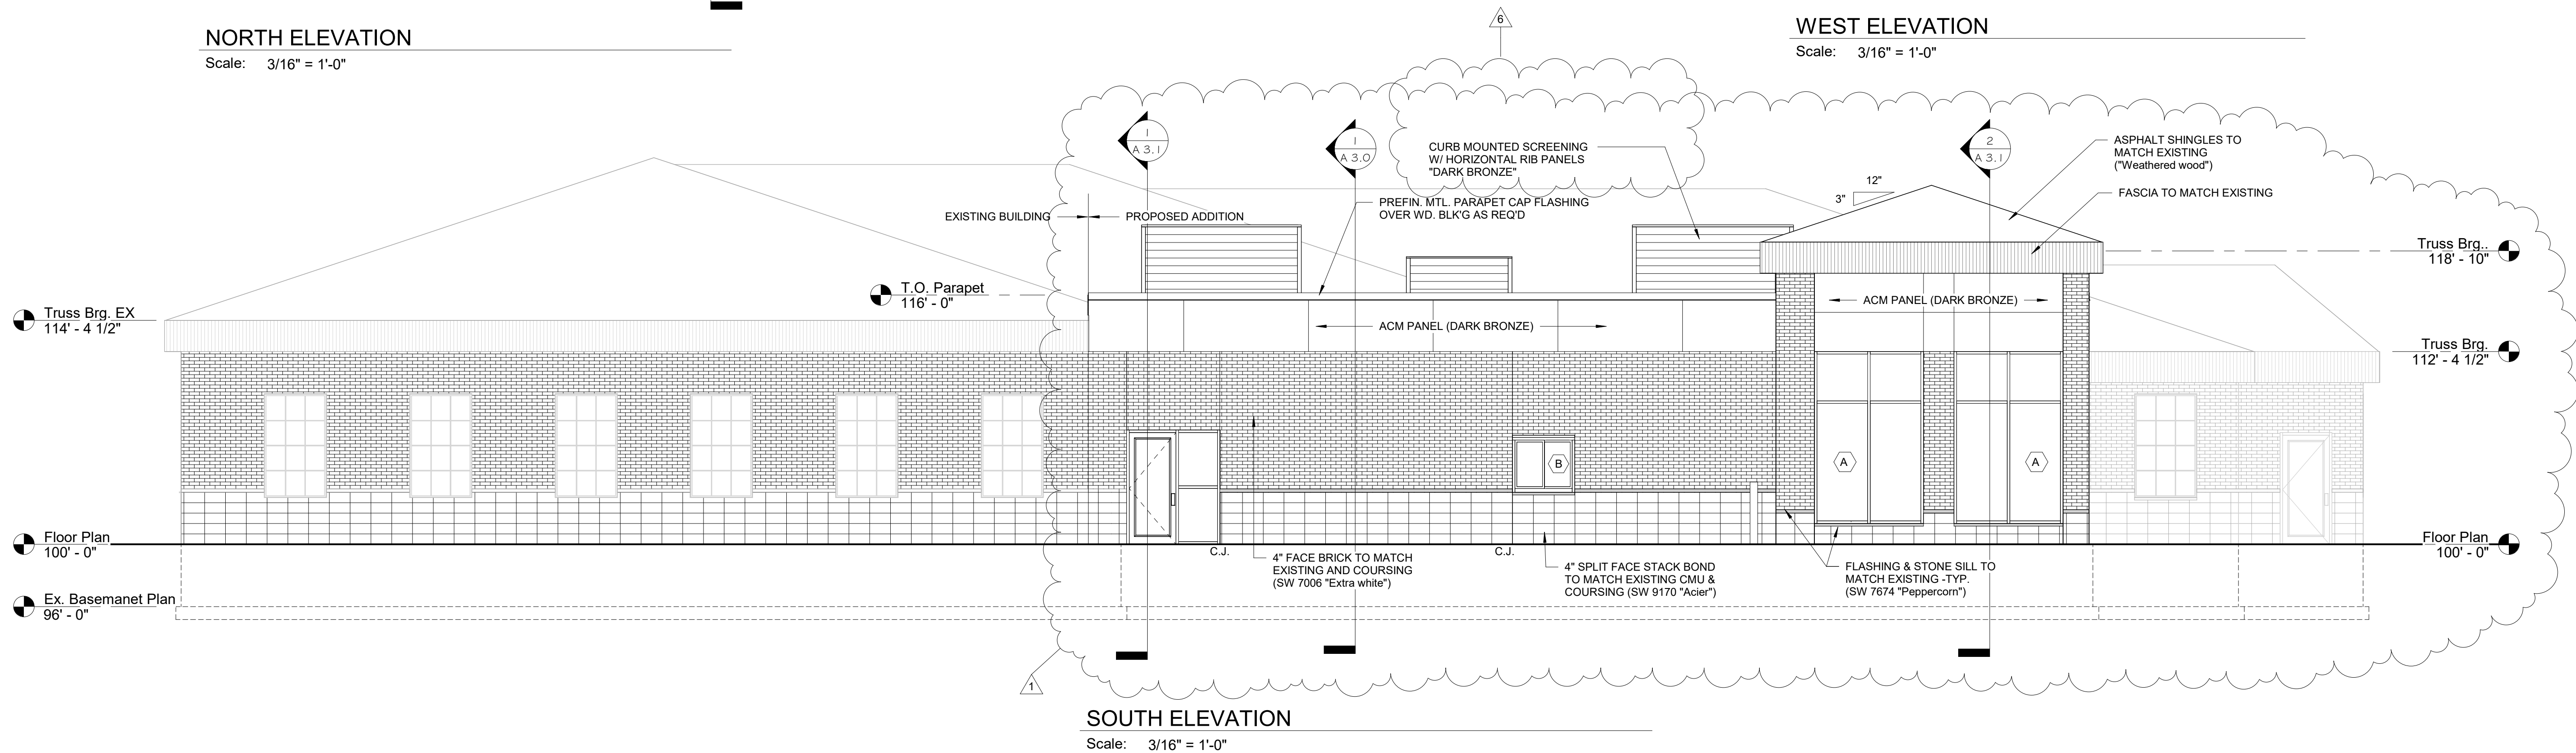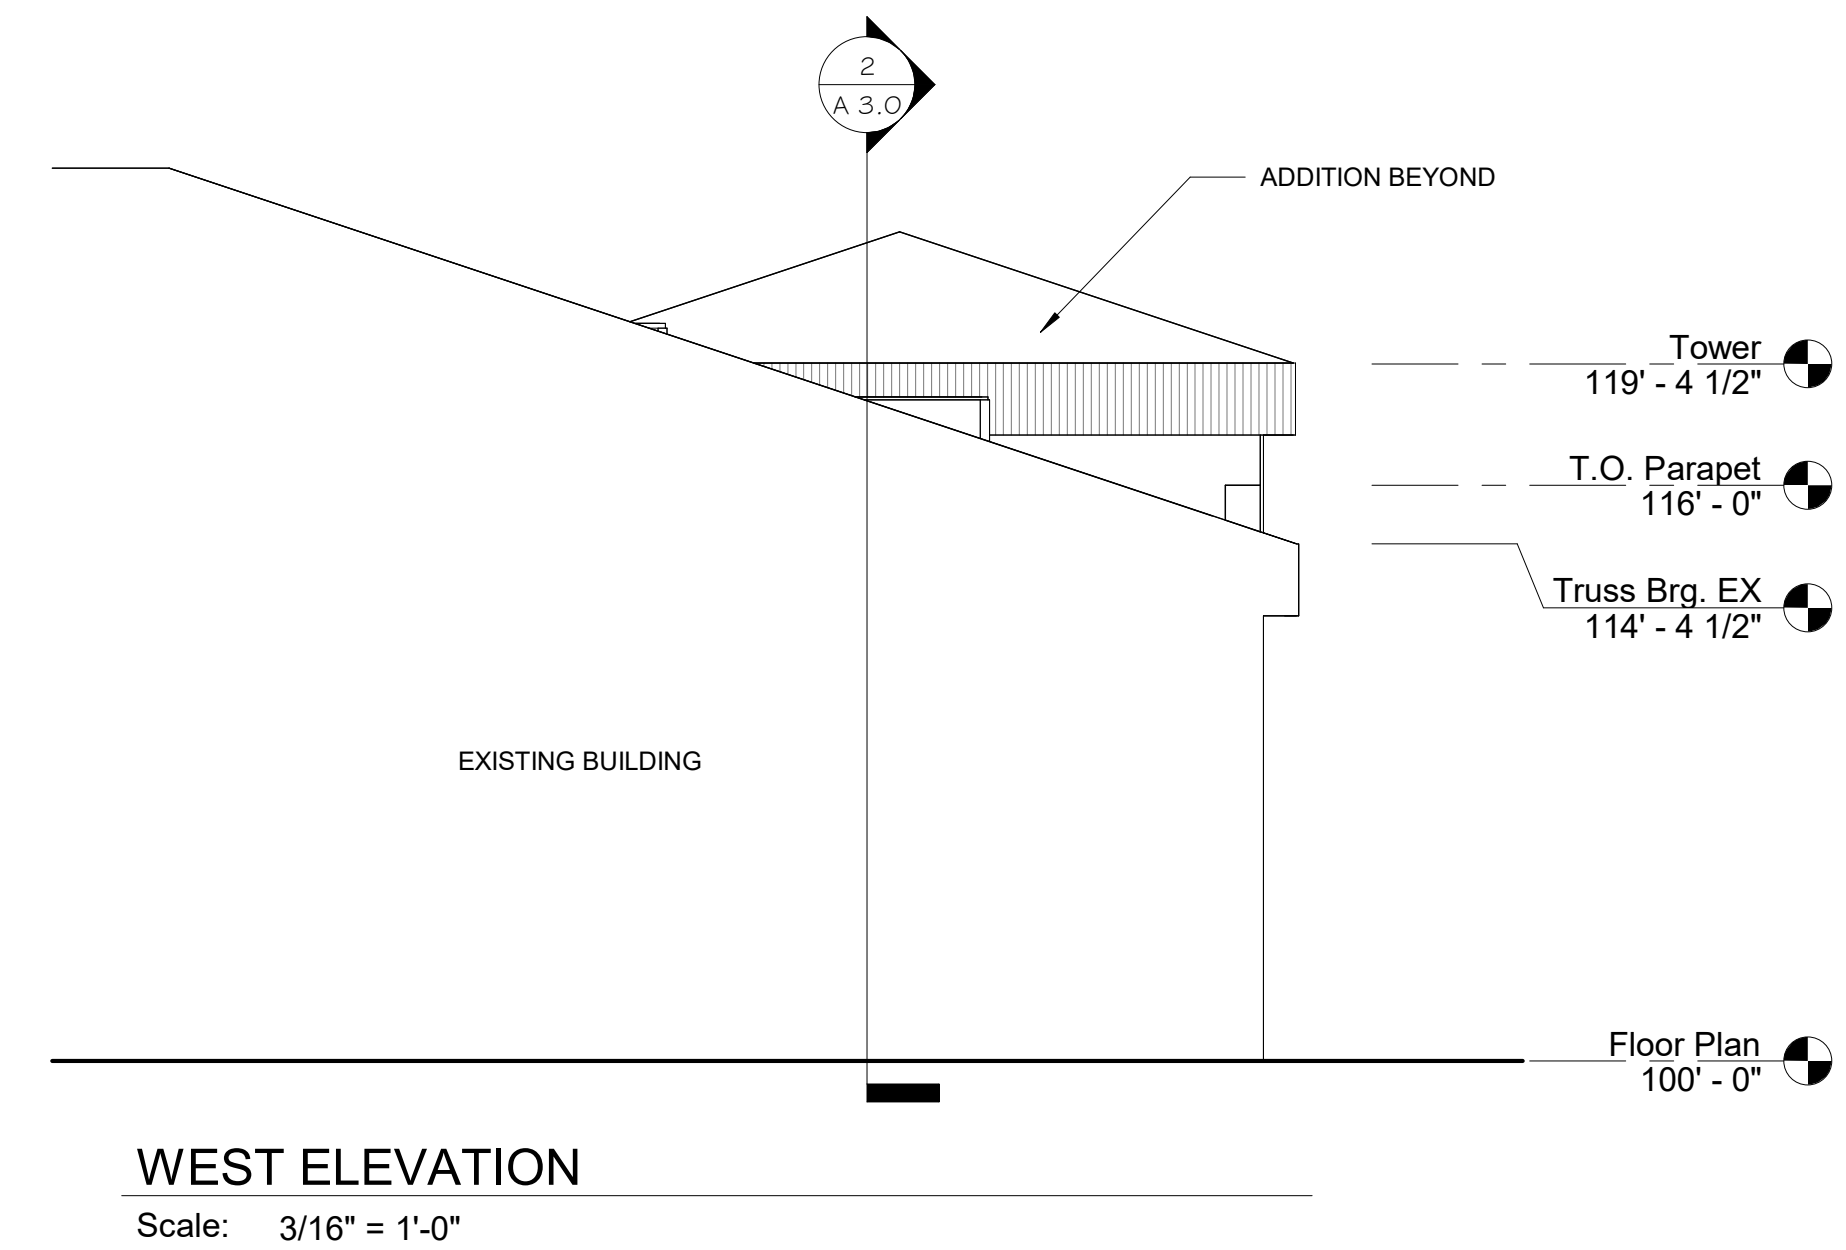

Proposed Building Addition For:

DESTINY CHURCH

DEPERE, WISCONSIN




DATE:	12/14/23
ARCH:	K. SPERL
D. BY:	J. MILLER
JOB:	22-025
REV:	
01 - 12-12-23 REVISED PER CITY PLAN REVIEW	
02 - 01-15-24 REVISED PER STATE REVIEW	
03 - 04-23-24 REVISED KITCHEN LAYOUT	
04 - 04-30-24 REVISED FOR INTERIOR DESIGN	
05 - 07-26-24 REVISED DOOR ADDED STOOP	
06 - 08-30-24 HVAC SCREENING & DUMPSTER	

A
2.0

Door & Frame Schedule													
Door Number	DOOR						Hardware	Frame			DR#	Comments	
	SIZE		TYPE	Material	LITE	LABEL		Type	Material	Finish			
	Width	Height											
101a	3' - 0"	7' - 0"	1	ALUMN.	FULL		PUSH/PULL,CLOSER,THRESHOLD,WEAHTER STRIP	B	ALUM.	PRE. FIN.	101a		
101b	3' - 0"	7' - 0"	1	ALUMN.	FULL		PUSH/PULL,CLOSER,THRESHOLD,WEAHTER STRIP	D	ALUM.	PRE. FIN.	101b		
106a	3' - 0"	7' - 2"	1	ALUMN.	FULL		PUSH/PULL,CLOSER,THRESHOLD,WEAHTER STRIP	C	ALUM.	PRE. FIN.	106a		
106b	3' - 0"	7' - 0"	2	HM	--		LEVER HANDLE	A	HM	PAINTED	106b		


Room No.	Room Name	Floor	Base	Walls				Ceiling	Ceiling Hgt.	RM#	Remarks
				North	South	East	West				
101	VEST.	LVP	VINYL	EX. BRICK	PAINTED DRYWALL	PAINTED DRYWALL	GLASS/PAINTED DRYWALL	CT-2	10' - 0"	101	
102	SITTING AREA	LVP	VINYL	PAINTED DRYWALL	PAINTED DRYWALL	PAINTED DRYWALL	PAINTED DRYWALL	CT-1	16' - 8"	102	
103	SALES	LVP	VINYL	PAINTED DRYWALL	PAINTED DRYWALL	PAINTED DRYWALL	SUBWAY TILES	CT-2/WD SLATS	10' - 0"	103	
104	KITCHEN	LVP	VINYL	FRP	FRP	FRP	FRP	CT-3	10' - 0"	104	
105	DRIVE-UP	LVP	VINYL	FRP	FRP	FRP	FRP	CT-3	10' - 0"	105	
106	VEST.	LVP	VINYL	FRP	FRP	FRP	FRP	CT	10' - 0"	106	

NOTES:
1. ALTERNATE FOR EPOXY FLOOR
2. ACOUSTICAL CEILING TILE: AMERICAN TIN - MATTE BLACK
CT = EXP OR STOCK CEILING TILE
CT-1 = 2x2 VICTORIAN CEILING TILES
CT-2 = 2x2 STRATFORD CEILING TILES
CT-3 = 2x4 LUMAWASH
3. SUBWAY TILES TO BE GREEN/BLUE COLOR AND INSTALLED IN HERRING BONE PATTERN

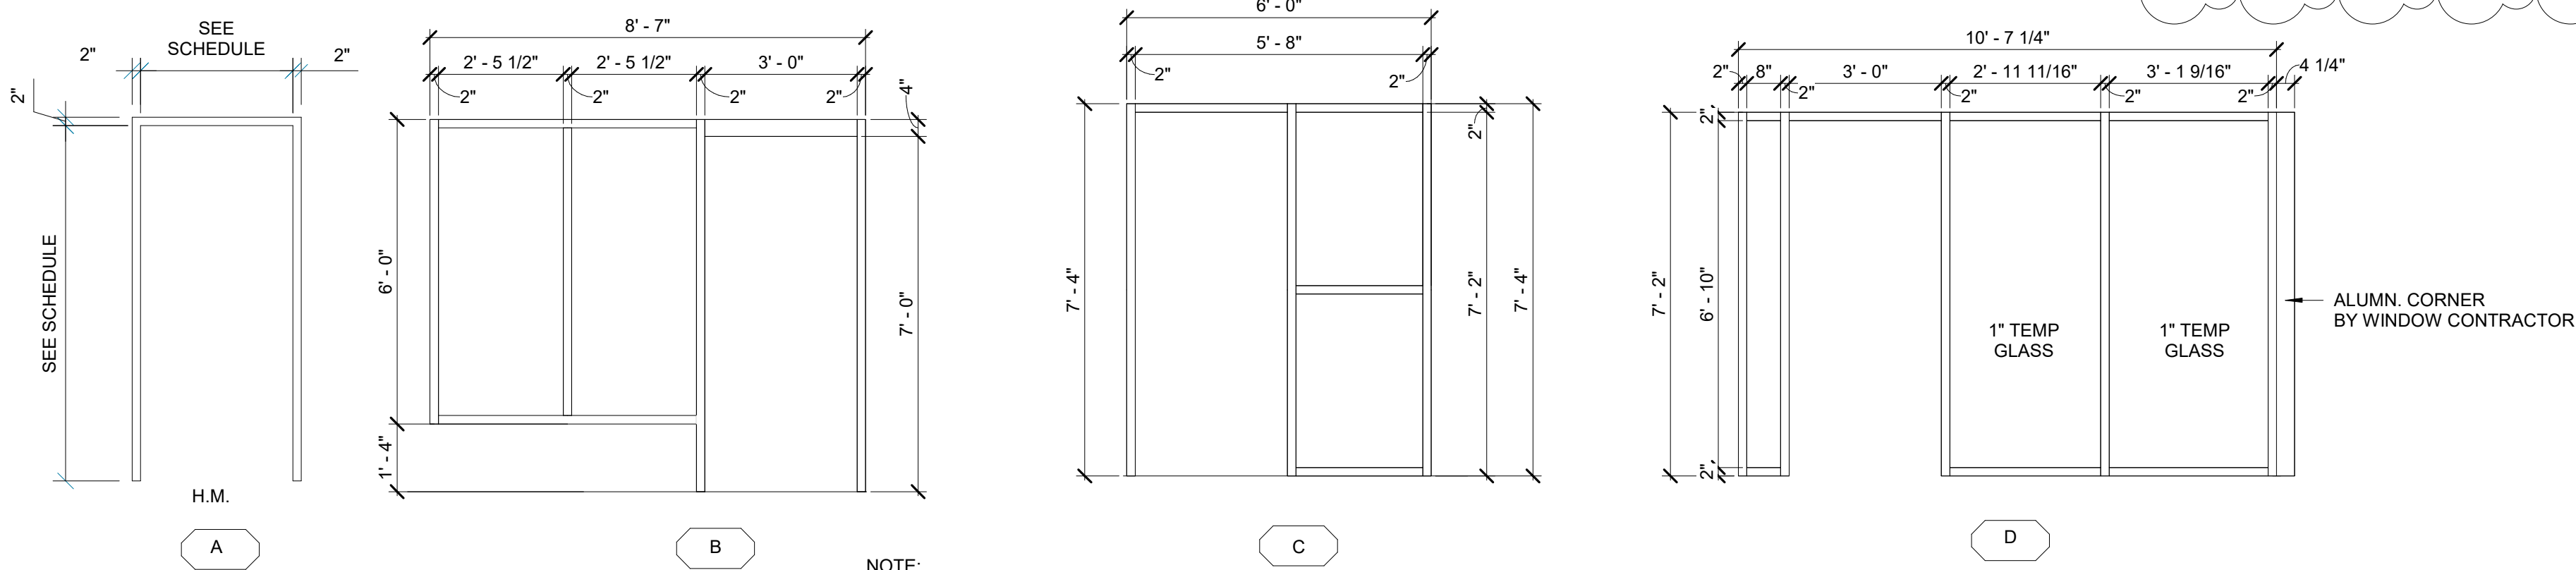

DOOR FRAME ELEVATIONS


Scale: 3/8" = 1'-0"

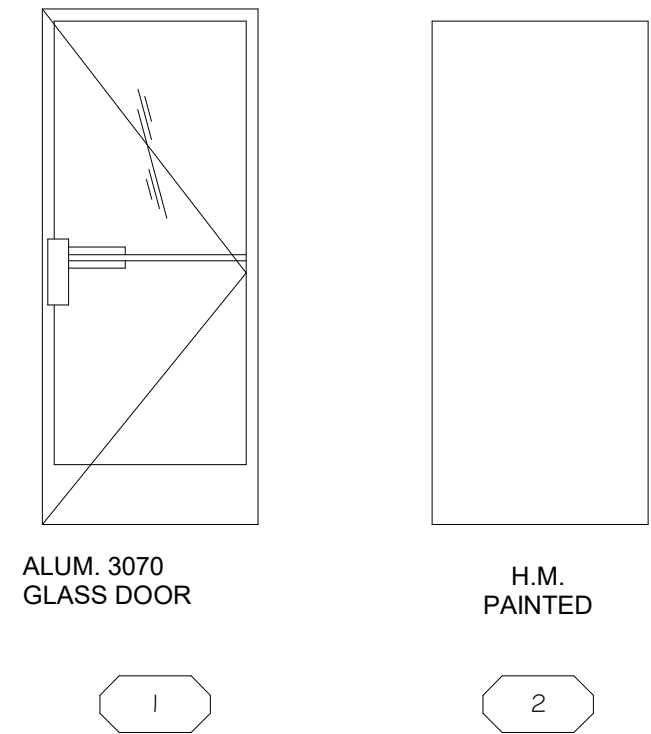

DOOR ELEVATIONS


Scale: 3/8" = 1'-0"

NOTE:
1" INSUL. GLASS @ EXT.
TINTED, LOW-E, THERMAL PANES
ANODIZED ALUMN. FRAMES
W. THERMAL BREAK

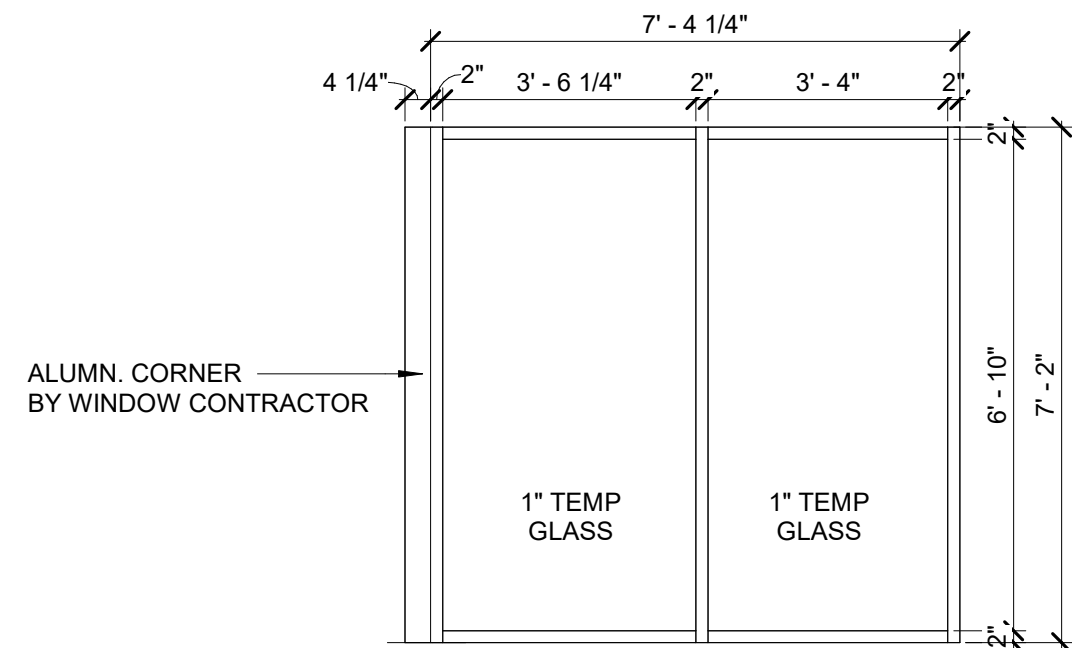

BORROWED LITE "BL-1"

Scale: 3/8" = 1'-0"

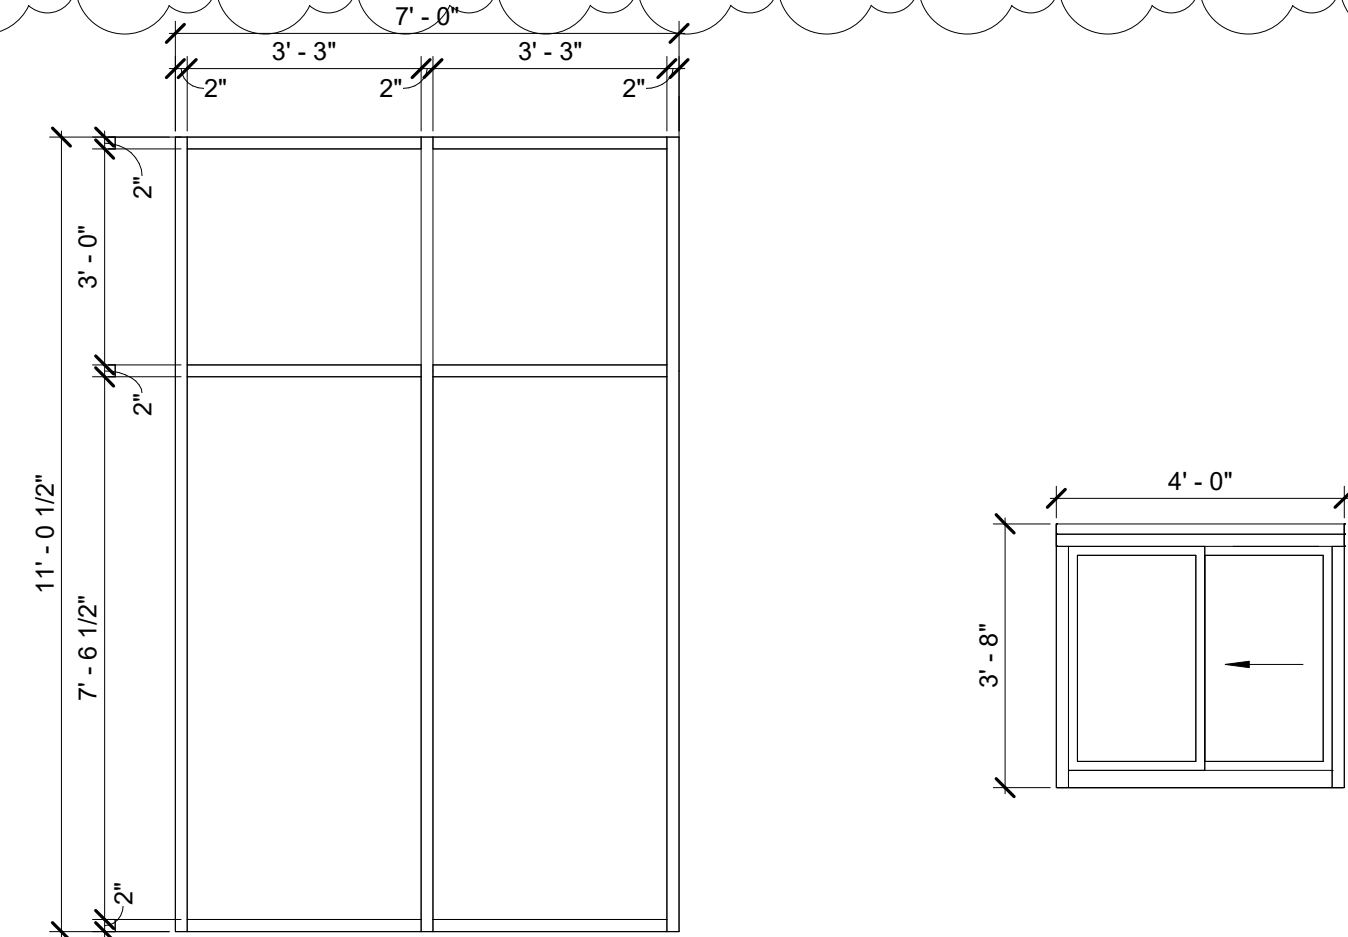


Window "A"

Scale: 3/8" = 1'-0"


Window "B"

Scale: 3/8" = 1'-0"

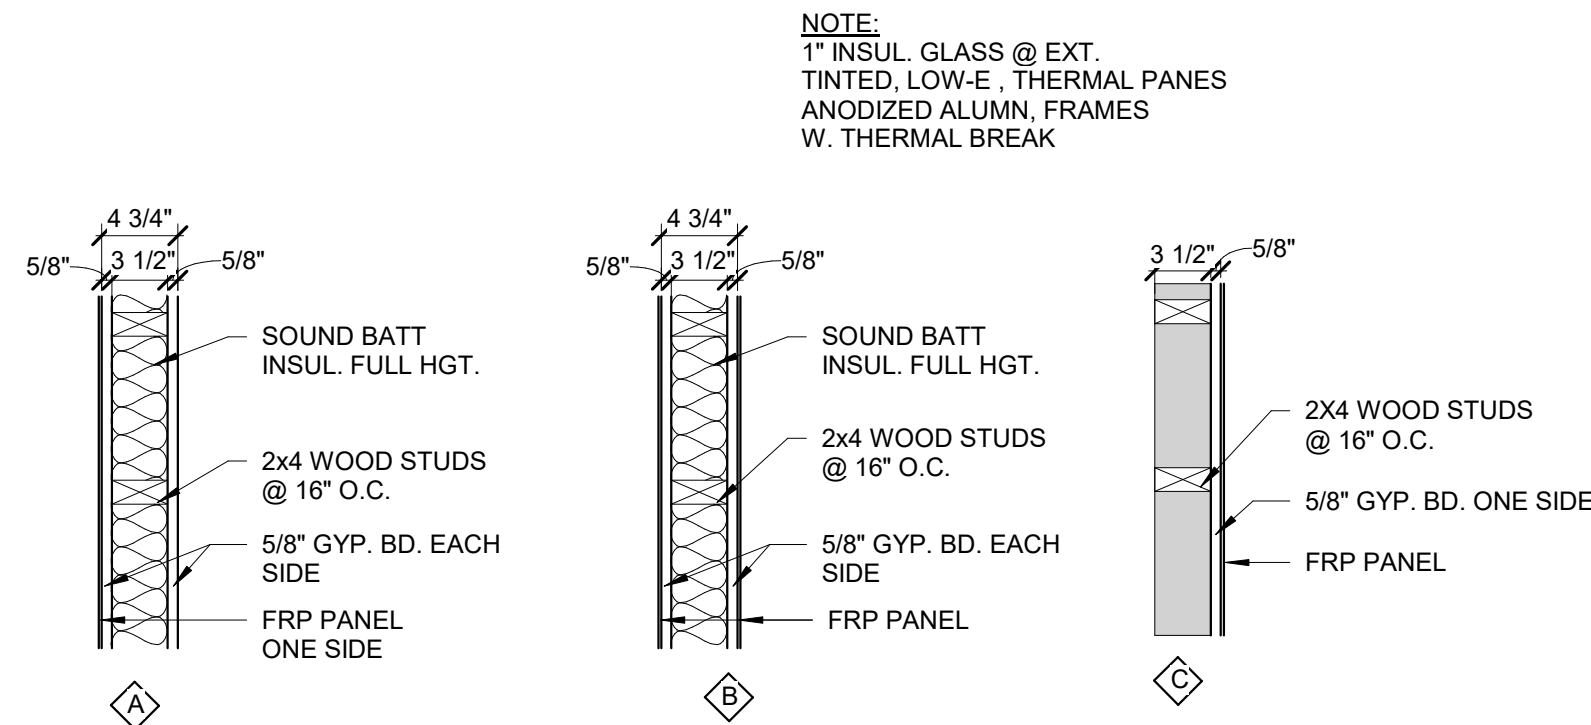

WALL TYPES

Scale: 1" = 1'-0"

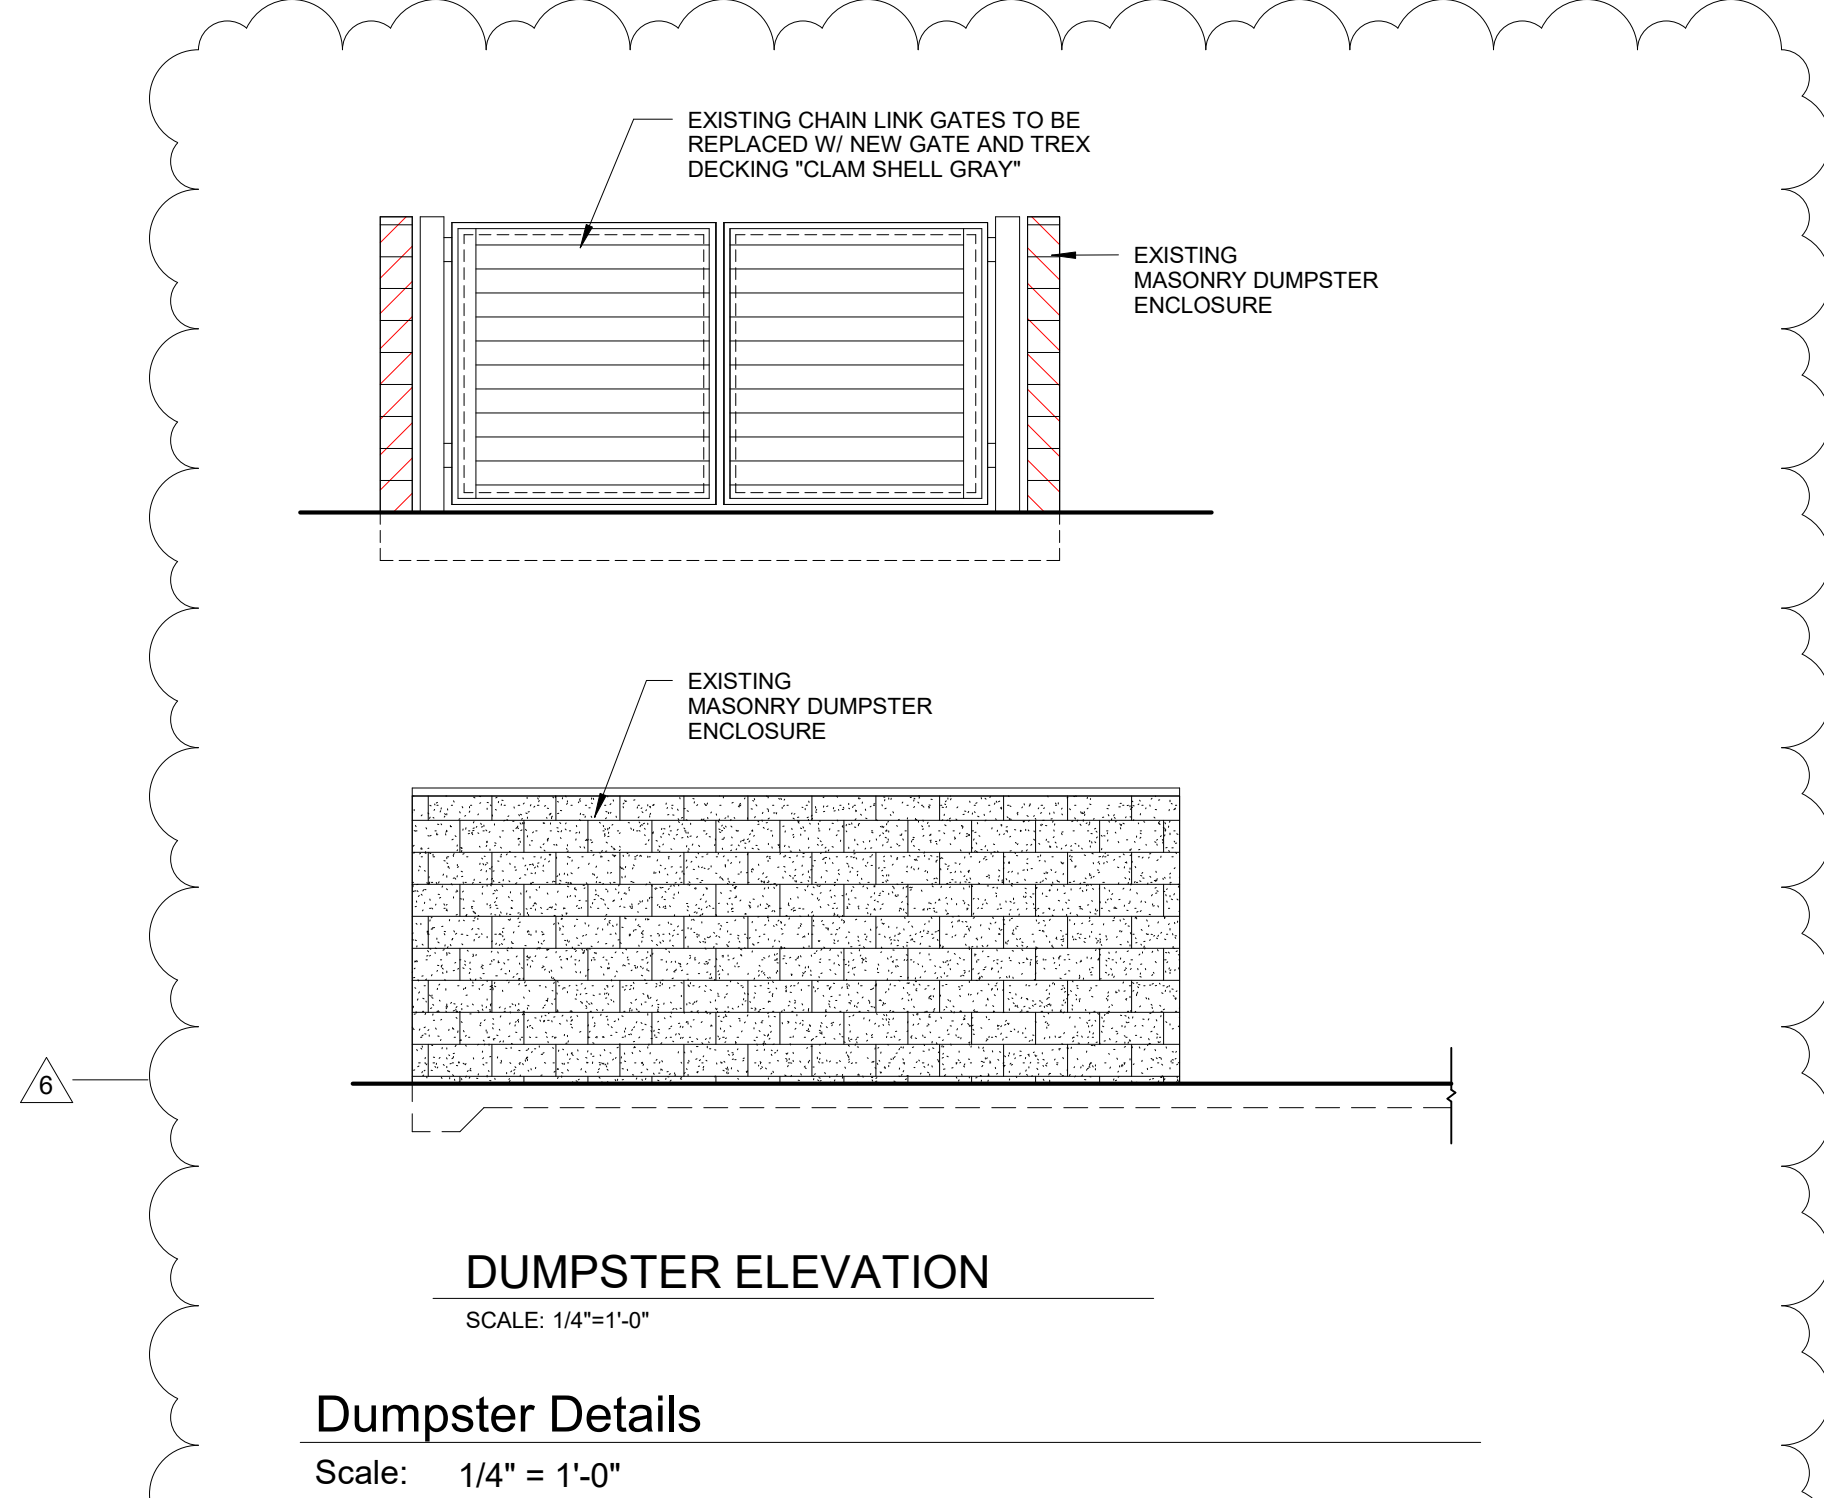

DUMPSTER ELEVATION

SCALE: 1/4"=1'-0"

Dumpster Details

Scale: 1/4" = 1'-0"



Calculation Summary							
Label	CalcType	Units	Avg	Max	Min	Avg/Min	Max/Min
CalcPts 1	Illuminance	Fc	0.21	14.4	0.0	N.A.	N.A.

REUSING EXISTING POLE LOCATIONS ONLY.
PLAN HAS BEEN REVIEWED AND COMPLIES WITH CITY OF DEPERE ZONING ORDINANCE 14-95 PER THE FOLLOWING:
- LIGHT TREPASS OF 0.5FC OR LESS AT PROPERTY LINE
- FIXTURES ARE CERTIFIED DARK SKY APPROVED FIXTURES
- COLOR TEMPERATURE TO BE 3000K COLOR TEMP
- POLE FIXTURE HEIGHT OF 15.5FT ABOVE GRADE (POLES ARE EXISTING)
- RECESSED SOFFIT LIGHTING MOUNTED WITHIN SOFFIT OF BUILDING
- NO NEON LIGHTING IS BEING UTILIZED
- NO TEMPORARY LIGHTING IS BEING UTILIZED

Luminaire Schedule							
Symbol	Qty	Label	Tag	Description	Arrangement	LLF	Luminaire Lumens Watts
	37	LEDRT56700093 OFL80 NAED 74291	R6	LEDRT56700 color temp of 3000k, mounted in soffit	Single	0.900	772 9.430493
	1	KT-ALED70-S2-OSA-NM-830-VDIM single	Y14	KT-ALED70-S2-OSA-NM-830-VDIM (T4) 120V type 4 distribution, zero degree tilt, replacing existing fixtures on existing pole. set to 3000k color temp	Single	0.900	9758 67.79
	3	KT-ALED70-S2-OSA-NM-830-VDIM single HSS	Y14H	KT-ALED70-S2-OSA-NM-830-VDIM (T4) HSS type 4 distribution with house side shield, zero degree tilt, replacing existing fixtures on existing pole. set to 3000k color temp	Single	0.900	9758 67.79
	2	KT-ALED70-S2-OSA-NM-830-VDIM 2@90	Y249	KT-ALED70-S2-OSA-NM-830-VDIM (T4) 120V type 4 distribution, zero degree tilt, replacing existing fixtures on existing pole. set to 3000k color temp	2 @ 90 degrees	0.900	9758 67.79

- STANDARD REFLECTANCE OF 80/50/20 UNLESS NOTED OTHERWISE.
- NOT A CONSTRUCTION DOCUMENT- FOR DESIGN PURPOSES ONLY.
- STANDARD INDOOR CALC POINTS @ 30" AFF UNLESS NOTED OTHERWISE.
- STANDARD OUTDOOR CALC POINTS @ GRADE UNLESS NOTED OTHERWISE.
- EGRESS CALC POINTS @ 0'-0" AFF.
- PHOTOMETRICS ARE ESTIMATED LIGHTING CALUCULATIONS.
VIKING ELECTRIC ASSUMES NO RESPONSIBILITY FOR INSTALLED LIGHT LEVELS DUE TO FIELD CONDITIONS.
- VIKING ELECTRIC NOT RESPONSIBLE FOR FINAL REVIEW OF CODE REQUIREMENTS.




Drawn By: JB
Project #: 132497
Date: 8/27/2024
Scale: 1" = 40'


PHOTOMETRIC SITE PLAN

DESTINY CHURCH
DEPERE, WISCONSIN

MOUNTING STYLES | SELECT THE MOUNTING SYTLE YOUR PROJECT WILL USE

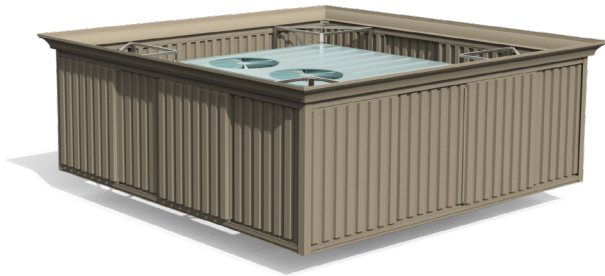


UNIT-ATTACHED

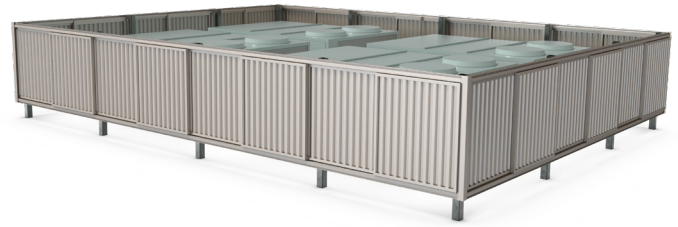☐


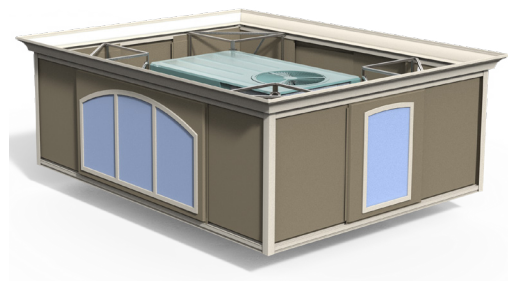
POST-MOUNTED

☐

SCREENING SYSTEMS | SELECT THE SCREENING SYSTEM YOUR PROJECT WILL USE

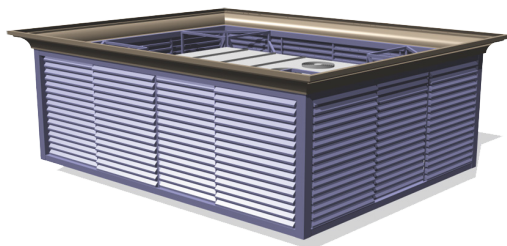


SINGLE UNIT

☐


CUSTOM PANELS

☐


STACKED SYSTEM

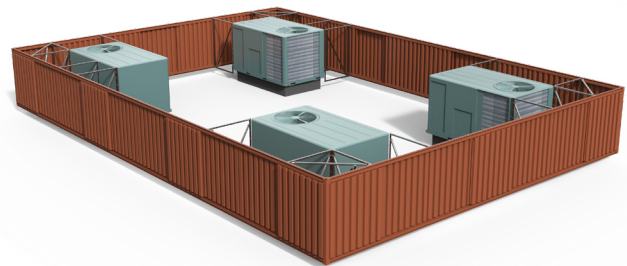☐


NESTED UNITS

☐

SCREENING SYSTEM & STYLE SELECTIONS

Please mark your final selections for system type, panel style, panel style, trim, and colors. **Note: Selection of a custom option or changing your selection after initial quote may have extended lead times and addition cost.**

PANEL STYLES | SELECT THE PANEL STYLE YOUR PROJECT WILL USE



LOUVER

☐


HORIZONTAL RIB

☐



7.2 RIB

☐



FLAT PAN

☐


BATTEN

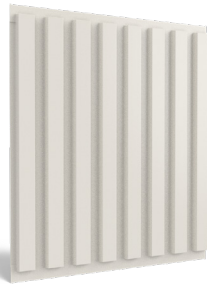☐


VERTICAL RIB

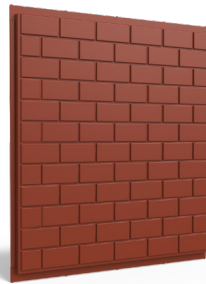☐


BRICK


☐


CUSTOM

☐

PANEL COLOR OPTIONS | SELECT THE PANEL COLOR PROJECT WILL USE

Standard colors are shown here. Need a custom color? Provide a Sherwin Williams, RAL, PMS or a physical paint sample and we can color match.

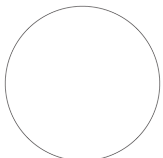

ALABASTER

☐



ELECTRIC BLACK

☐


SLATE BLUE

☐


FOREST GREEN

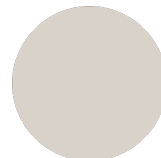☐


SHADOW GRAY

☐


SLATE GRAY

☐



DARK BRONZE

☐



OYSTER

☐


PUTTY

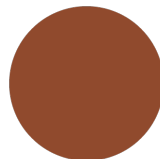☐


TERRACOTTA

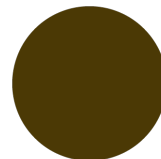☐


MANSARD BROWN

☐


CUSTOM COLOR

☐


ARCYICAP[®] ABS SUBMITTAL FORM

SCREENING SYSTEM & STYLE SELECTIONS

Please mark your final selections for system type, panel style, trim, and colors. **Note: Selection of a custom option or changing your selection after initial quote may have extended lead times and addition cost.**


TRIM STYLES | SELECT THE TRIM STYLE YOUR PROJECT WILL USE

*Trim is optional and prices vary by style. If you wish to have no trim mark: No Trim.

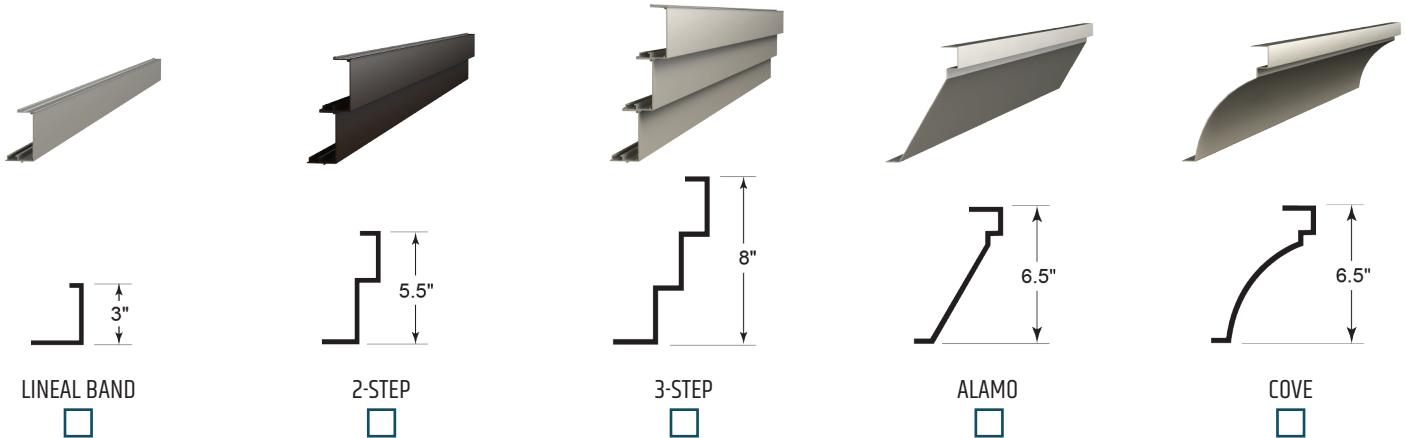

TRIM COLOR OPTIONS | SELECT THE TRIM COLOR PROJECT WILL USE

Standard colors are shown here. Need a custom color? Provide a Sherwin Williams, RAL, PMS or a physical paint sample and we can color match.

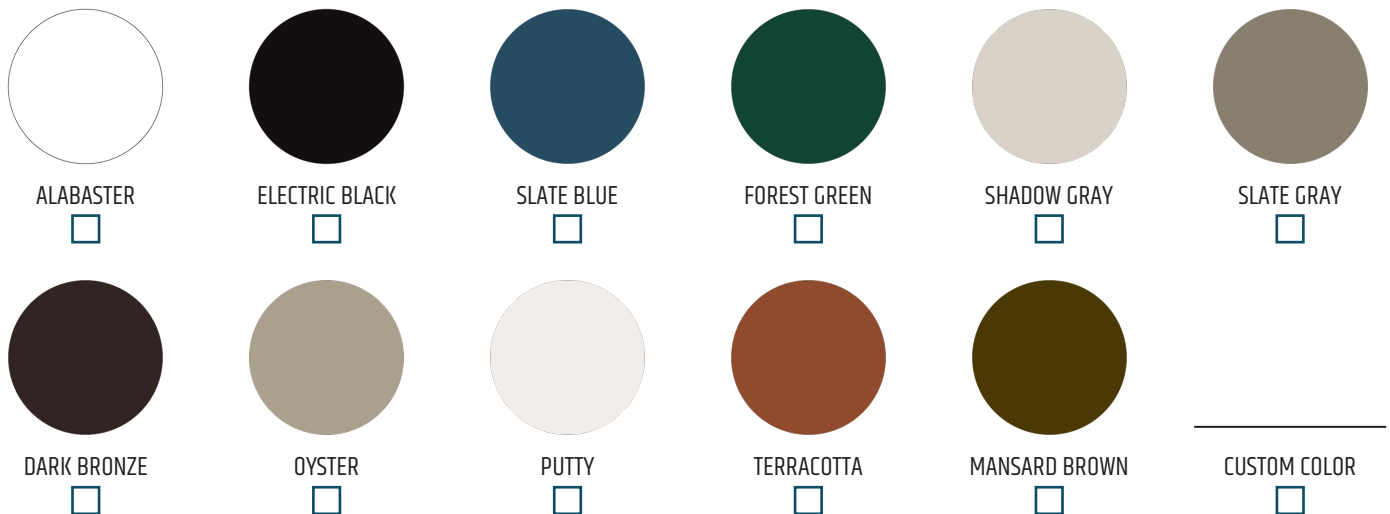


SIGNATURE: _____ DATE: _____

MENU BOARD SIGN – DESTINY CHURCH

- Free standing next to the building
- 40” vertical x 78” horizontal
- 10MM pixels with black frame
- 5 year warranty and lifetime Tech support
- Connects to regular 110 volt power
- One pole installed in concrete



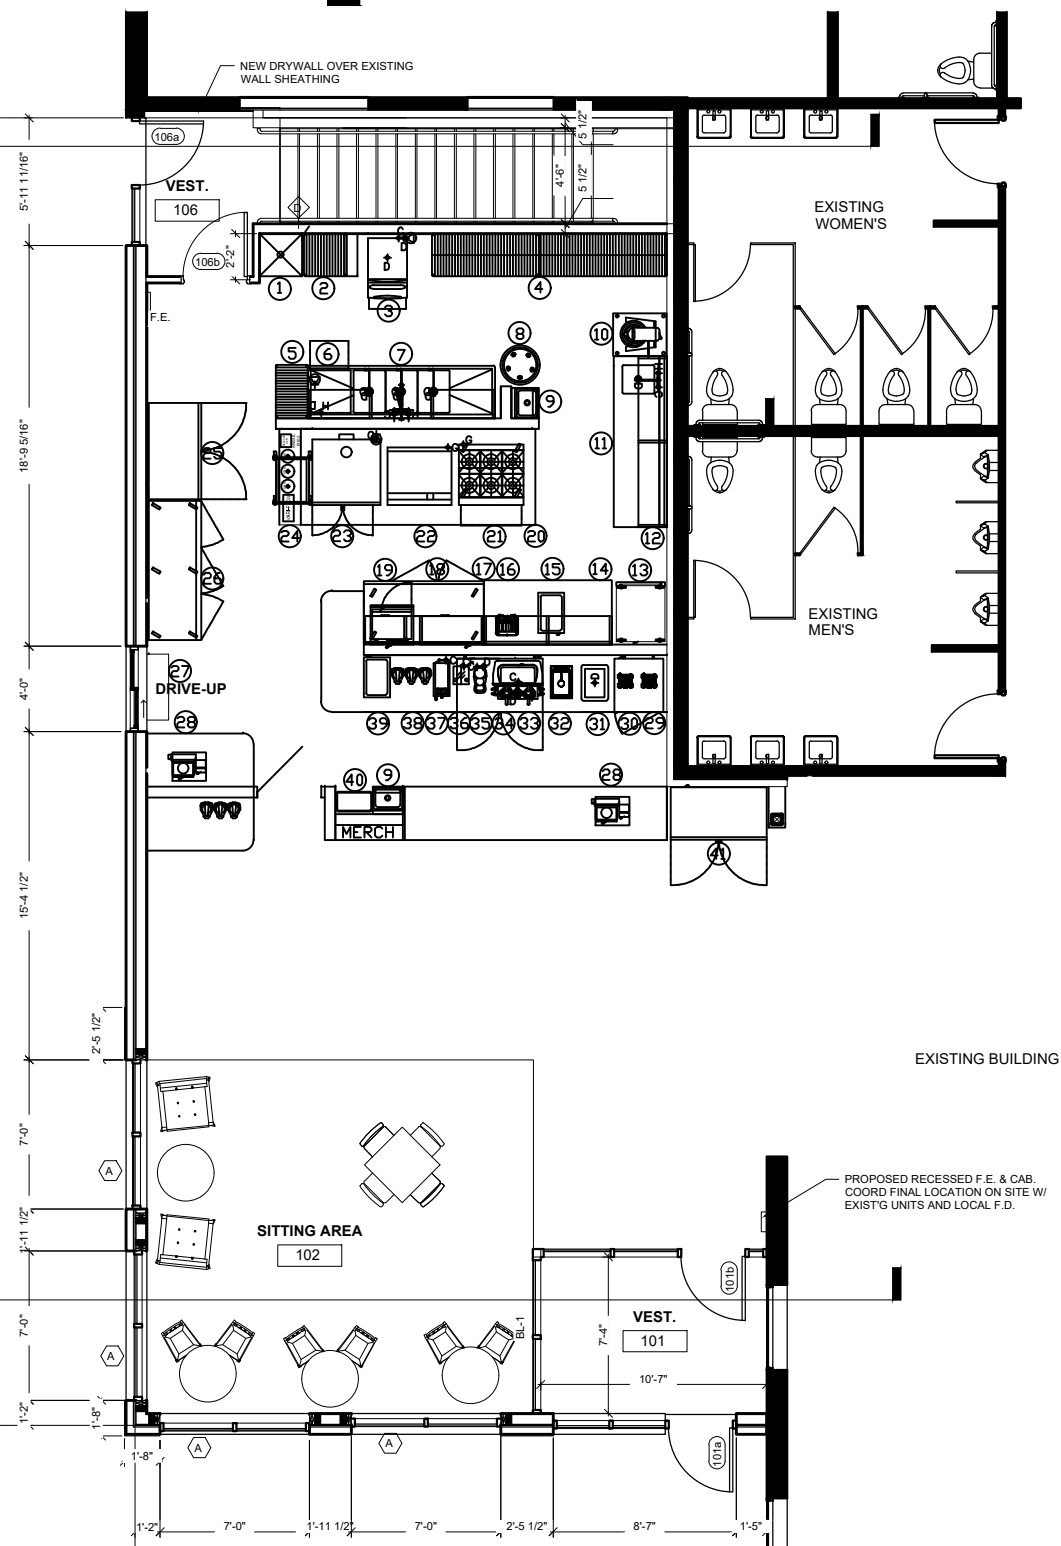



04/22/2024

53426


Quote

Project: Destiny Church - The Well

From: Warehouse Restaurant Equipment
 Marty Seeman
 995 N.Military Ave.
 GreenBay, WI 54303-
 920-499-1288
 (920)499-2729 (Fax)
 marty@wregreenbay.com

Thank you for the opportunity to quote

Item	Qty	Description	Sell	Sell Total
1	1 ea	MOP SINK Custom MOP SINK Mop Sink - By Plumber		
2	4 ea	WIRE SHELVE Olympic J2424K Packed 4 ea Shelf, wire, 24" x 24", green epoxy finish with chromate substrate, NSF Dimensions 24(w) x 24(d)	\$43.67	\$174.68
	4 ea	1 year warranty against manufacturing defects		
	4 ea	7 year warranty against rust and corrosion		
	4 ea	J74K Post 74", stationary, grooved at 1" intervals, includes leveling bolt & cap, green epoxy finish with chromate substrate, NSF	\$18.65	\$74.60
	Class 70	Weight: 52 lbs total		
			Extended Total:	\$249.28
3	1 ea	ICE MAKER, CUBE-STYLE Manitowoc IYT0420A Indigo NXT™ Series Ice Maker, cube-style, air-cooled, self-contained condenser, 22"W x 24-1/2"D x 21-1/2"H, production capacity up to 460 lb/24 hours at 70°/50° (375 lb AHRI certified at 90°/70°), easyTouch display with 13 different language options, date/time stamp display, automatic reminder/alert icon, one touch asset information, automatic detection of accessories, continuous operating status, programmable production options (time, weight, day or night), one touch cleaning with displayed instructions, Alpha-San anti-microbial protection, acoustical ice sensing probe, self-diagnostic technology,	\$3,805.33	\$3,805.33

 Item	Qty	Description	Sell	Sell Total
		DuraTech™ exterior, half-dice size cubes, R410A refrigerant, NSF, cULus, CE, ENERGY STAR® Dimensions 21.5(h) x 22(w) x 24.5(d)		
	1 ea	WARRANTY-ICE-SC 3 year parts & labor (Machine), 5 year parts & labor (Evaporator), 5 year parts & 3 years labor (Compressor), standard		
	1 ea	(-161) 115v/60/1-ph, 11.3 amps		
	1 ea	AR-10000-P Arctic Pure® Plus Primary Water Filter Assembly, includes head, shroud, hardware, mounting assembly, & (1) filter cartridge, 15,000 gallon capacity, 0-600 lbs./ice per day	\$251.63	\$251.63
	1 ea	WARRANTY-ARCPURE 3 year parts & labor warranty on cap, housing, hardware, & mounting assembly (does not refer to filter cartridge), standard		
	1 ea	D320 Ice Bin, 22"W x 34"D x 38"H, with side-hinged front-opening door, side grips, 264 lbs. application capacity, AHRI certified 8.9 cu. ft., for top-mounted ice maker, Duratech exterior, NSF	\$1,298.76	\$1,298.76
	1 ea	WARRANTY-BIN/DISP 3 year parts & labor warranty, standard		
	1 ea	Legs, 6" adjustable stainless steel, standard		
Class 92.5		Weight: 215 lbs total		
			Extended Total:	\$5,355.72
4	4 ea	WIRE SHELVING Olympic J2460C Packed 2 ea Shelf, wire, 24" x 60", chromate finish, NSF Dimensions 60(w) x 24(d)	\$62.48	\$249.92
				
	4 ea	J2472C Shelf, wire, 24" x 72", chromate finish, NSF	\$73.63	\$294.52
	1 ea	1 year warranty against manufacturing defects		
	8 ea	J74C Post 74", stationary, grooved at 1" intervals, includes leveling bolt & cap, chrome finish, NSF	\$17.53	\$140.24
Class 70		Weight: 220 lbs total		
			Extended Total:	\$684.68
5	4 ea	WIRE SHELVING Olympic J1830K Packed 4 ea Shelf, wire, 18" x 30", green epoxy finish with chromate substrate, NSF Dimensions 30(w) x 18(d)	\$36.98	\$147.92
				
	4 ea	1 year warranty against manufacturing defects		
	4 ea	7 year warranty against rust and corrosion		
	4 ea	J74K Post 74", stationary, grooved at 1" intervals, includes leveling bolt & cap, green epoxy finish with chromate substrate, NSF	\$18.65	\$74.60
Class 70		Weight: 48 lbs total		
			Extended Total:	\$222.52

Item	Qty	Description	Sell	Sell Total
6	1 ea	DISHWASHER, UNDERCOUNTER  Moyer Diebel 201HT-70 Dishwasher, undercounter, 24"W, high temperature sanitizing with built-in electric booster heater, configured for 180° final rinse, approximately (25) racks/hour capacity, 15-3/4"H door clearance, digital temperature monitoring, Multi-Power allows infield electrical conversion, Soft Start, Rinse Sentry & Scrub feature, de-lime cycle, fresh water wash & pumped rinse, interchangeable upper & lower spray arms, built-in detergent & rinse-aid dispensing pumps, advance service diagnostics, counter balanced door, 2 kW wash tank heater, pumped drain, includes (1) flat & (1) peg rack, stainless steel construction, 1 HP wash pump, cETLus, NSF Dimensions 33.75(h) x 24(w) x 25(d) 1 ea 1 year parts and labor warranty, standard 1 ea 6 kW booster, built-in, 70° rise booster, standard 1 ea Voltage to be verified with jobsite Class 92.5 Weight: 198 lbs total	\$4,565.00	\$4,565.00
			Extended Total:	\$4,565.00
7	1 ea	THREE (3) COMPARTMENT SINK  John Boos 3B18244-2D24-X "B" Series Sink, 3-compartment, 105-1/4"W x 29-1/2"D x 44"H overall size, (3) 18"W x 24" front-to-back x 14" deep compartments, (2) 24" left & right drainboards, 10"H boxed backsplash with 45° top and 2" return, (1) set of splash mount faucet holes with 8" centers, 3-1/2" die-stamped drain openings, 16/300 stainless steel construction, stainless steel legs, adjustable side bracing, adjustable bullet feet, NSF, CSA-Sanitation (Available in Effingham and Nevada) Dimensions 44(h) x 105.25(w) x 29.5(d) 1 ea Krowne 17-109WL Krowne Royal Series, pre-rinse Assembly, with add-on faucet, wall mount, 8" centers, spring action flexible gooseneck, 38"H stainless steel hose with 15" overhang & 1.2 GPM spray head, built in check valves, 2.0 GPM add-on faucet with 12" swing spout, quarter-turn ceramic cartridge valves, includes wall bracket & mounting kit, chrome plated brass base, low lead compliant, includes internal check valves to prevent backflow & cross contamination, NSF (interchangeable with most brands) (ships pre-assembled) 1 ea Krowne 3 year warranty, standard 3 ea T&S Brass B-3952 Waste Valve, twist handle, 3-1/2" sink opening, 2" drain outlet (replaces B-3913, B-3917) 2 ea BHS1636-X Shelf, wall-mounted, 36"W x 16"D x 13"H overall size, 1-1/2" rear up-turn, Stallion Safety Edge front, 18/300 stainless steel, NSF, KD (Available in Effingham and Nevada) NOTE: WALL SHELVES TO BE MOUNTED BY GENERAL CONTRACTOR Class 250 Weight: 195.1 lbs total	\$2,215.35	\$2,215.35
			\$401.31	\$401.31
			\$79.70	\$239.10
			\$167.40	\$334.80

Item	Qty	Description	Sell	Sell Total
			Extended Total:	\$3,190.56
8	1 ea	COMMERCIAL WASTE CONTAINER Winco PTC-32G Trash Can, 32 gallon, 26-3/4"L x 21-3/4"W x 30-3/4"H, large, heavy duty, HDPE, gray (lid not included) (Qty Break = 1 each) Dimensions 30.75(h) x 26.75(w) x 21.75(d)	\$58.31	\$58.31
				
	1 ea	DLR-18 Dolly, 18" dia. x 6"H, round, holds up to 400 lbs., heavy duty, black, plastic (Qty Break = 6 each) Weight: 15.83 lbs total	\$43.15	\$43.15
			Extended Total:	\$101.46
9	2 ea	HAND SINK John Boos PBHS-W-1410-KV2MB-X Pro-Bowl Hand Sink, wall mount, 14"W x 10" front-to-back x 5" deep bowl, (1) centered splash mount faucet hole, gooseneck spout, double knee valves, 2" drain opening, includes basket drains & wall brackets, all stainless steel construction, NSF, CSA-Sanitation (knee valve faucet included) (Available in Effingham and Nevada) Dimensions 20(h) x 17(w) x 15.5(d)	\$579.15	\$1,158.30
				
	2 ea	Standard flyer accessories only, NO modifications to flyer items allowed or their accessories		
	Class 85	Weight: 50 lbs total		
			Extended Total:	\$1,158.30
10	1 ea	PLANETARY MIXER Globe (Middleby) SP20 (QUICK SHIP) Planetary Mixer, bench model, 20 qt. (19 liter) capacity, 3-speed (fixed), #12 hub, includes: stainless steel removable bowl guard with built-in ingredient chute, 20 qt. stainless steel bowl, aluminum spiral dough hook, stainless steel wire whip & aluminum flat beater, interlocked bowl lift, gear-driven motor, front-mounted touchpad controls with 60-minute digital timer & last batch recall, non-slip rubber feet, cast iron body, enamel gray finish, 1/2 HP, 115v/60/1-ph, 6.0 amps, cord, NEMA 5-15P, NSF, cETLus (Ships within 1-2 days) Dimensions 41(h) x 22(w) x 23.5(d)	\$3,241.84	\$3,241.84
				
	1 ea	Quick Ship items have limited configurations & that standard configuration may not apply. Contact factory for details		
	1 ea	2 year parts & labor warranty (1 year parts only warranty on agitator and hub accessories, no labor provided) (excludes wear items), standard		
	1 ea	John Boos MS4-2430SSK-X Machine Stand, heavy duty, 30"W x 24"D x 20-1/4"H overall size, 14/300 stainless steel top with marine edge, stainless steel adjustable lower shelf, stainless steel legs & bullet feet, NSF, KD (Available in Effingham and Nevada)	\$589.95	\$589.95

Item	Qty	Description	Sell	Sell Total
	1 ea	John Boos Standard flyer accessories only, NO modifications to flyer items allowed or their accessories		
	Class 85	Weight: 266 lbs total		
			Extended Total:	\$3,831.79
11	1 ea	WORK TABLE, 96", STAINLESS STEEL TOP	\$1,885.01	\$1,885.01
		John Boos ST6R5-3096SSK		
		Work Table, 96"W x 30"D, 16/300 stainless steel top with 5" backsplash, with Stallion Safety Edge front, 90° turndown on sides, stainless steel legs & adjustable undershelf, adjustable bullet feet, NSF, CSA-Sanitation, KD		
		Dimensions 40.75(h) x 96(w) x 30(d)		
	1 ea	CUT1618126 Weld-In Undermount Sink, 1-compartment, 16"W x 18" front-to-back x 12" deep, 3-1/2" drain opening, 16/300 stainless steel fabricated bowl, includes cutout, bowl, faucet holes & welding/polishing (Not available for FBLG & UFBLG)	\$712.62	\$712.62
		NOTE: 8" ON CENTER DECK MOUNT HOLES FAUCET BY OTHERS		
	1 ea	X-0205A On the left (modification)		
	1 ea	X-0208A1 Plumbing Cutout, 12" x 12" in lower shelf or back panel (modification)	\$83.78	\$83.78
	1 ea	Krowne 15-802L Krowne Royal Series Faucet, deck mount, 8" centers, 8-1/2" gooseneck spout, 1/4 turn ceramic cartridge valve, low lead compliant, NSF, Includes internal check valves to prevent backflow & cross contamination	\$176.60	\$176.60
	1 ea	Krowne 3 year warranty, standard		
	1 ea	T&S Brass B-3952 Waste Valve, twist handle, 3-1/2" sink opening, 2" drain outlet (replaces B-3913, B-3917)	\$79.70	\$79.70
	Class 125	Weight: 180.2 lbs total		
			Extended Total:	\$2,937.71
12	1 ea	OVERSHELF	\$888.75	\$888.75
		John Boos BHS1696PR-16/304		
		Shelf, wall mount with pot rack, 96"W x 16"D x 13"H overall size, 1-1/2"H rear up-turn, Stallion Safety Edge front, includes (8) stainless steel hooks, 16/300 stainless steel, KD, NSF		
		Dimensions 13(h) x 96(w) x 16(d)		
		NOTE: WALL SHELVES TO BE MOUNTED BY GENERAL CONTRACTOR		
	Class 55	Weight: 53 lbs total		
			Extended Total:	\$888.75
13	1 ea	HEATED HOLDING PROOFING CABINET, MOBILE	\$3,788.00	\$3,788.00
		Metro C539-CFC-U		
		Quick Ship - C5™ 3 Series Heated Holding & Proofing Cabinet, with Red Insulation Armour™, mobile, full height, insulated, clear polycarbonate door, removable bottom mount control module, thermostat to 200°F, universal wire slides on 3" centers, adjustable on		

Item	Qty	Description	Sell	Sell Total
	1 ea	1-1/2" increments (18) 18" x 26" or (34) 12" x 20" x 2-1/2" pan capacity, 5" casters (2 with brakes), aluminum, 120v/60/1-ph, 2000 watts, 16.7 amps, NEMA 5-20P, cULus, NSF Dimensions 71(h) x 27.63(w) x 31.5(d)		
	1 ea	1 year warranty against manufacturing defects		
Class 100		Weight: 262 lbs total		
			Extended Total:	\$3,788.00
14	1 ea	WORK TABLE, 72", STAINLESS STEEL TOP	\$1,145.00	\$1,145.00
		John Boos ST6R1.5-3672SSK-X		
		Work Table, 72"W x 36"D, 16/300 stainless steel top with 1-1/2"H rear up-turn, with Stallion Safety Edge front, 90° turndown on sides, stainless steel legs & adjustable undershelf, adjustable bullet feet, NSF, CSA-Sanitation, KD (Available in Effingham and Nevada) Dimensions 37.25(h) x 72(w) x 36(d)		
	1 ea	Standard flyer accessories only, NO modifications to flyer items allowed or their accessories		
Class 85		Weight: 126 lbs total		
			Extended Total:	\$1,145.00
15	1 ea	FOOD PAN WARMER, COUNTERTOP	\$198.00	\$198.00
		Nemco Food Equipment 6055A		
		Countertop Warmer, wet operation, accepts 12" x 20" full size pan or fractional size pans, adjustable thermostat, cycling indicator pilot light, stainless steel construction, 1200 watts, NEMA 5-15P, 120v/60/1ph, 10 amps, cETLus, NSF Dimensions 9(h) x 14.63(w) x 23.5(d)		
	1 ea	1 year parts & labor warranty, standard		
Class ups		Weight: 24 lbs total		
			Extended Total:	\$198.00
16	1 ea	POP-UP TOASTER	\$260.00	\$260.00
		Waring WCT708		
		Commercial Toaster, medium-duty, (4) extra wide 1-3/8" slots, (4) slice capacity (up to 225 slices/hr), (2) rotary dial to adjust browning controls, removable crumb tray, brushed chrome finish, 3-prong plug, 120v/60/1-ph, 15 amps, 1800 watts, cETLus, NSF Dimensions 8.5(h) x 12.75(w) x 14.25(d)		
	1 ea	1 year limited warranty, standard		
For Customer Care & Product Service, please contact:				
(800) 269-6640				
waring_service@conair.com				
Waring Customer Care				
314 Ella T. Grasso Ave				
Torrington, CT 06790				

Item	Qty	Description	Sell	Sell Total
Class ups		Weight: 8.6 lbs total		
			Extended Total:	\$260.00
17	1 ea	SHELVING, WALL MOUNTED John Boos BHS1672-X Shelf, wall-mounted, 72"W x 16"D x 13"H overall size, 1-1/2"H rear up- turn, Stallion Safety Edge front, 18/300 stainless steel, NSF, KD (Available in Effingham and Nevada) Dimensions 13(h) x 72(w) x 16(d)	\$267.30	\$267.30
	1 ea	BHS1636-X Shelf, wall-mounted, 36"W x 16"D x 13"H overall size, 1- 1/2" rear up-turn, Stallion Safety Edge front, 18/300 stainless steel, NSF, KD (Available in Effingham and Nevada)	\$167.40	\$167.40
NOTE: WALL SHELVES TO BE MOUNTED BY GENERAL CONTRACTOR				
Class 55		Weight: 44 lbs total		
			Extended Total:	\$434.70
18	1 ea	PIZZA PREPARATION REFRIGERATOR True Mfg. - General Foodservice TPP-AT-67-HC Pizza Prep, 33 - 41°F pan rail, stainless steel cover, 19-1/2"D cutting board, (2) full doors, (4) PVC coated adjustable wire shelves, includes: (9) 1/3 size clear polycarbonate insert pans (top), stainless steel front, top & sides, aluminum interior with stainless steel floor, front breathing, R290 Hydrocarbon refrigerant, 1/4 HP, 115v/60/1-ph, 3.9 amps, NEMA 5-15P, UL EPH Classified, cULus, CE, Made in USA Dimensions 38.88(h) x 67.38(w) x 33.63(d)	\$5,721.32	\$5,721.32
	1 ea	7 year compressor warranty, 7 years parts warranty, 7 year labor warranty, standard. Visit www.truemfg.com for specifics.		
	1 ea	Self-contained refrigeration standard		
	1 ea	5" Castors, standard		
Class 150		Weight: 450 lbs total		
			Extended Total:	\$5,721.32
19	1 ea	MICROWAVE OVEN ACP RCS10TS Amana® Commercial Microwave Oven, 1000 watts, 1.2 cu. ft. capacity, medium volume, 4-stage cooking, (5) power levels, (100) memory settings, braille touch pads, non-removable air filter, side hinged door with tempered glass, accommodates 14" plate, stainless steel interior & exterior, 120v/60/1-ph, 13.0 amps, 15 MCA, 1550 watts (total), NEMA 5-15P, cETLus, ETL-Sanitation Dimensions 13.75(h) x 22(w) x 19(d)	\$724.00	\$724.00
	1 ea	3-year limited warranty (1 year full)		
	1 ea	John Boos BMS2024-X Microwave Shelf, wall mount, 24"W x 20"D x 15"H, Stallion Safety Edge front, 2-1/2" electric cord cut-out with rubber grommet, 16/300 stainless steel construction, NSF (Available in Effingham and Nevada)	\$253.80	\$253.80

Item	Qty	Description	Sell	Sell Total
NOTE: WALL SHELVES TO BE MOUNTED BY GENERAL CONTRACTOR				
Class ups		Weight: 78 lbs total		
			Extended Total:	\$977.80
20	1 ea	EXHAUST HOOD Custom EXHAUST HOOD Exhaust Hood - By Others		
21	1 ea	RANGE, 36", 6 OPEN BURNERS Southbend (Middleby) 4361D (QUICK SHIP) Ultimate Restaurant Range, gas, 36", (6) non-clog burners, standard grates, standing pilot, (1) standard oven with battery spark ignition, includes (1) rack, 22-1/2" flue riser with shelf, stainless steel front, sides, shelf & 6" adjustable legs, 243,000 BTU, CSA, NSF (Ships within 2 days, maximum quantity = 2 per order) Dimensions 59.5(h) x 36.5(w) x 34(d) 1 ea Quick Ship items have limited configurations & that standard configuration may not apply. Contact factory for details 1 ea Domestic Shipping, inside of North America 1 ea Standard one year limited warranty (range) 1 ea Natural Gas 1 ea NOTE: 22.5" high flue riser, with heavy duty shelf, standard 1 ea Casters, 2 locking & 2 standard, in lieu of legs 1 kt Dormont 1675KIT48 Dormont Blue Hose™ Moveable Gas Connector Kit, 3/4" inside dia., 48" long, covered with stainless steel braid, coated with blue antimicrobial PVC, (1) SnapFast® QD, (1) full port valve, (2) 90° elbows, coiled restraining cable with hardware, 180,000 BTU/hr minimum flow capacity, limited lifetime warranty	\$4,073.00	\$4,073.00
Class 92.5		Weight: 665.85 lbs total		
			Extended Total:	\$4,534.25
22	1 ea	GRIDDLE, GAS, COUNTERTOP Star (Middleby) 836TA Ultra-Max® Griddle, countertop gas, 36" W x 24" D cooking surface, 1" thick steel griddle plate, 150° - 550° F embedded mechanical snap-action thermostat every 12", 4-3/8" tapered wrap-around splash guard, 3-1/2" front grease trough, heavy-duty metal knobs, standing pilot, welded steel frame with stainless steel exterior, 4" stainless steel legs with 1-3/8" adjustment, 90,000 BTU, cULus, UL EPH (Note: Quick ship is only available with Natural Gas) Classified, Made in USA Dimensions 18(h) x 36(w) x 34.2(d) 1 ea 2 year parts & labor warranty, standard 1 ea Gas type to be specified 1 ea STAND/HC-36 Ultra-Max® 36" Stand, with casters, stainless steel construction, rated for 400 lbs. [181kg] 1 kt Dormont 1675KIT48 Dormont Blue Hose™ Moveable Gas Connector Kit,	\$5,443.44	\$5,443.44
			\$1,517.61	\$1,517.61
			\$225.00	\$225.00

Item	Qty	Description	Sell	Sell Total
		3/4" inside dia., 48" long, covered with stainless steel braid, coated with blue antimicrobial PVC, (1) SnapFast® QD, (1) full port valve, (2) 90° elbows, coiled restraining cable with hardware, 180,000 BTU/hr minimum flow capacity, limited lifetime warranty		
	Class 85	Weight: 482.85 lbs total		
			Extended Total:	\$7,186.05
23	1 ea	CONVECTION OVEN, GAS	\$6,407.50	\$6,407.50
		 Blodgett (Middleby) ZEPH-100-G SGL Zephair Convection Oven, gas, single-deck, standard depth, capacity (5) 18" x 26" pans, (SSI-M) solid state infinite controls with 60 min. manual timer, two speed fan, dependent glass doors, interior light, stainless steel front, sides and top, 25" stainless steel legs, 50,000 BTU, ETL, NSF Dimensions 57(h) x 38.25(w) x 36.88(d)		
	1 ea	Quick Ship items have limited configurations & that standard configuration may not apply. Contact factory for details		
	1 ea	2 year parts, 2 year labor and 1 additional year door warranty (parts only), standard		
	1 ea	Natural gas		
	1 ea	115v/60/1-ph, 6.0 amps, 2-wire with ground, cord & plug, 1/2 hp, standard		
	1 ea	SSI-M Solid State infinite control with 60 min. manual timer		
	1 ea	Draft diverter, stainless steel, standard		
	1 st	25" legs, adjustable, stainless steel (set), standard		
	1 ea	6" stem casters	\$225.00	\$225.00
	1 ea	NOTE: DO NOT deduct cost of standard legs		
	1 kt	Dormont 1675KIT48 Dormont Blue Hose™ Moveable Gas Connector Kit, 3/4" inside dia., 48" long, covered with stainless steel braid, coated with blue antimicrobial PVC, (1) SnapFast® QD, (1) full port valve, (2) 90° elbows, coiled restraining cable with hardware, 180,000 BTU/hr minimum flow capacity, limited lifetime warranty	\$225.00	\$225.00
	Class 77.5	Weight: 540.85 lbs total		
			Extended Total:	\$6,857.50
24	1 ea	BUN / SHEET PAN RACK	\$325.00	\$325.00
		 John Boos ABPR-1820-3KD Bun Pan Rack, mobile, (20) pan capacity, 3" spacing, front loading, 26"W x 20-1/2"D x 69"H, 1" square tube frame with bolted cross bracing, 5" swivel casters, 6063 aluminum construction, KD, NSF Dimensions 69(h) x 26(w) x 20.5(d)		
	Class 300	Weight: 30 lbs total		
			Extended Total:	\$325.00
25	1 ea	REACH-IN FREEZER	\$6,488.96	\$6,488.96

Item	Qty	Description	Sell	Sell Total
		True Mfg. - General Foodservice T-49F-HC Freezer, reach-in, two-section, -10°F, (2) stainless steel doors, (6) PVC coated adjustable wire shelves, interior lighting, stainless steel front, aluminum sides, aluminum interior with stainless steel floor, 4" castors, R290 Hydrocarbon refrigerant, 1 HP, 115v/60/1-ph, 9.6 amps, NEMA 5-15P, Made in USA, cULus, UL EPH Classified, ENERGY STAR® Dimensions 78.38(h) x 54.13(w) x 29.5(d)		
	1 ea	7 year compressor warranty, 7 years parts warranty, 7 year labor warranty, standard. Visit www.truemfg.com for specifics.		
	1 ea	Self-contained refrigeration standard		
	1 ea	Left door hinged left, right door hinged right standard		
	1 ea	4" stem castors, standard (adds 5" to OA height)		
	Class 150	Weight: 440 lbs total		
			Extended Total:	\$6,488.96
26	1 ea	REACH-IN REFRIGERATOR	\$6,650.49	\$6,650.49
		True Mfg. - General Foodservice T-72-HC Refrigerator, reach-in, three-section, (3) stainless steel doors, (9) PVC coated adjustable wire shelves, interior lighting, stainless steel front, aluminum sides, aluminum interior with stainless steel floor, 4" castors, R290 Hydrocarbon refrigerant, 3/4 HP, 115v/60/1-ph, 6.9 amps, NEMA 5-15P, cULus, UL EPH Classified, Made in USA Dimensions 78.38(h) x 78.13(w) x 29.5(d)		
	1 ea	7 year compressor warranty, 7 years parts warranty, 7 year labor warranty, standard. Visit www.truemfg.com for specifics.		
	1 ea	Self-contained refrigeration standard		
	1 ea	Left door hinged left, center & right doors hinged right, standard		
	1 ea	4" stem castors, standard (adds 5" to OA height)		
	Class 150	Weight: 575 lbs total		
			Extended Total:	\$6,650.49
27	1 ea	DRIVE THRU WINDOW Custom DRIVE THRU WINDOW Drive Thru Window - By Others		
28	1 ea	POS SYSTEM Custom POS SYSTEM POS System - By Others		
29	1 ea	UNDERCOUNTER REFRIGERATOR	\$2,216.11	\$2,216.11
		True Mfg. - General Foodservice TUC-27-HC Undercounter Refrigerator, 33 - 38°F, (1) stainless steel door, (2) PVC coated adjustable wire shelves, stainless steel top, front & sides, clear coated aluminum interior with stainless steel floor, R290 Hydrocarbon refrigerant, 1/6 HP, 115v/60/1-ph, 2.0 amps, NEMA 5-15P, cULus, UL EPH Classified, CE, Made in USA Dimensions 29.75(h) x 27.63(w) x 30.13(d)		

Item	Qty	Description	Sell	Sell Total
	1 ea	7 year compressor warranty, 7 years parts warranty, 7 year labor warranty, standard. Visit www.truefmfg.com for specifics.		
	1 ea	Self-contained refrigeration standard		
	1 ea	Right Hand, Standard: Unit comes with field reversible hinges & is built with hinging on right side of unit.		
	1 ea	Bolt locks, factory installed, standard		
	1 ea	Castors, 2-1/2" (33-1/2" work surface height)		
Class 150		Weight: 195 lbs total		
			Extended Total:	\$2,216.11
30	2 ea	BLENDER, BAR	\$450.00	\$900.00
		Vitamix 062828		
		Drink Machine™ (VM0100), 64 oz. (2 liter) BPA Free clear Tritan™ standard container with wet blade assembly, two-speed, includes: lid & tamper, black base, 2.3 peak HP, 120v/50/60/1-ph, 11.5 amps, NEMA 5-15P, cULus, NSF		
		Dimensions 20(h) x 7.52(w) x 8.74(d)		
	2 ea	3 years warranty on motor base parts & 1 year warranty on labor, standard		
	2 ea	001194 Blender Container, NO LID, high-impact, 64 oz. (2 liter) capacity, clear, with WET blade assembly, NSF (for Vita-Prep®, Vita-Prep3 and Drink Machine)	\$135.59	\$271.18
		Weight: 27.5 lbs total		
			Extended Total:	\$1,171.18
31	1 ea	DROP-IN ICE BIN	\$665.21	\$665.21
		Krowne D278		
		Krowne Ice Bin, drop-in, 20"W x 15"D O.A., 50 lbs ice capacity, 10" deep stainless steel liner, fully insulated, stainless steel top, includes stainless steel sliding cover, NSF (18-1/4" x 13-1/4" cutout required) (available with a cold plate – see D278-7)		
		Dimensions 12(h) x 20(w) x 15(d)		
Class 250		Weight: 35 lbs total		
			Extended Total:	\$665.21
32	1 ea	HAND SINK	\$308.31	\$308.31
		Krowne HS-1225		
		Drop-In Hand Sink, 12"W x 18"D x 10-1/2"H OA, 10" wide x 14" front-to-back x 5" deep compartment, 4" OC deck mount faucet with 6" gooseneck spout (low lead compliant), 5-1/2" rear & side splashes on left & right, 3-1/2" drain, stainless steel construction, NSF (10-1/2"W x 16-3/4"D cut-out required)		
		Dimensions 15.5(h) x 12(w) x 18(d)		
Class ups		Weight: 18 lbs total		
			Extended Total:	\$308.31
33	1 ea	ESPRESSO MACHINE		

Item	Qty	Description	Sell	Sell Total
		Custom ESPRESSO MACHINE Espresso Machine - By Owner		
34	1 ea	UNDERCOUNTER REFRIGERATOR True Mfg. - General Foodservice TUC-48-HC  Undercounter Refrigerator, 33 - 38°F, (2) stainless steel doors, (4) PVC coated adjustable wire shelves, stainless steel top & sides, aluminum interior with stainless steel floor, R290 Hydrocarbon refrigerant, 1/5 HP, 115v/60/1-ph, 3.0 amps, NEMA 5-15P, cULus, UL EPH Classified, CE, Made in USA Dimensions 29.75(h) x 48.38(w) x 30.13(d) 1 ea 7 year compressor warranty, 7 years parts warranty, 7 year labor warranty, standard. Visit www.truemfg.com for specifics. 1 ea Self-contained refrigeration standard 1 ea Bolt locks, factory installed, standard 1 ea Castors, 2-1/2" (33-1/2" work surface height) Class 150 Weight: 260 lbs total	\$3,328.19	\$3,328.19
			Extended Total:	\$3,328.19
35	1 ea	ESPRESSO GRINDER Custom ESPRESSO GRINDER Espresso Grinder - By Owners		
36	1 ea	COFFE GRINDER Custom COFFEE GRINDER Coffee Grinder - By Owner		
37	1 ea	AIR POT BREWER Custom AIR POT BREWER Air Pot Brewer With Hot Water Faucet - By Owner		
38	1 ea	AIR POTS Custom AIR POTS Air Pots - By Owner		
39	1 ea	FOOD PAN WARMER, COUNTERTOP Nemco Food Equipment 6055A  Countertop Warmer, wet operation, accepts 12" x 20" full size pan or fractional size pans, adjustable thermostat, cycling indicator pilot light, stainless steel construction, 1200 watts, NEMA 5-15P, 120v/60/1ph, 10 amps, cETLus, NSF Dimensions 9(h) x 14.63(w) x 23.5(d) 1 ea 1 year parts & labor warranty, standard Class ups Weight: 24 lbs total	\$198.00	\$198.00
			Extended Total:	\$198.00
40	1 ea	TRASH RECEPTACLE, INDOOR	\$39.70	\$39.70

Item	Qty	Description	Sell	Sell Total
		Winco PTC-23K Slender Trash Can, 23 gallon, 20-1/8"L x 10-7/8"W x 29-7/8"H, HDPE, black (lid not included) (Qty Break = 1 each) Dimensions 29.88(h) x 20.13(w) x 10.88(d)		
		Weight: 6.7 lbs total		
			Extended Total:	\$39.70
41	1 ea	REFRIGERATED MERCHANDISER	\$4,552.19	\$4,552.19
		True Mfg. - General Foodservice GDM-49-HC~TSL01 Refrigerated Merchandiser, two-section, True standard look version 01, (8) shelves, (2) double pane thermal insulated glass hinged doors, LED interior lights, powder coated steel exterior, white interior with stainless steel floor, R290 Hydrocarbon refrigerant, 1/2 HP, 115v/60/1- ph, 8.5 amps, NEMA 5-15P, cULus, UL EPH Classified, Made in USA, ENERGY STAR® Dimensions 78.63(h) x 54.13(w) x 29.88(d)		
	1 ea	7 year compressor warranty, 7 years parts warranty, 7 year labor warranty, standard. Visit www.truemfg.com for specifics.		
	1 ea	Self-contained refrigeration standard		
	1 ea	Exterior: Black powder coated steel, standard		
	1 ea	Interior: White aluminum, with white shelving, standard		
	1 ea	Left door hinged left, right door hinged right standard		
	1 ea	Barrel lock factory installed, two door model	\$432.80	\$432.80
	1 ea	Sign, Plain White in lieu of standard		
Class 150		Weight: 465 lbs total		
			Extended Total:	\$4,984.99
42	1 ea	DELIVERY	\$2,400.00	\$2,400.00
		Warehouse Restaurant Equipment DELIVERY Receive, uncrate, inspect for damage, deliver and set in place for final connections by others		
			Extended Total:	\$2,400.00
			Merchandise	\$83,064.53
			Freight	\$3,330.51
			Tax 5.5%	\$4,751.73
			Total	\$91,146.77

Pricing, specifications and availability subject to change without notice. Pricing does not include freight, delivery, set up, connections or any applicable sales tax unless otherwise stated. Any freight quoted is for estimate purposes only. No returns on non-stock or special order items.


Due to supply chain issues there may be additional manufacturer and freight surcharges that will be the responsibility of the customer.

Any listed lead times are approximate and may be extended without notice

**Warehouse Restaurant Equipment is not responsible for the lighting or required adjustments of gas equipment.
This service is available at an additional cost by a certified technician.**

Acceptance: _____ Date: _____
Printed Name: _____


R:\Jobs\2109-01-23 DESTINY CHURCH\DRAWINGS\2109-01-23 Eng.dwg 9/10/2024 12:11:55 PM

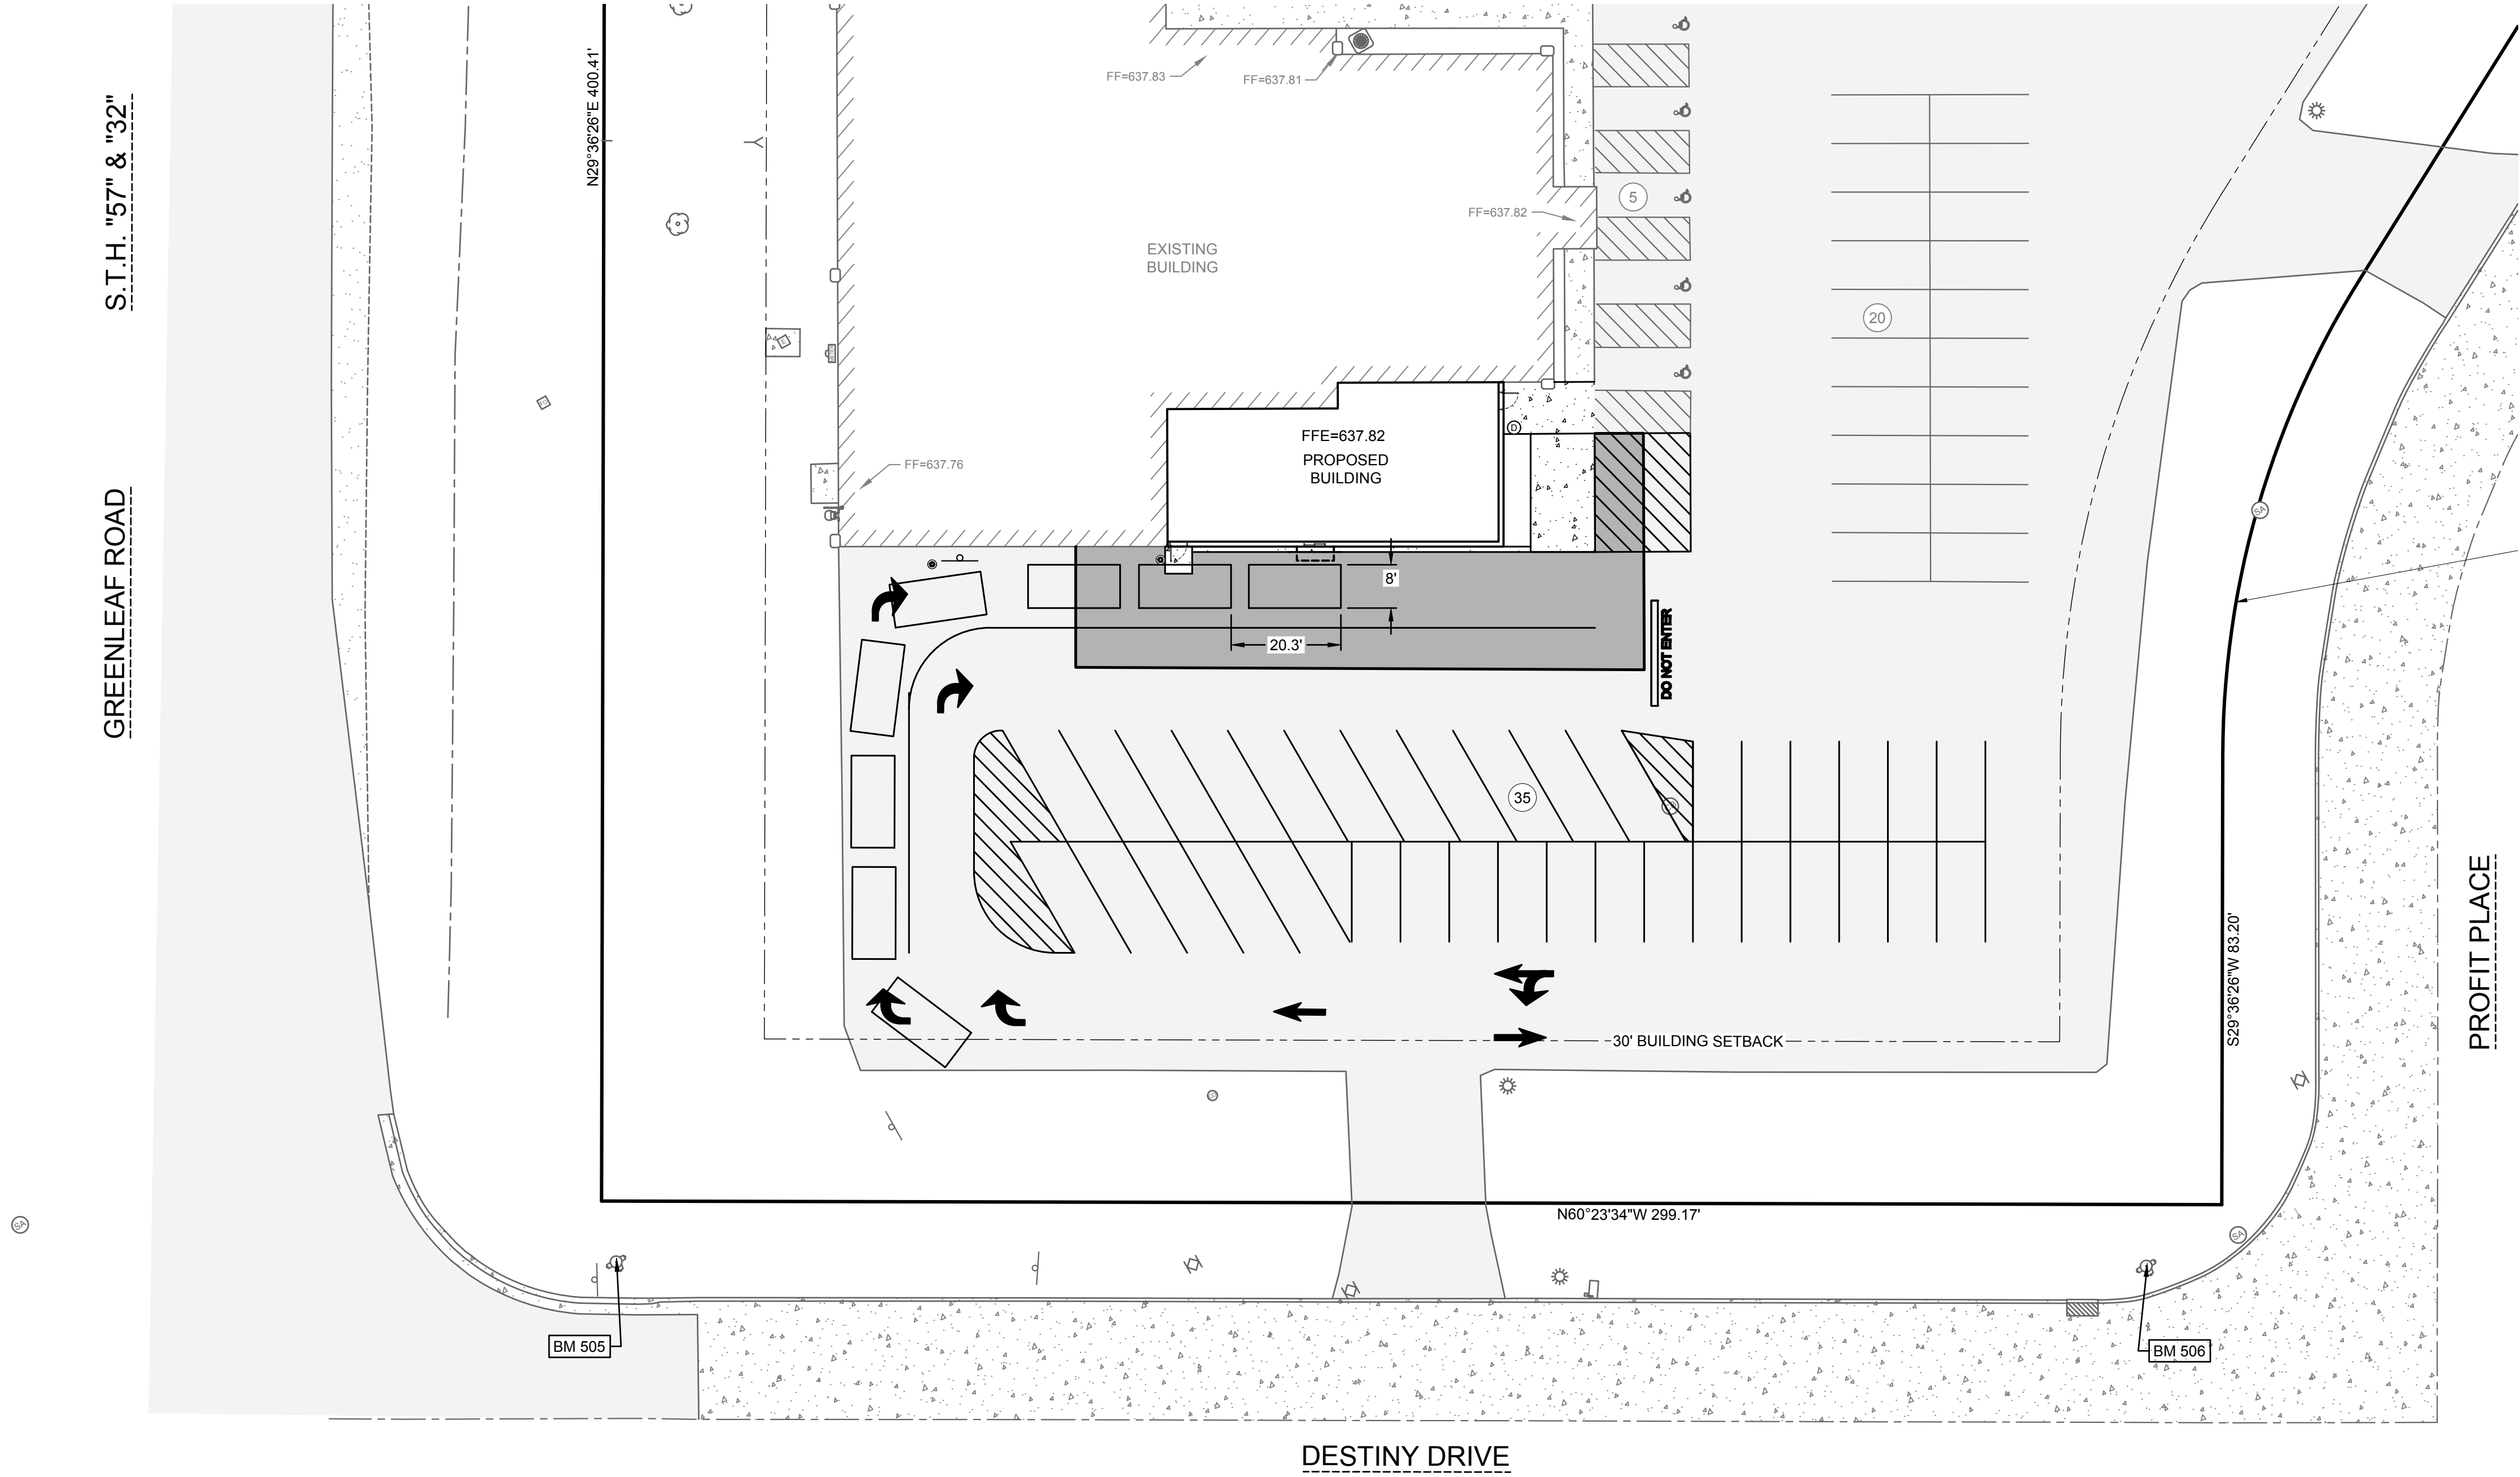

VEHICLE QUEUE EXHIBIT

OWNER

DESTINY CHURCH INC.
411 DESTINY DRIVE
DE PERE, WI 54115

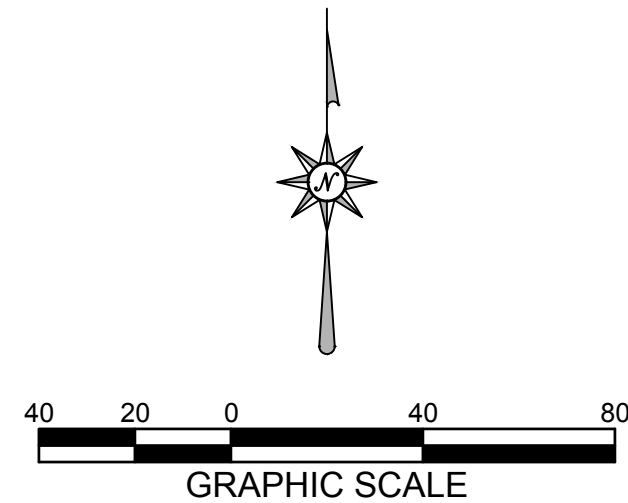

MACH IV
ENGINEERING • SURVEYING • ENVIRONMENTAL

2260 Salscheider Court Green Bay, WI 54313
PH: 920-569-5765; Fax: 920-569-5767
www.mach-iv.com
Project Number: 2109-01-23


Proposed Building Addition For:

DESTINY CHURCH

DEPERE, WISCONSIN

DATE: 11/02/23
ARCH: K. SPERL
D. BY: RPH
JOB: 22-025
REV.

EXH

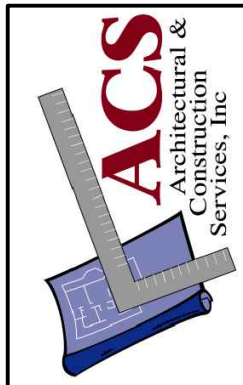

327 RANDOLPH DRIVE - SUITE C
APPLETON, WI 54913
TELE: 920-574-2857 FAX: 920-574-2660